

SCRIP PROPOSED OFFICE
J. TOPACIO STREET COR. C.M. RECTO HI-WAY
CLARK FREEPORT ZONE PAMPANGA






VIEW FROM MEETING ROOM



VIEW FROM PM'S OFFICE




VIEW FROM WORK'S STATION

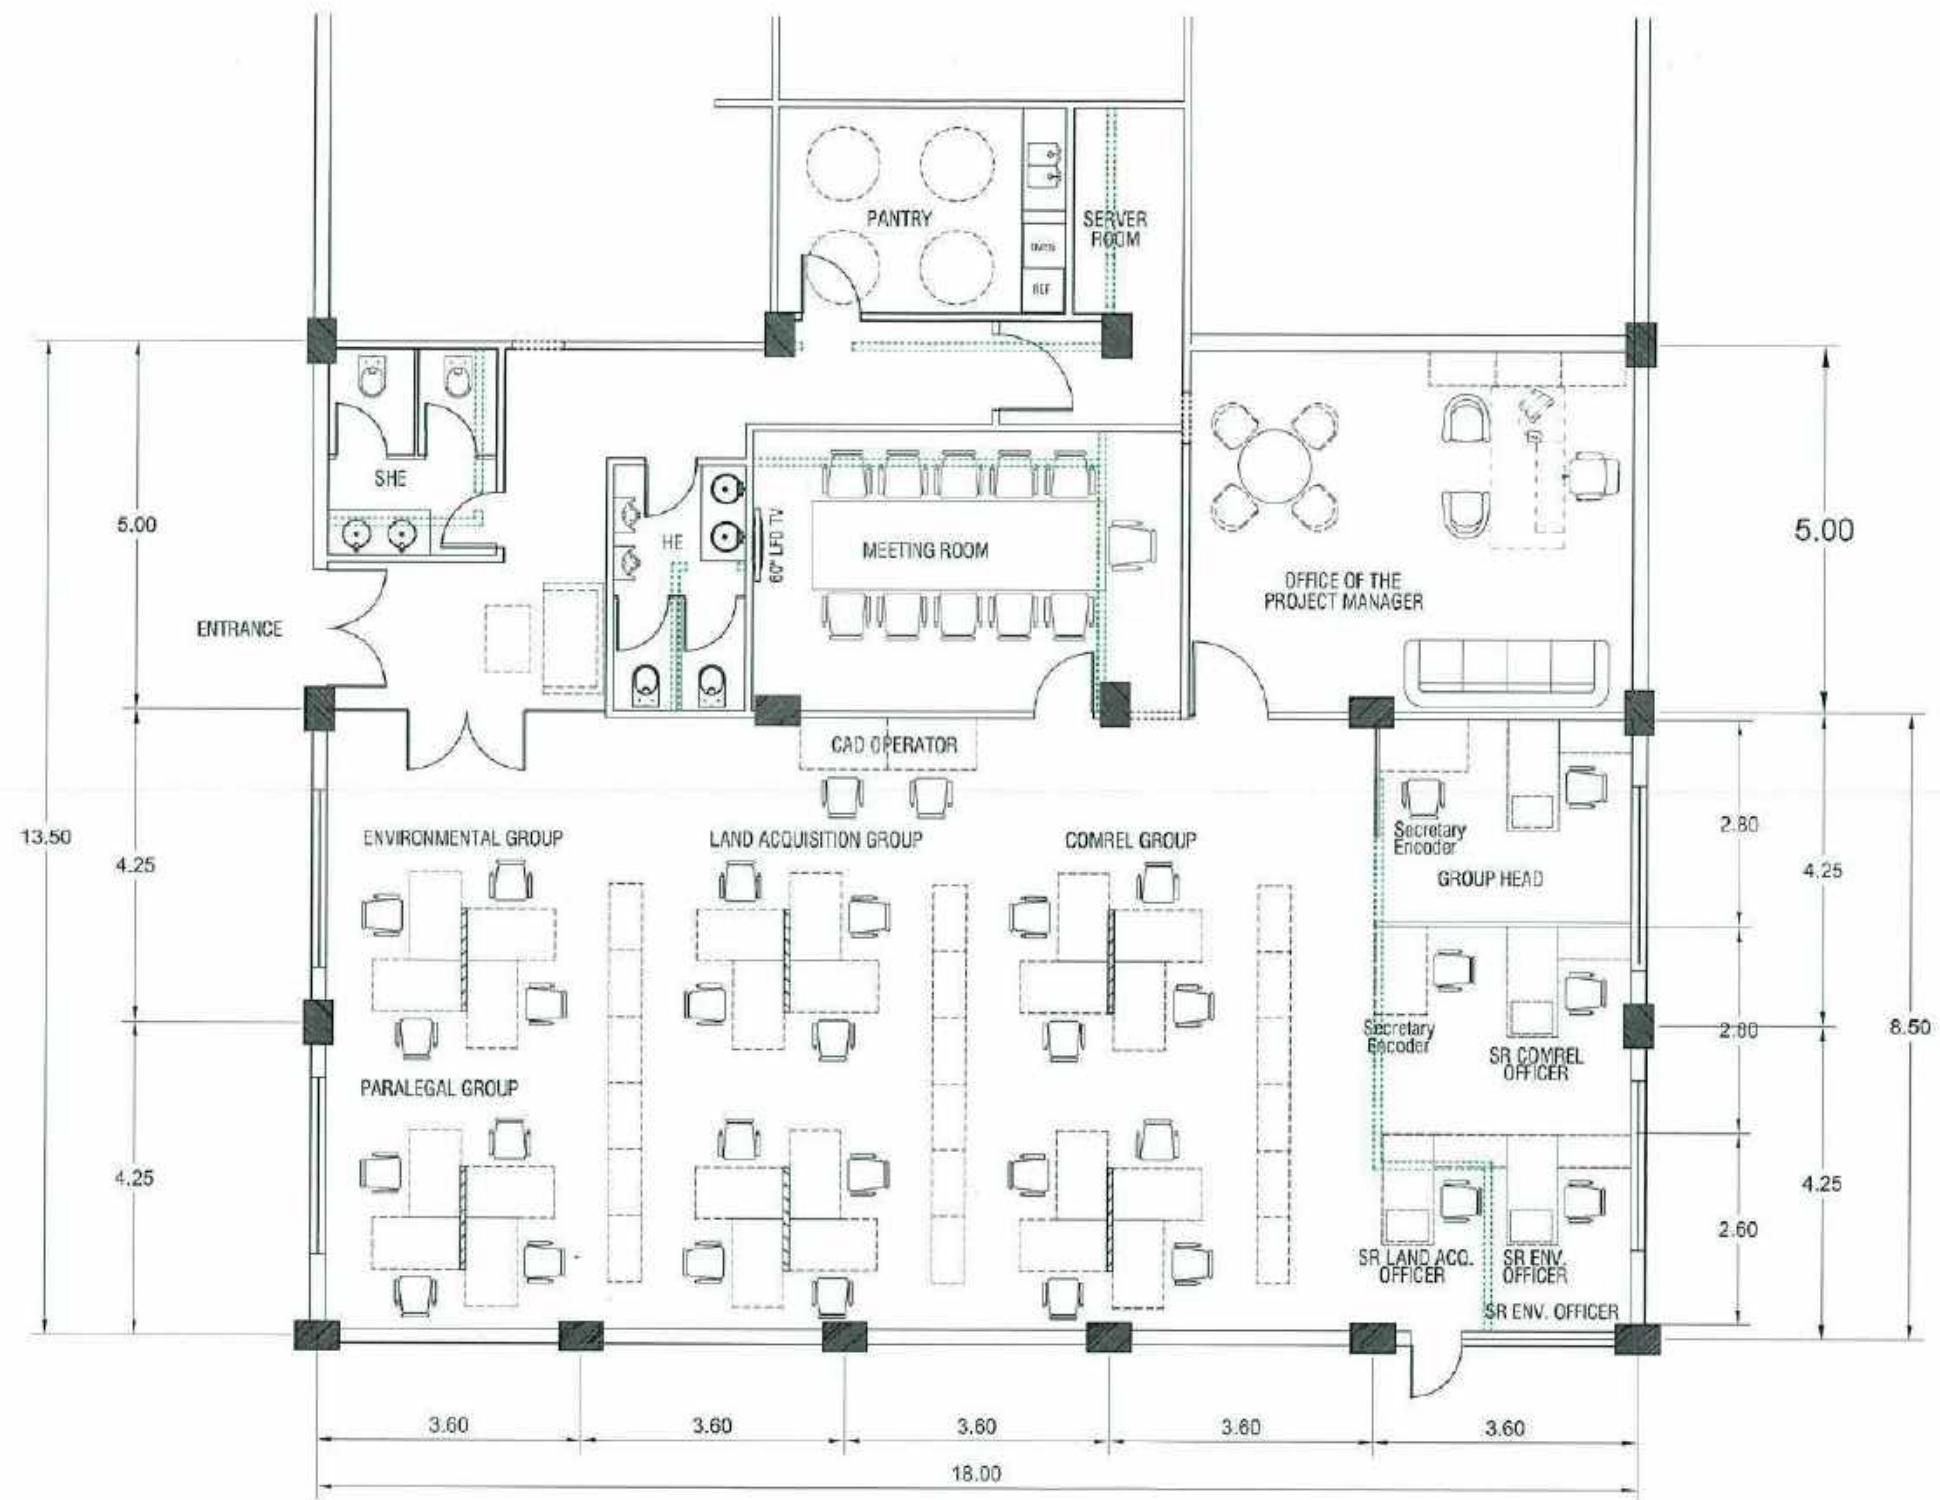

--- WALL TO BE DEMOLISHED



BCDA Bases Conversion and Development Authority	PROJECT NAME PROPOSED SCRIP OFFICE CLARK FREE PORT ZONE, PAMPANGA	PREPARED BY AR. JUDENE G. LAGOY ARCHITECT, MCC BMD AR. ALBERT G. REYES CAD OPERATOR, SCRIP	CHECKED & REVIEWED BY REY S. LIM PROJECT MANAGER, SCRIP	RECOMMENDING APPROVAL AILEEN ANUNCIACION R. ZOSA EXECUTIVE VICE PRESIDENT	APPROVED BY VIVENCIO B. DIZON PRESIDENT AND CEO	SHEET CONTENT GENERAL FLOOR PLAN	SHEET NO. A
	SCALE 1:100 M.	DATE: 06-02-2020	01				

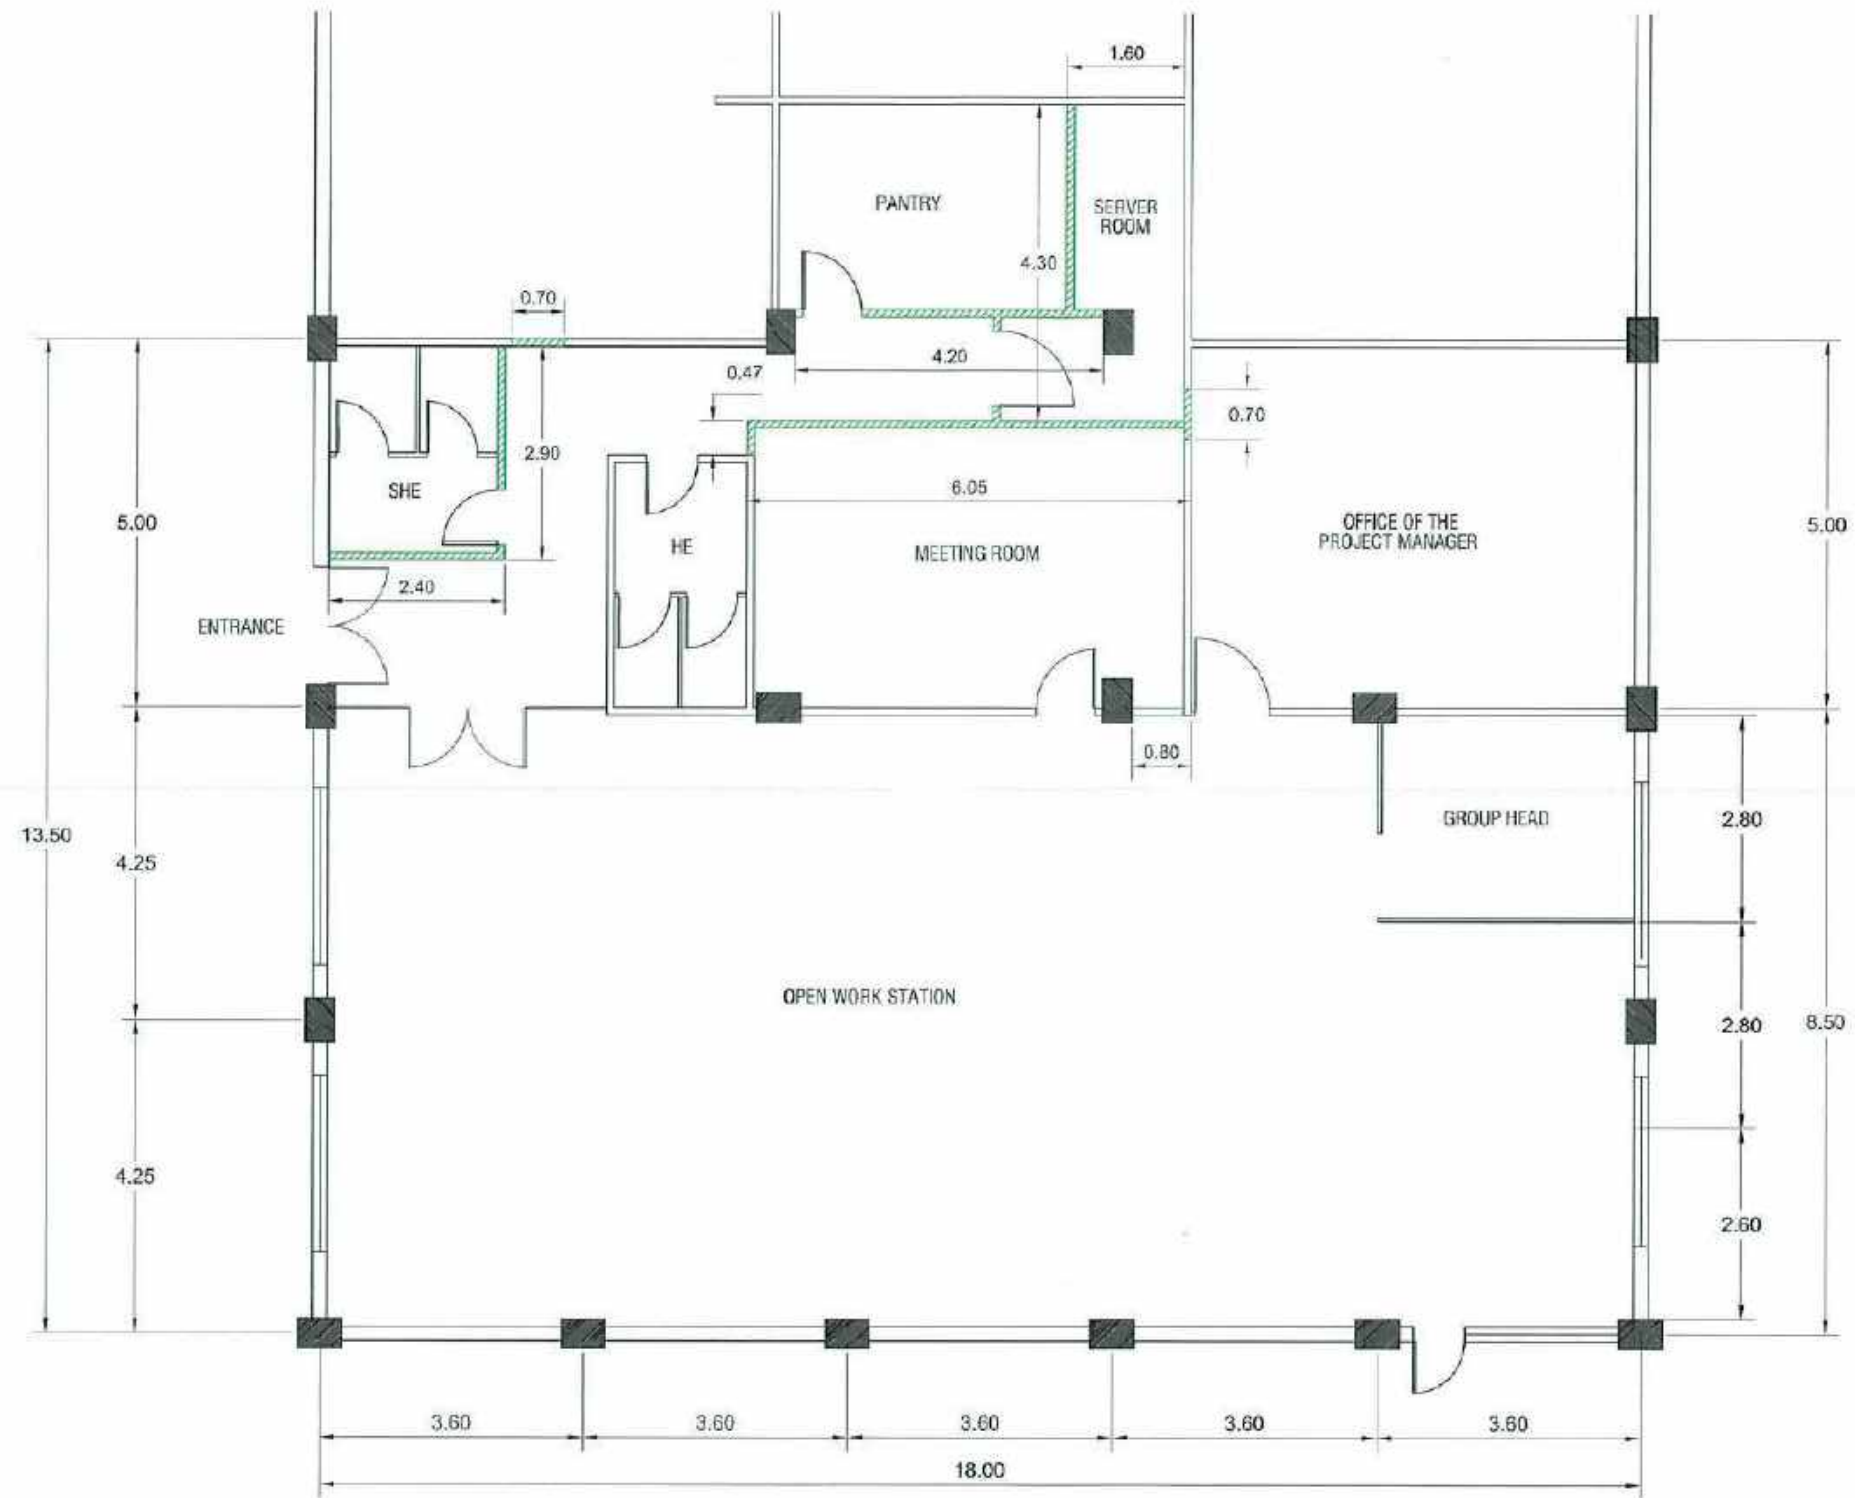

NOTE: 16mm THK FICEM BOARD WITH
INSULATION (1 HOUR Rating)
A=111.90 m²



PROJECT NAME
PROPOSED SCRP OFFICE
CLARK FREE PORT ZONE, PAMPANGA

PREPARED BY
AR. JUDENE G. LAGOY
ARCHITECT, NCCPMO
AR. ALBERT G. REYES
CIVIL OPERATOR, SCRP


CHECKED & REVIEWED BY
REV. S. LIM
PROJECT MANAGER, SCRP

RECOMMENDING APPROVAL
AILEEN ANUNCIACION R. ROSA
EXECUTIVE VICE PRESIDENT

APPROVED BY
VIVENCIO B. DIZON
PRESIDENT AND CEO

SHEET CONTENT
DRY WALL PARTITION PLAN
SCALE 1:100 M. DATE: 06-02-2020


SHEET NO.
A
02

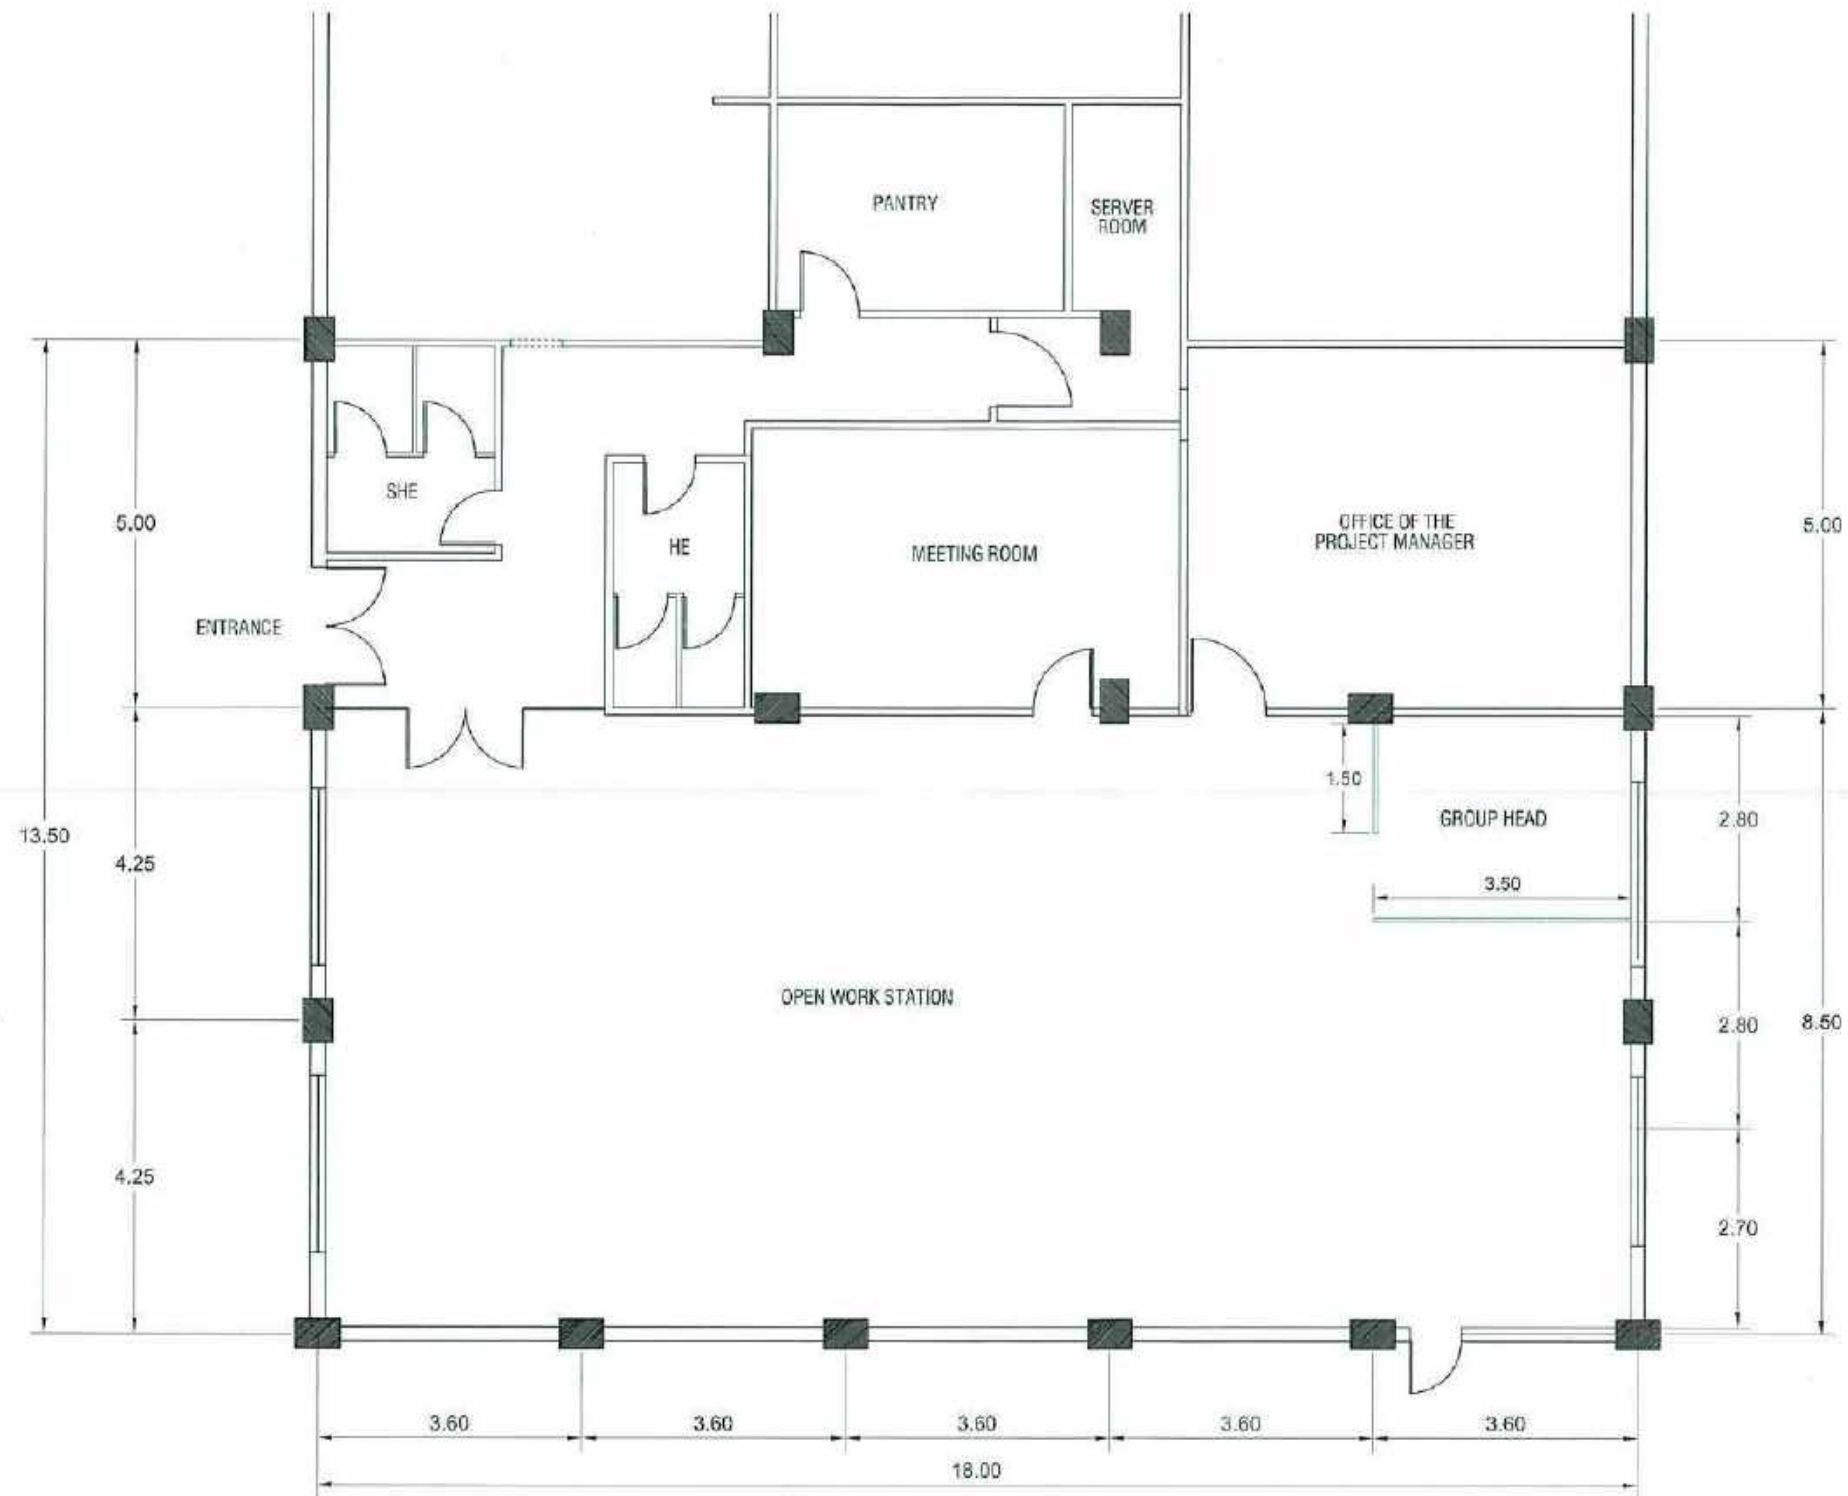

NOTE: FABRIC PARTITION w/ GLASS
 @ 180cm HEIGHT
 COLOR: OFF WHITE



PROJECT NAME	PREPARED BY	CHECKED & REVIEWED BY	RECOMMENDING APPROVAL	APPROVED BY	SHEET CONTENT	SHEET NO.
PROPOSED SCRP OFFICE CLARK FREE PORT ZONE, PAMPANGA	AR. JUDENE G. LAGOY ARCHITECT, NCC/PMO AR. ALBERTO C. REYES CAD OPERATOR, SCRP	REYES, ALM PROJECT MANAGER, SCRP	AILEEN ANUNCIACION R. ZOSA EXECUTIVE VICE PRESIDENT	VIVENCIO B. DIZON PRESIDENT AND CEO	LOW PANEL PARTITION PLAN SCALE 1:100 M. DATE: 08-02-2020	A 03

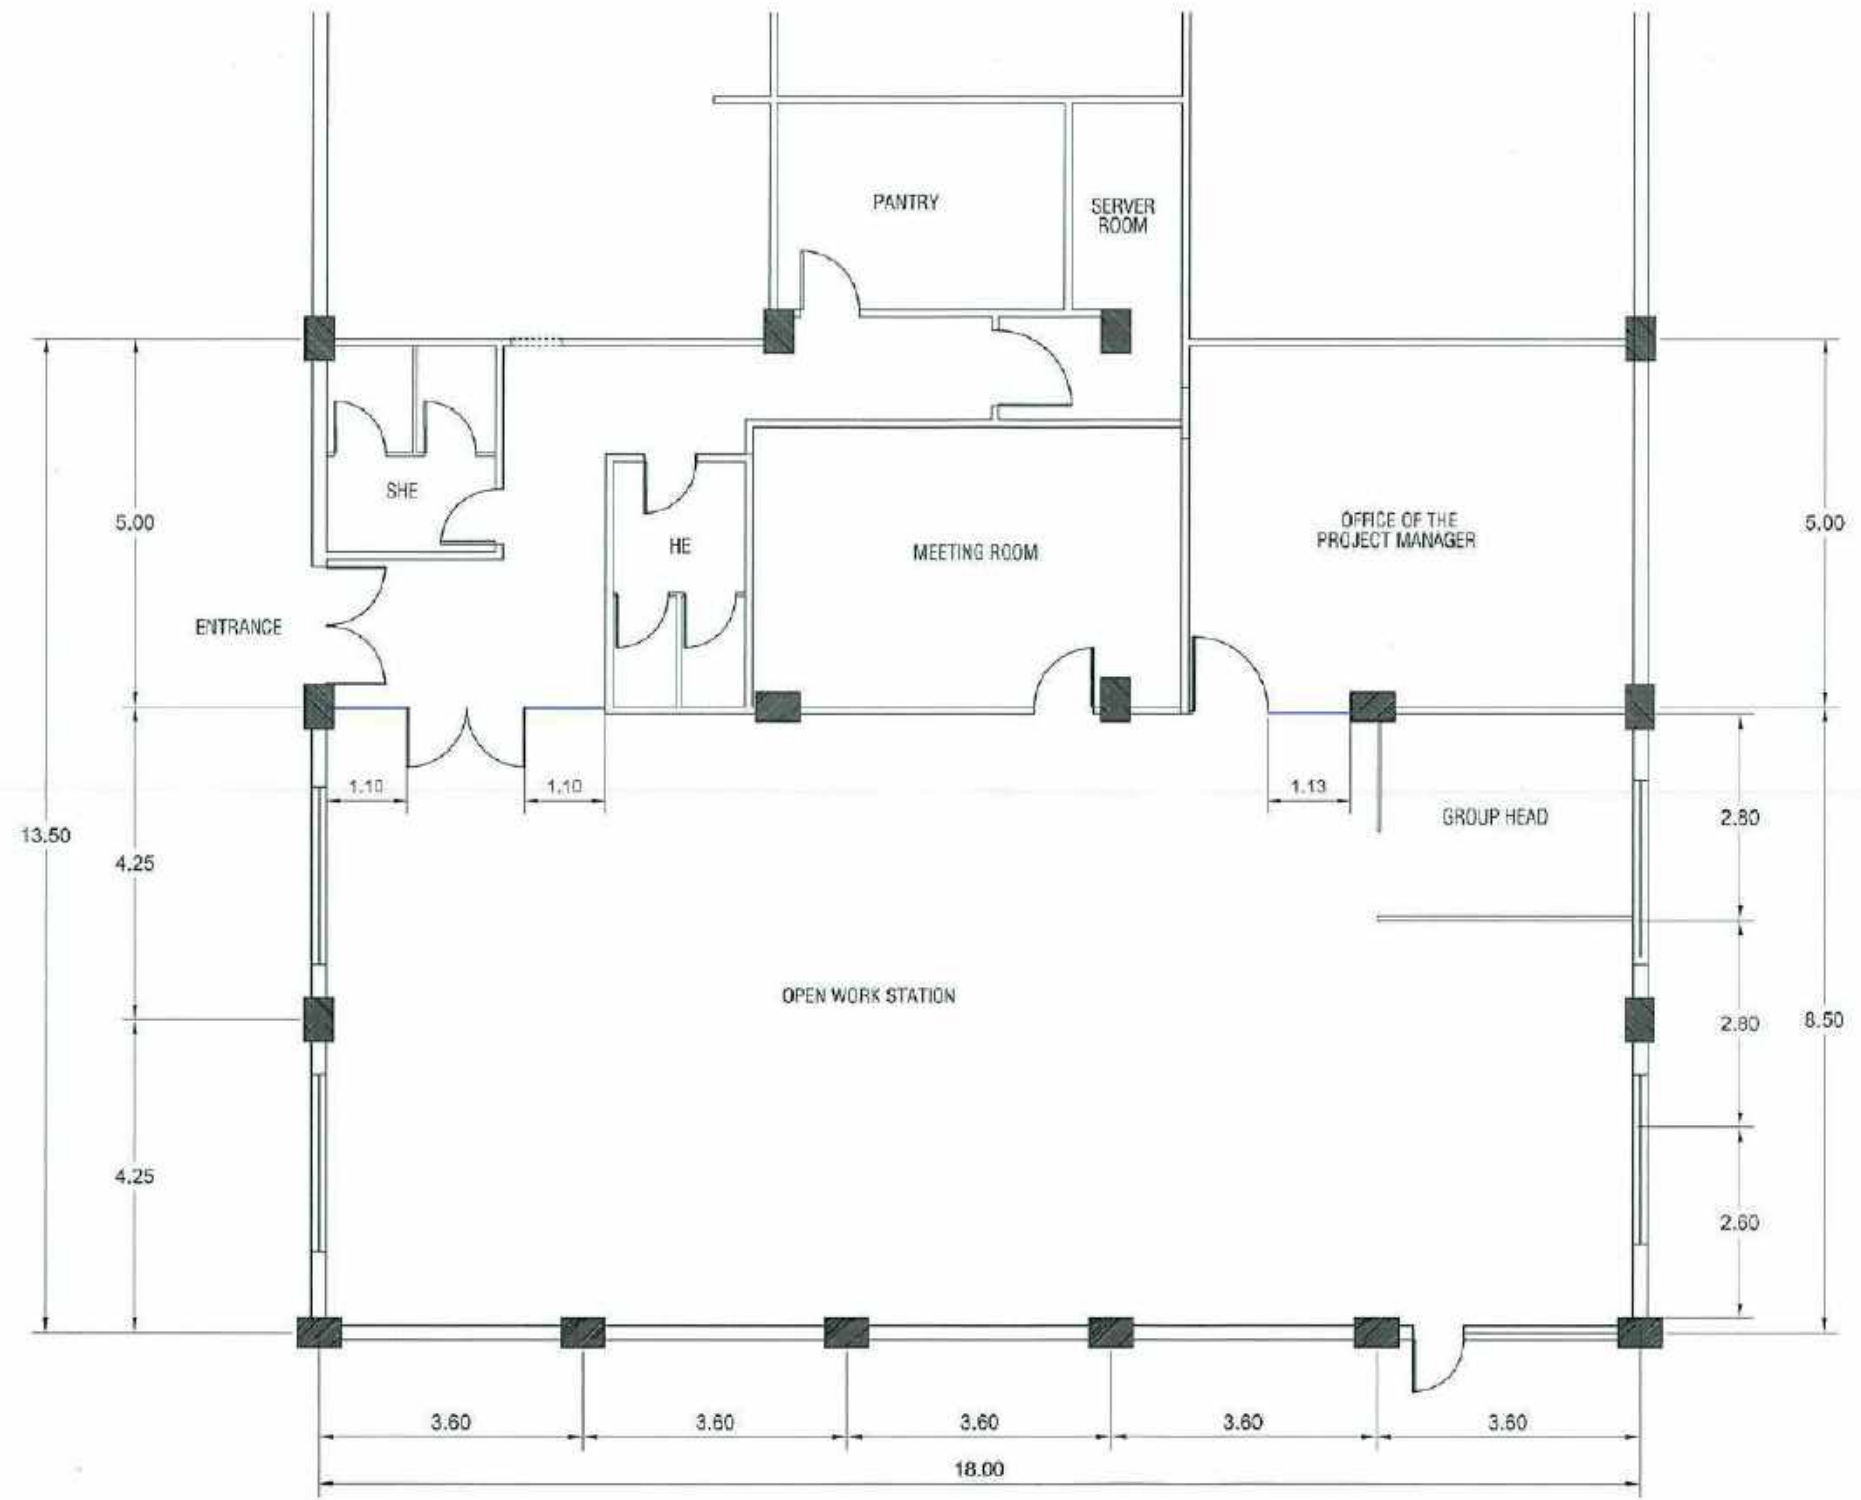

NOTE: 12mm THK. TEMPERED GLASS
ON FD100 TOP & BOTTOM FRAME



PROJECT NAME
PROPOSED SCRP OFFICE
CLARK FREE PORT ZONE, PAMPANGA

PREPARED BY
AR. JUDENE G. LAGOY ARCHITECT, NCD PMO
AR. ALBERT G. REYES CAD OPERATOR, SCRP

CHECKED & REVIEWED BY
REV/S LIM PROJECT MANAGER, SCRP


RECOMMENDING APPROVAL
AILEEN ANUNCIACION R. ZOSA EXECUTIVE VICE PRESIDENT

APPROVED BY
VIVENCIO B. DIZON PRESIDENT AND CEO

SHEET CONTENT
GLASS PARTITION PLAN
SCALE 1:100 M. DATE: 05-02-2020

SHEET NO.
A
04

30CM X 30CM HOMOGENOUS POLISHED AND UNPOLISHED FLOOR & WALL TILES.

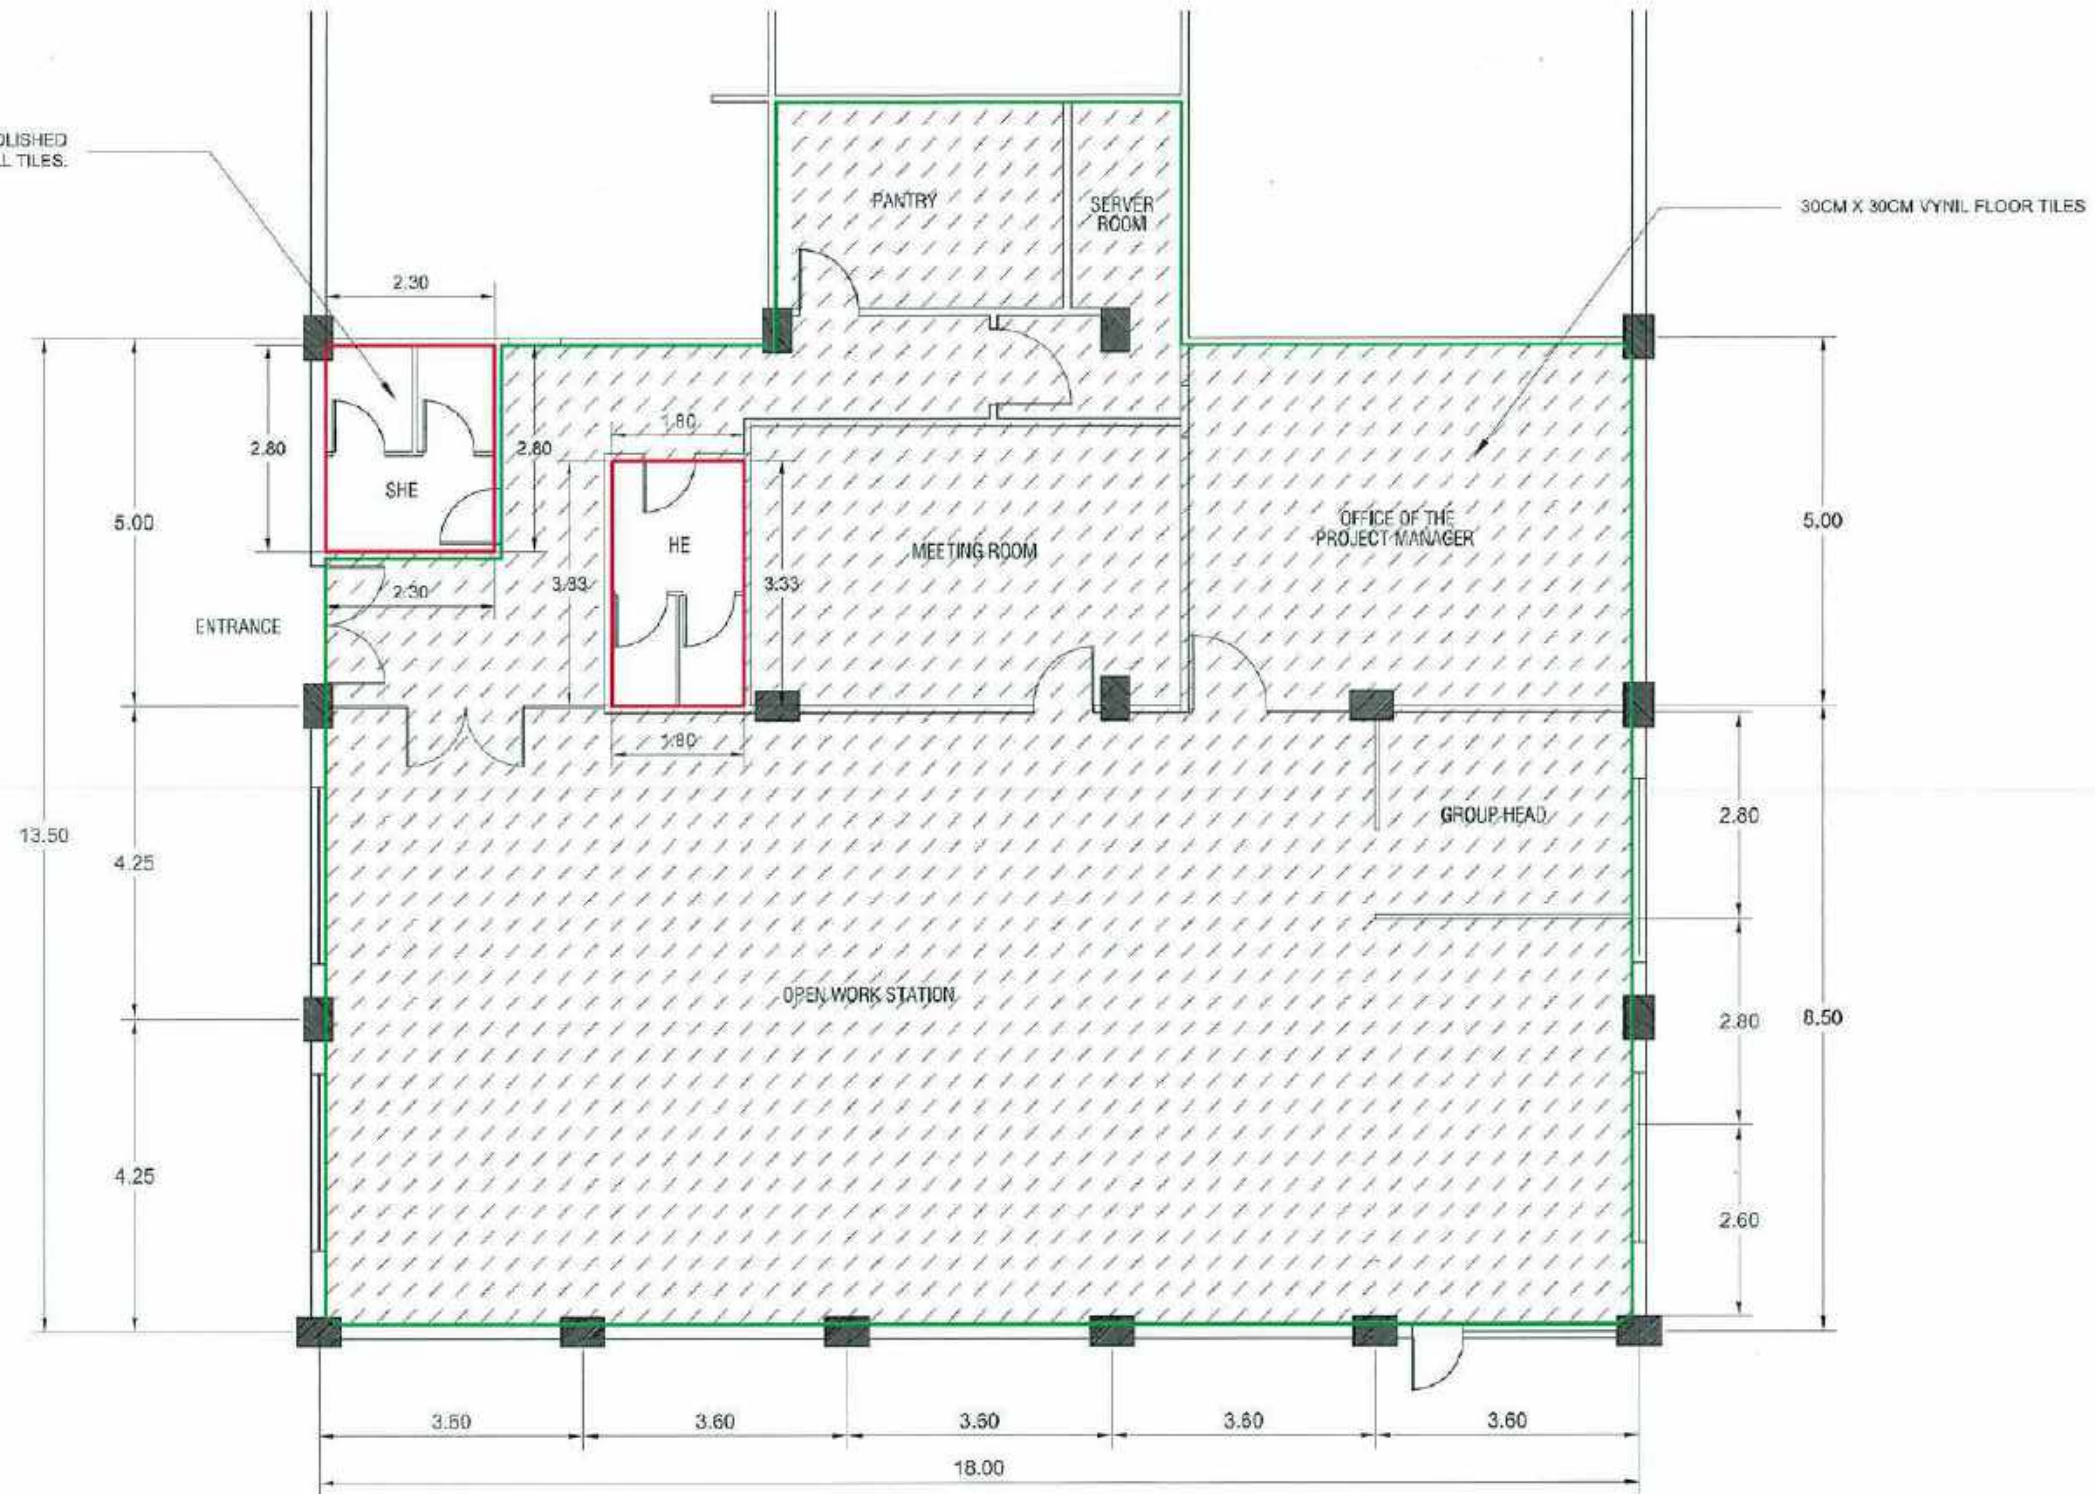



NOTE: TOILET
 30CM X 30CM FLOOR TILES (12.42 M2)
 30CM X 30CM WALL TILES (49.44 M2)

NOTE: WORKING AREA
 30CM X 30CM FLOOR TILES (235 M2)





PROJECT NAME	PREPARED BY	CHECKED & REVIEWED BY	RECOMMENDING APPROVAL	APPROVED BY	SHEET CONTENT	SHEET NO.
PROPOSED SCRP OFFICE CLARK FREE PORT ZONE, PAMPANGA	AR. JUDENE G. LAGOY ARCHITECT/LEAD PMO AR. ALBERT G. REYES CAD OPERATOR, SCRP	REY & LIM PROJECT MANAGER SCRP	AILEEN ANUNCIACION R. ZORBA EXECUTIVE VICE PRESIDENT	VIVENCIO B. DIZON PRESIDENT AND CEO	CERAMIC TILES @ TOILET VYNIL TILES @ WORKING AREA SCALE 1:100 M. DATE: 06-02-2020	A 05

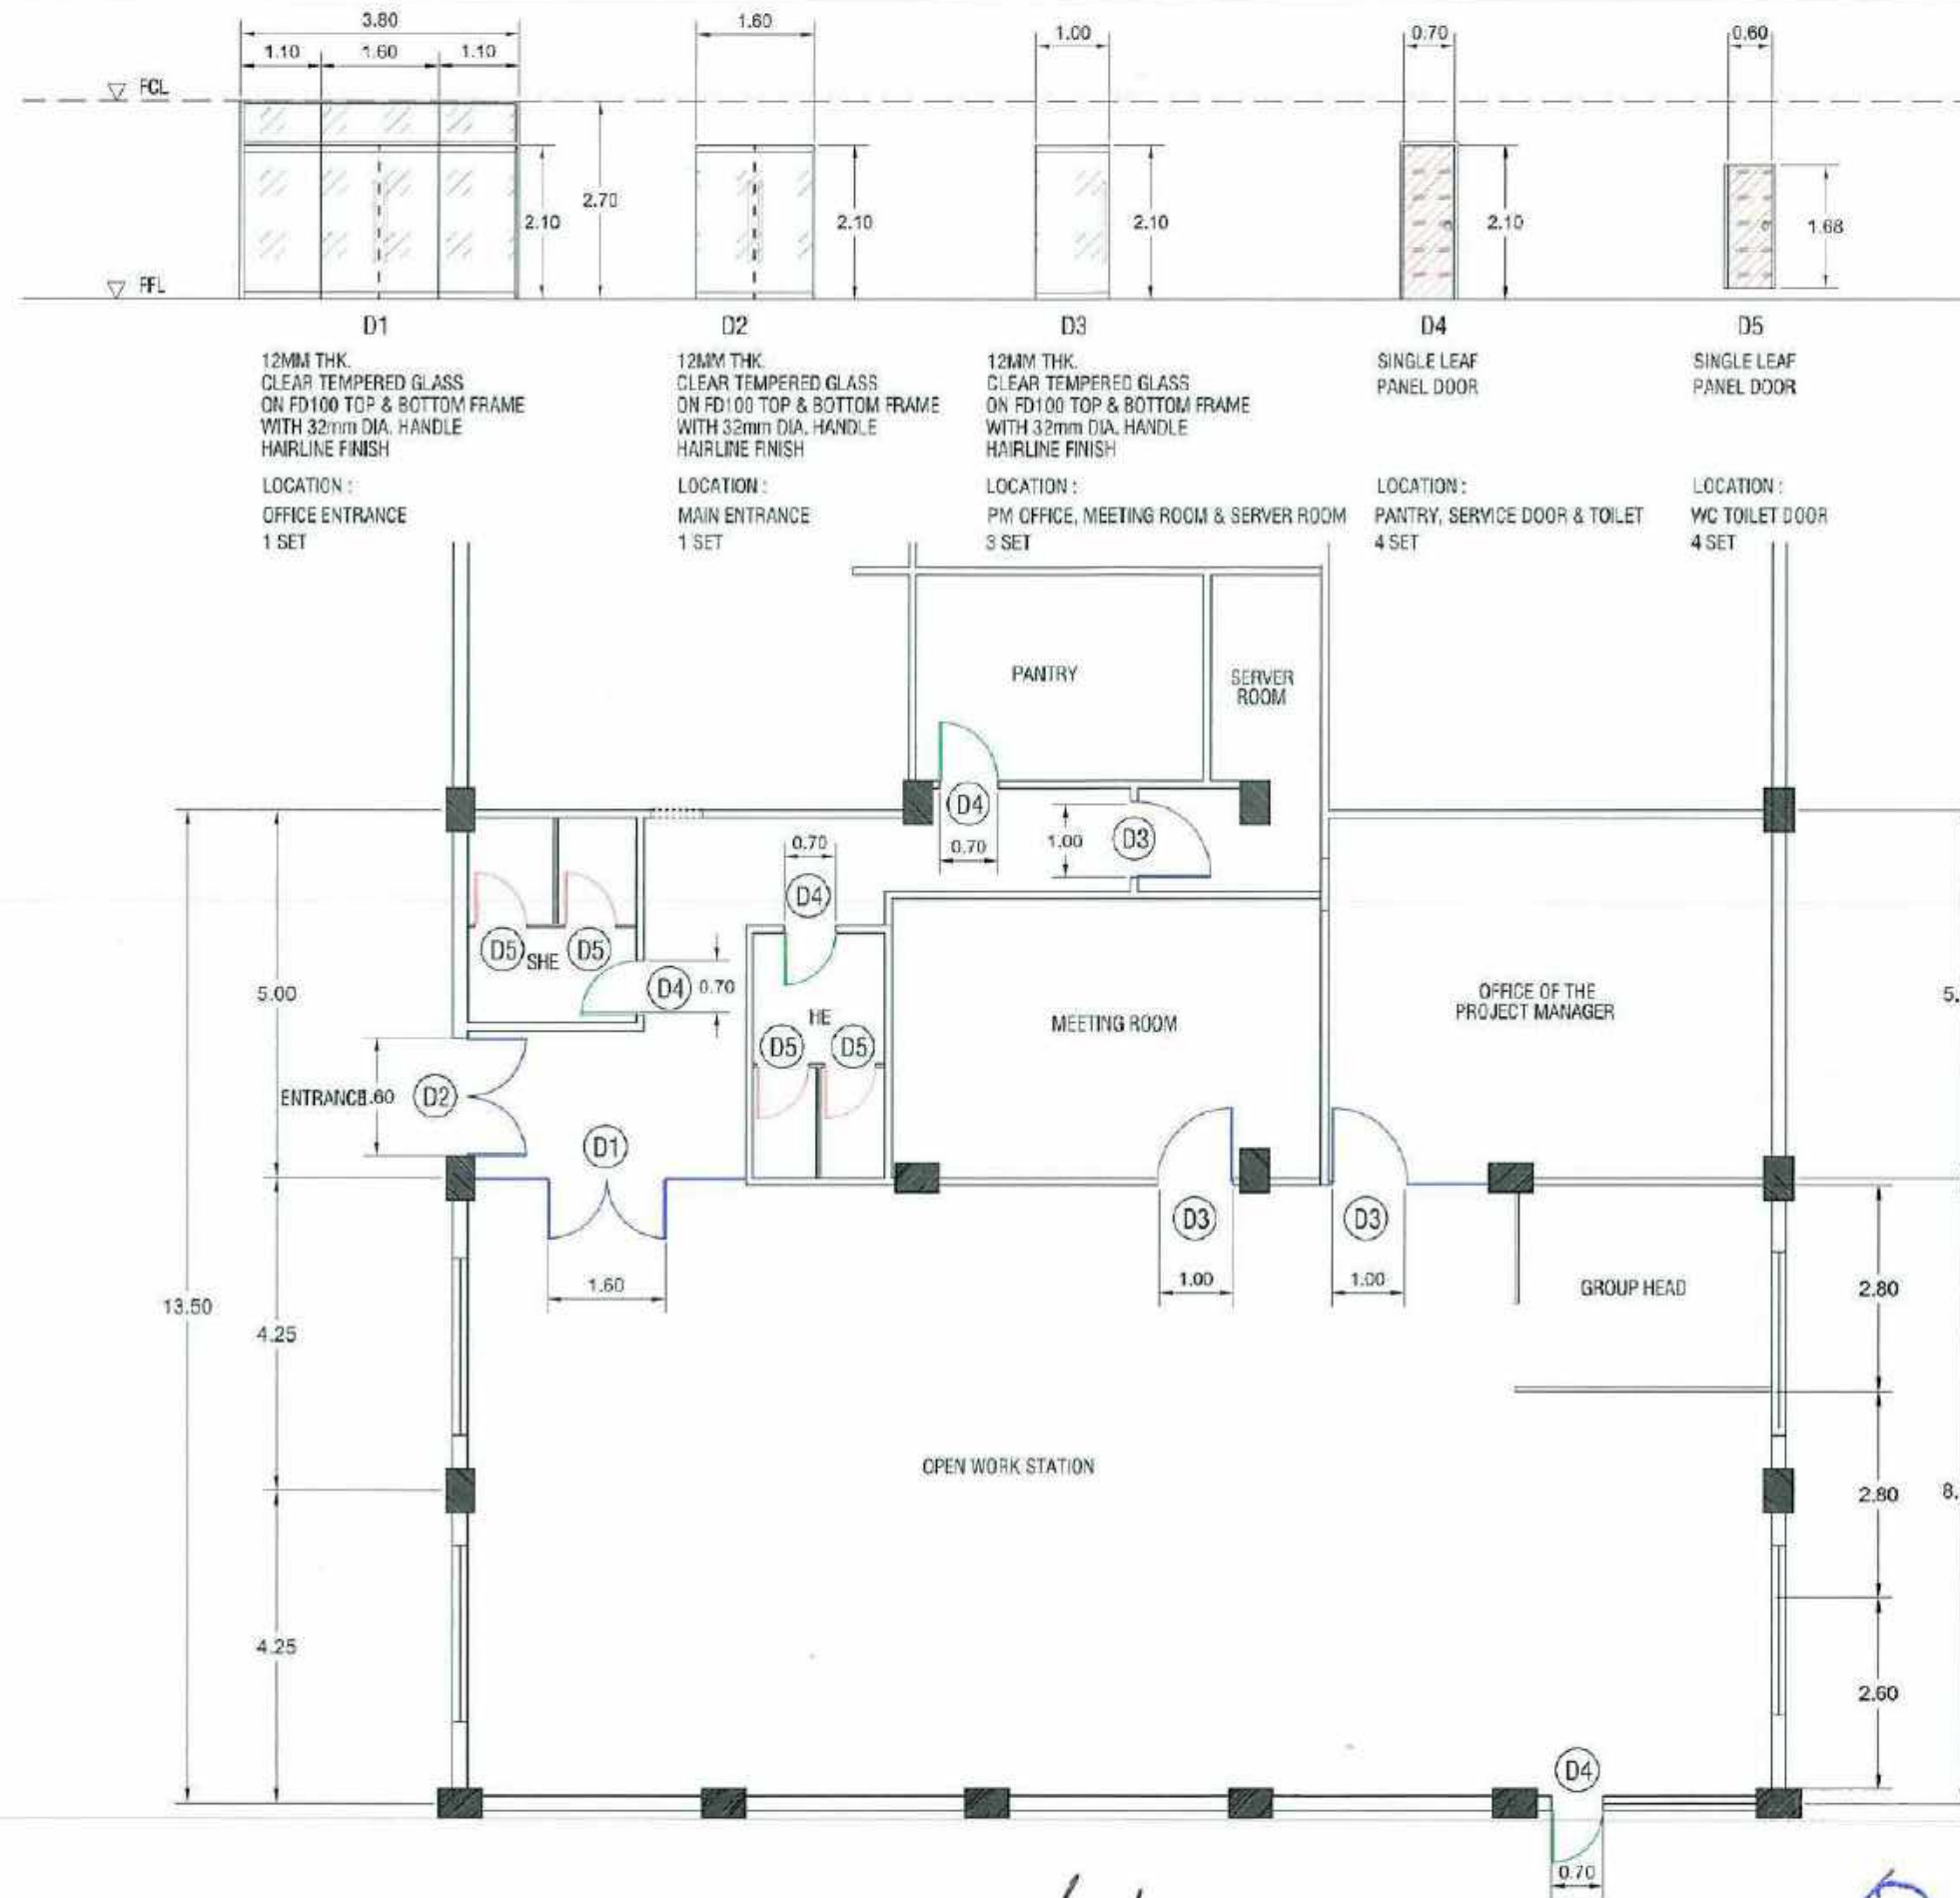

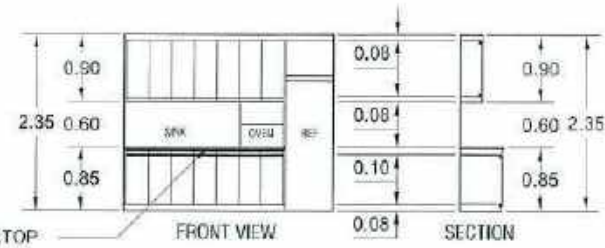

KITCHEN CABINET DETAIL

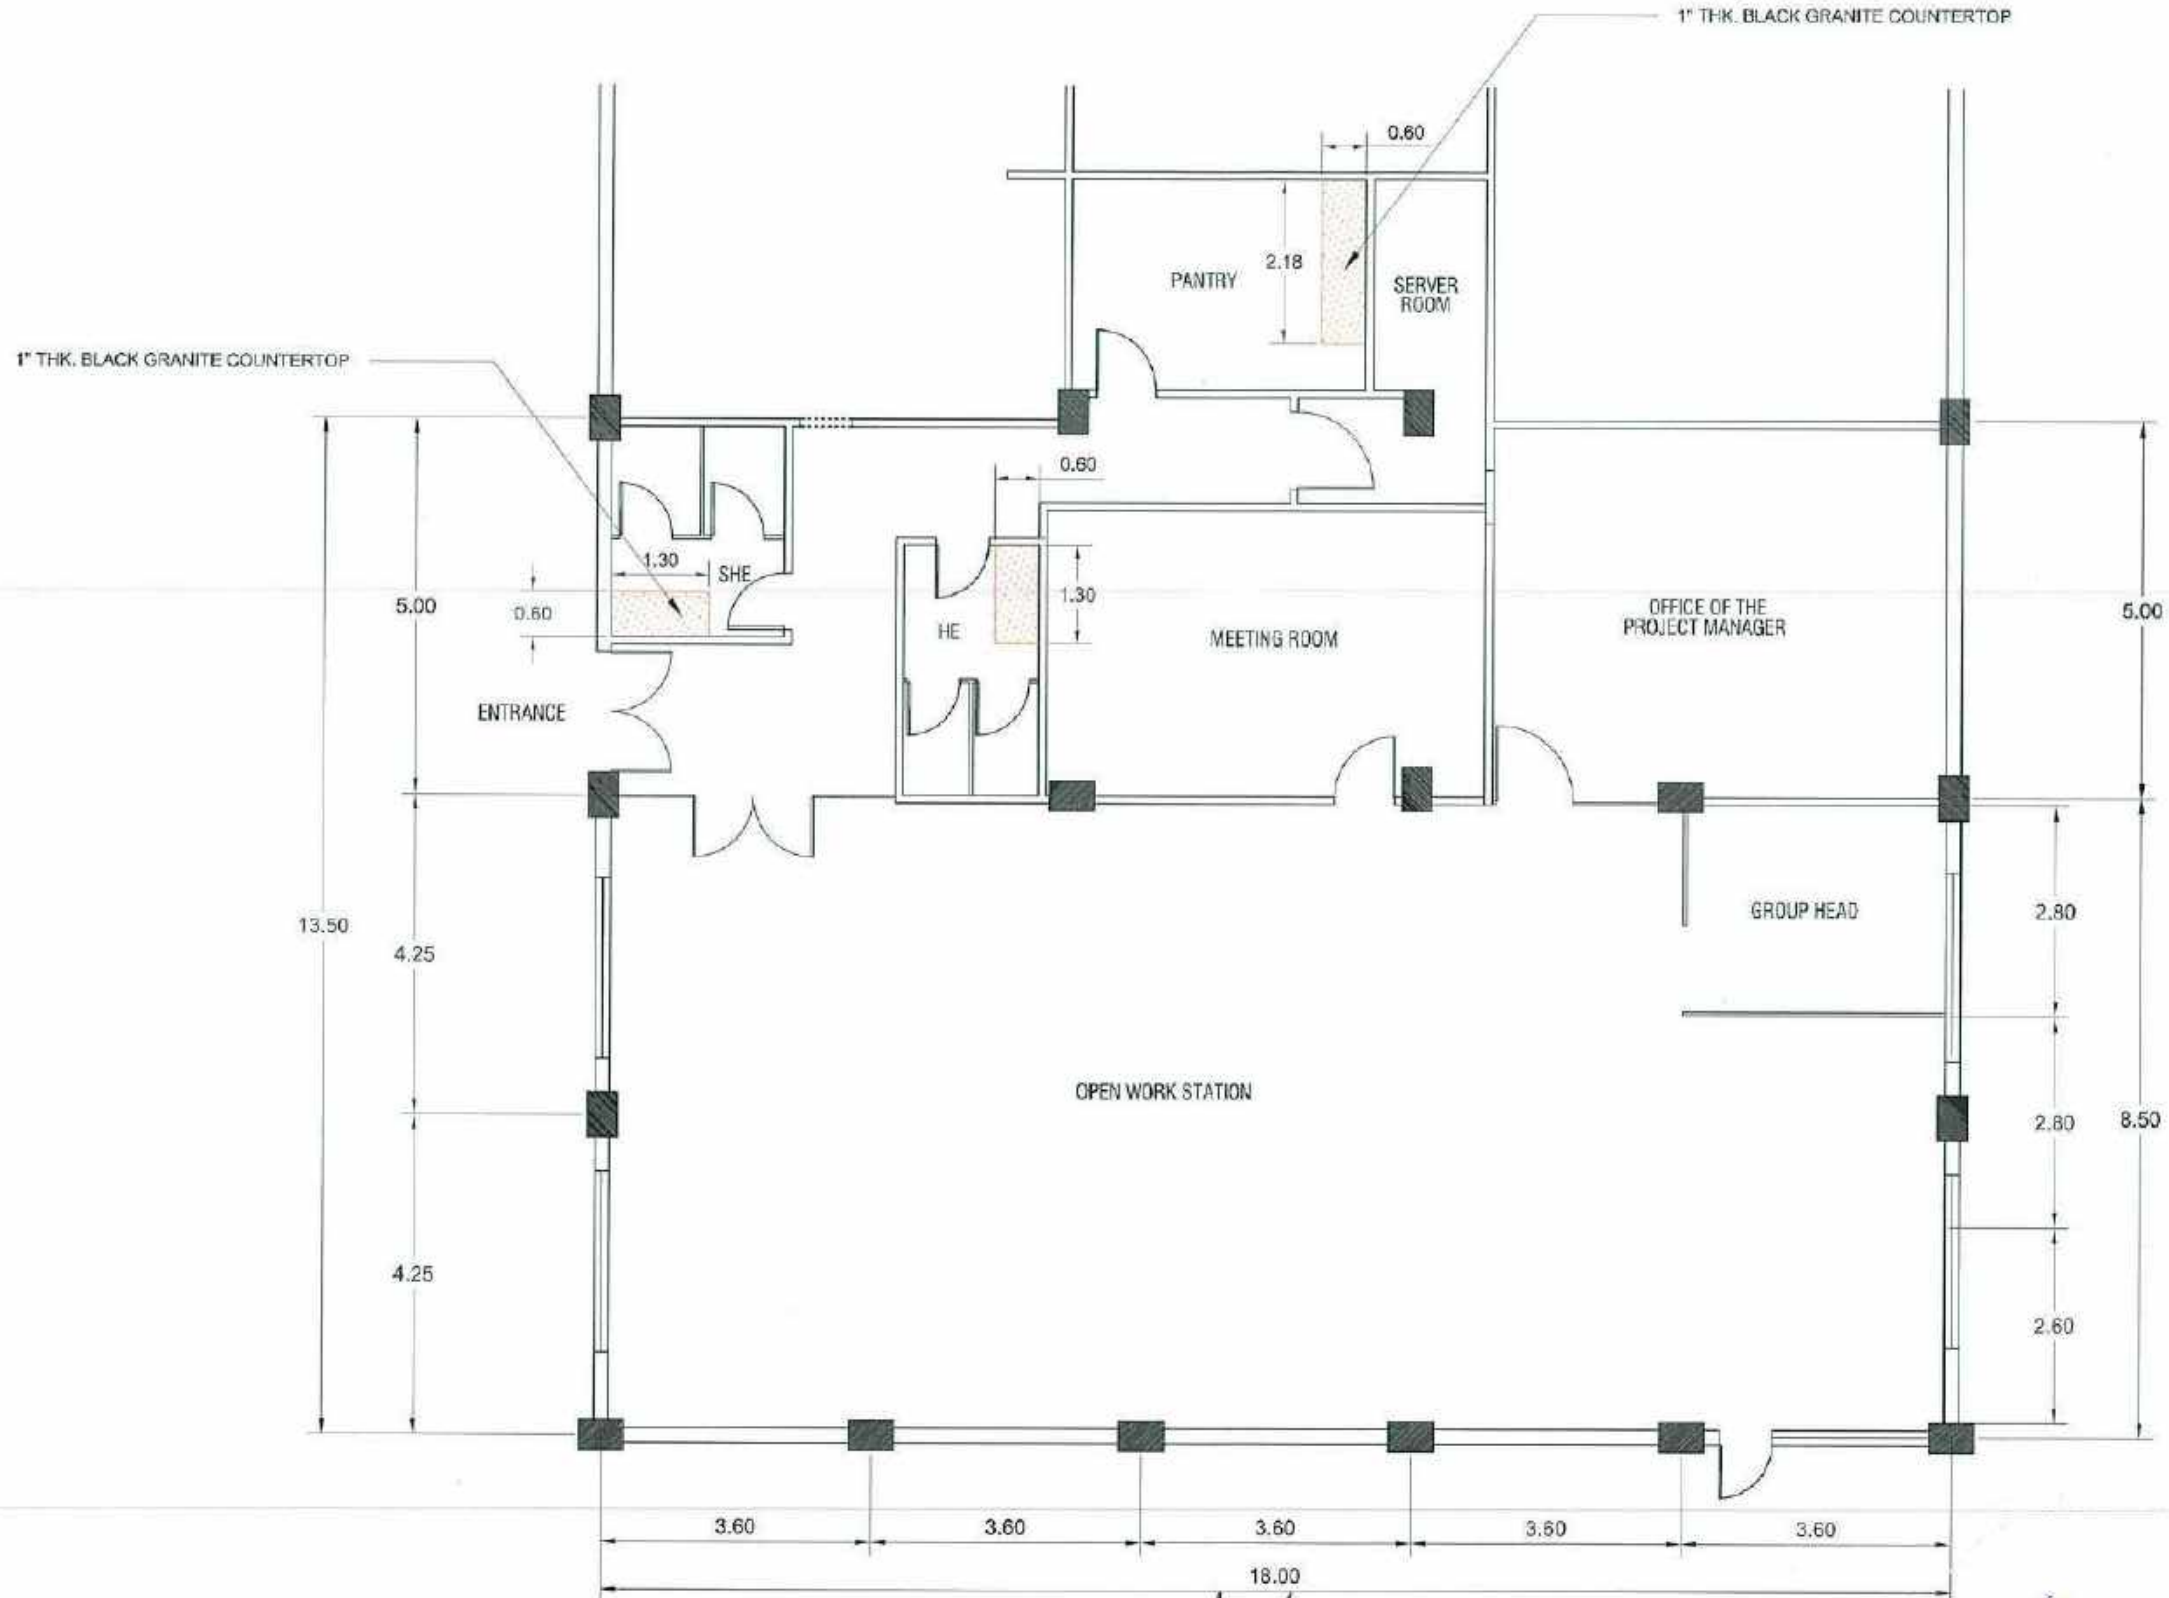

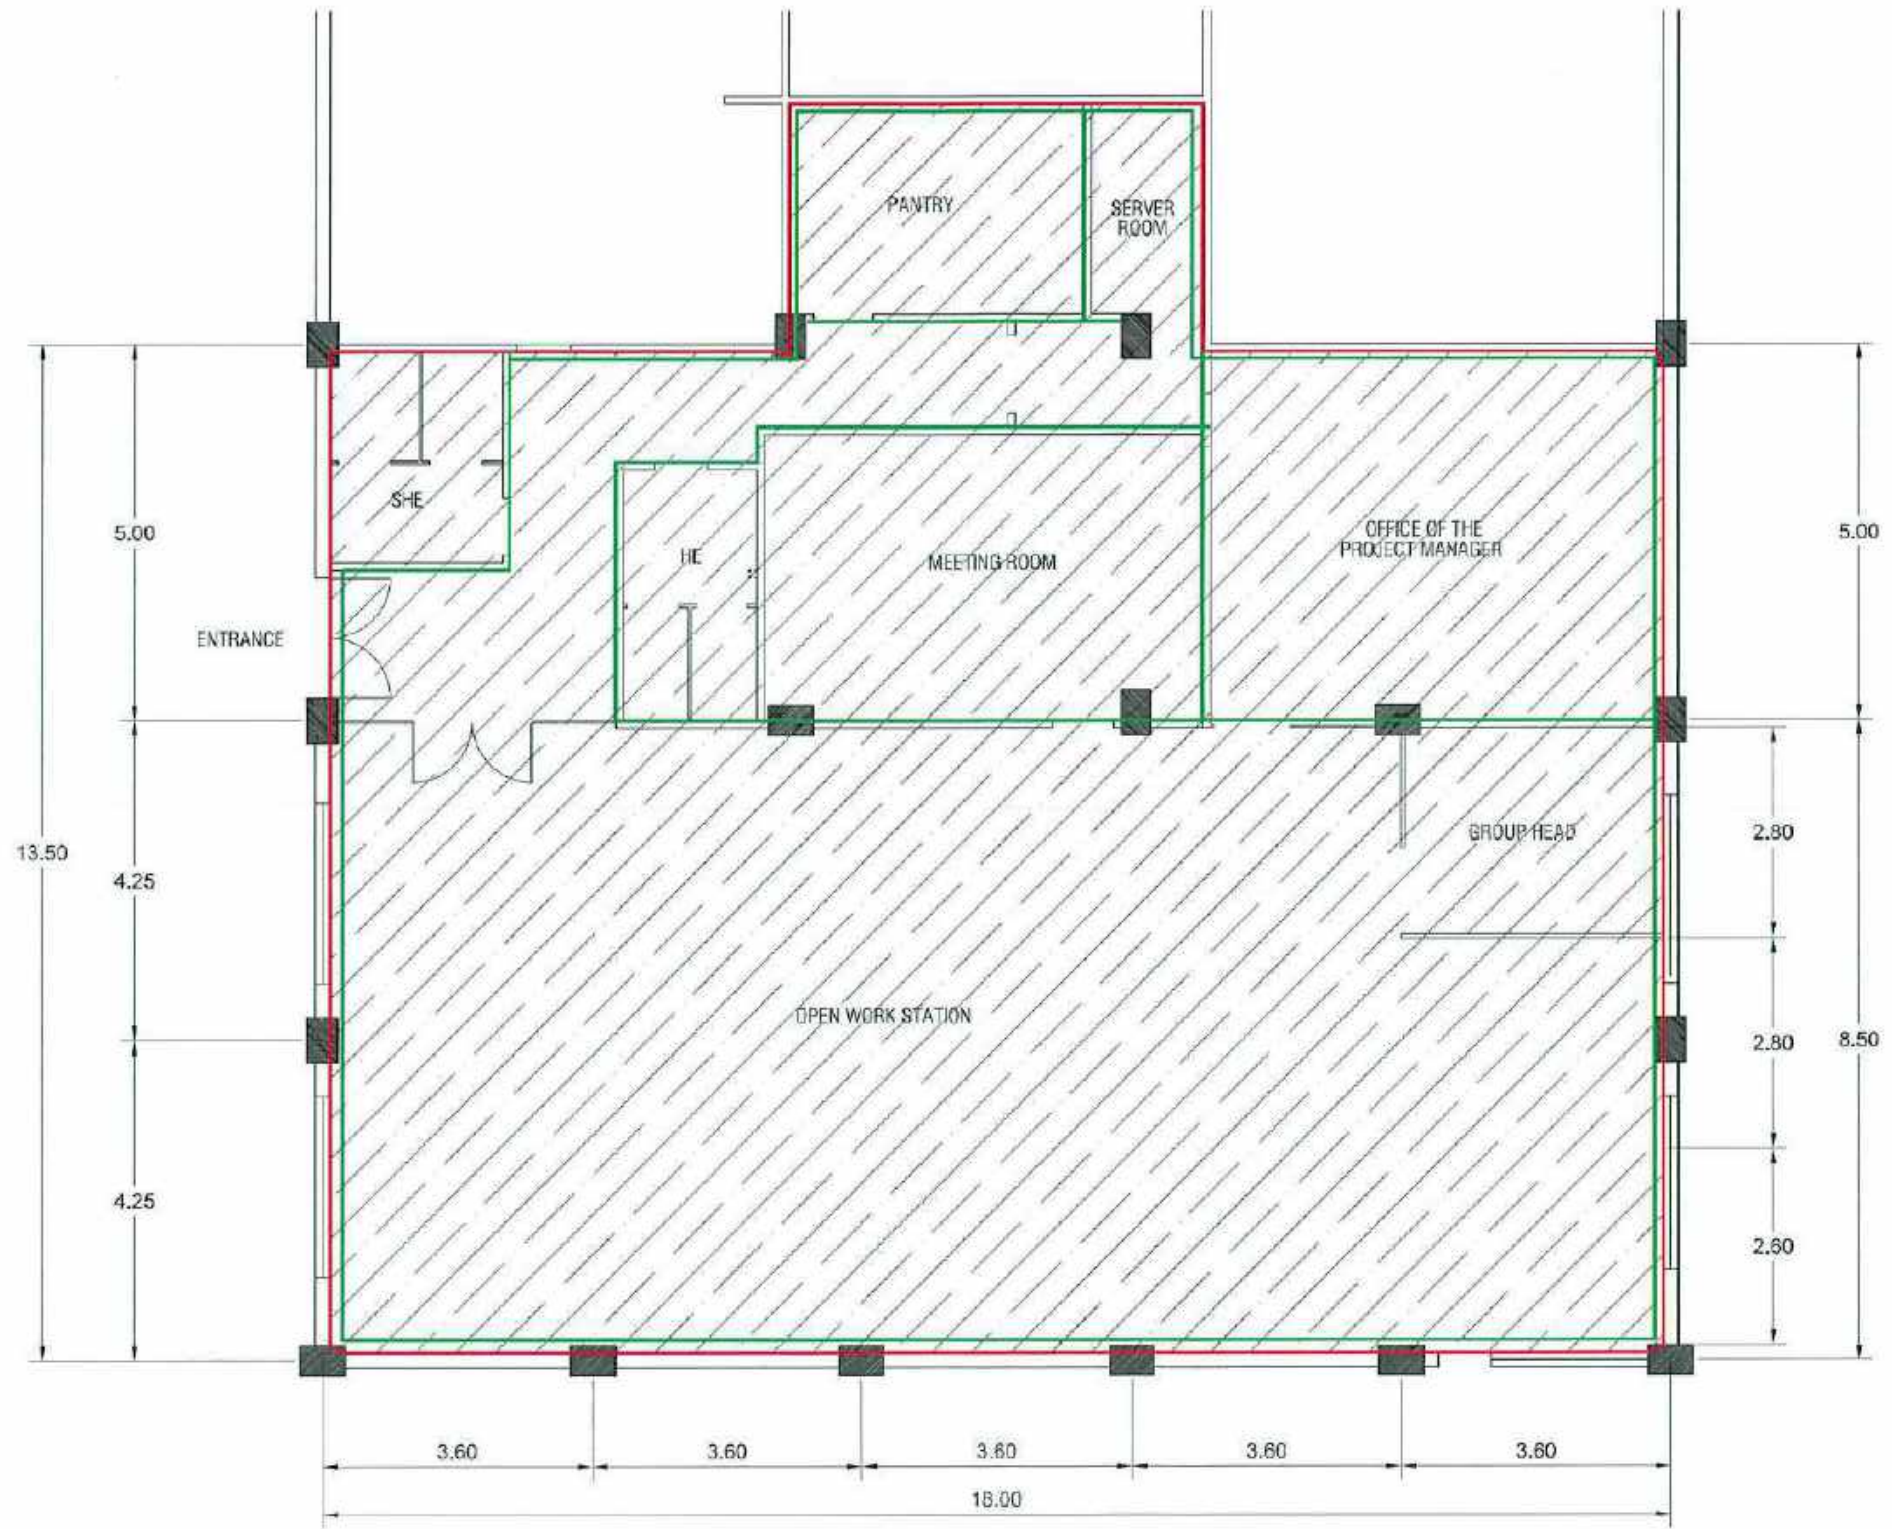

NOTE: PAINTING WORKS

CEILING - 254 m²

WALL - 111.90 m²



PROJECT NAME
PROPOSED SCRIP OFFICE
CLARK FREE PORT ZONE, PAMPANGA

PREPARED BY
AR. JUDENE G. LAGOY
ARCHITECT, INC. PMD
AR. ALBERT S. REYES
CAD OPERATOR, SCRIP


CHECKED & REVIEWED BY
REY S. LIM
PROJECT MANAGER, SCRIP

RECOMMENDING APPROVAL
AILEEN ANUNCIACION R. ZOSA
EXECUTIVE VICE PRESIDENT

APPROVED BY
VIVENCIO B. DIZON
PRESIDENT AND CEO

SHEET CONTENT
PAINTING WORKS PLAN
SCALE 1:100 M. DATE: 06-02-2020


SHEET NO.
A
08

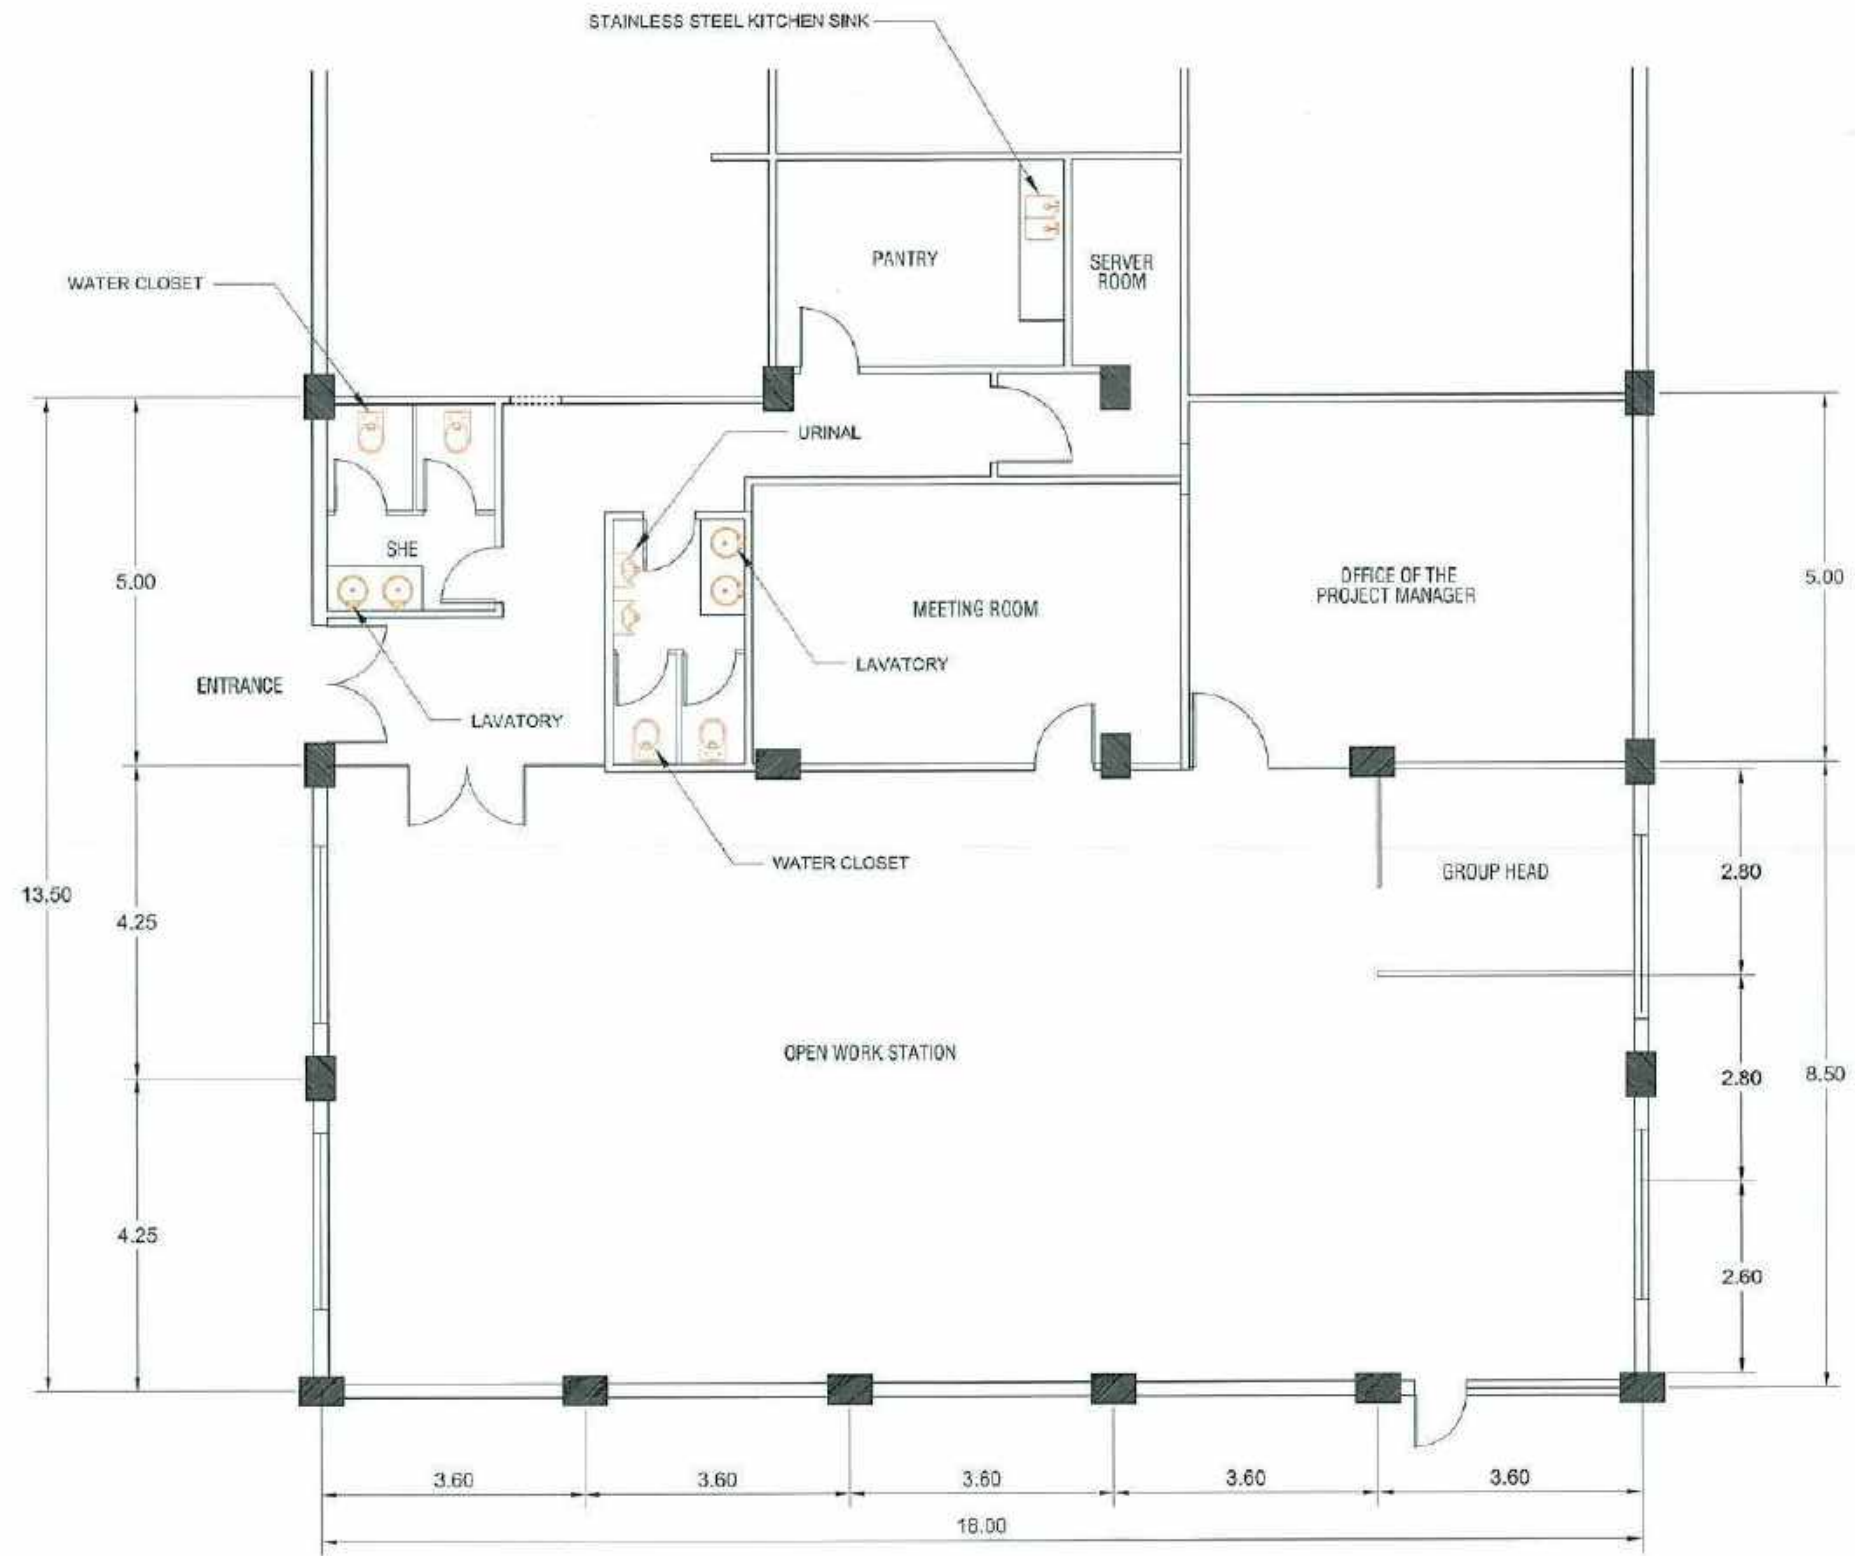

NOTE: 4 SET WATER CLOSET
 4 SET LAVATORY
 2 SET URINAL
 1 SET KITCHEN SINK (DOUBLE)






PROJECT NAME	PREPARED BY	CHECKED & REVIEWED BY	RECOMMENDING APPROVAL	APPROVED BY	SHEET CONTENT	SHEET NO.
PROPOSED SCRP OFFICE CLARK FREE PORT ZONE, PAMPANGA	AR. JUDENE G. LAGOY ARCHITECT, NCO-PMO AR. ALBERTO REYES CAD OPERATOR, SCRP	REY B. LIM PROJECT MANAGER, SCRP	AILEEN ANUNCIACION R. ZOSA EXECUTIVE VICE PRESIDENT	VIVENCIO B. DIZON PRESIDENT AND CEO	PLUMBING FIXTURES PLAN SCALE: 1 : 100 M. DATE: 06-02-2020	A 09

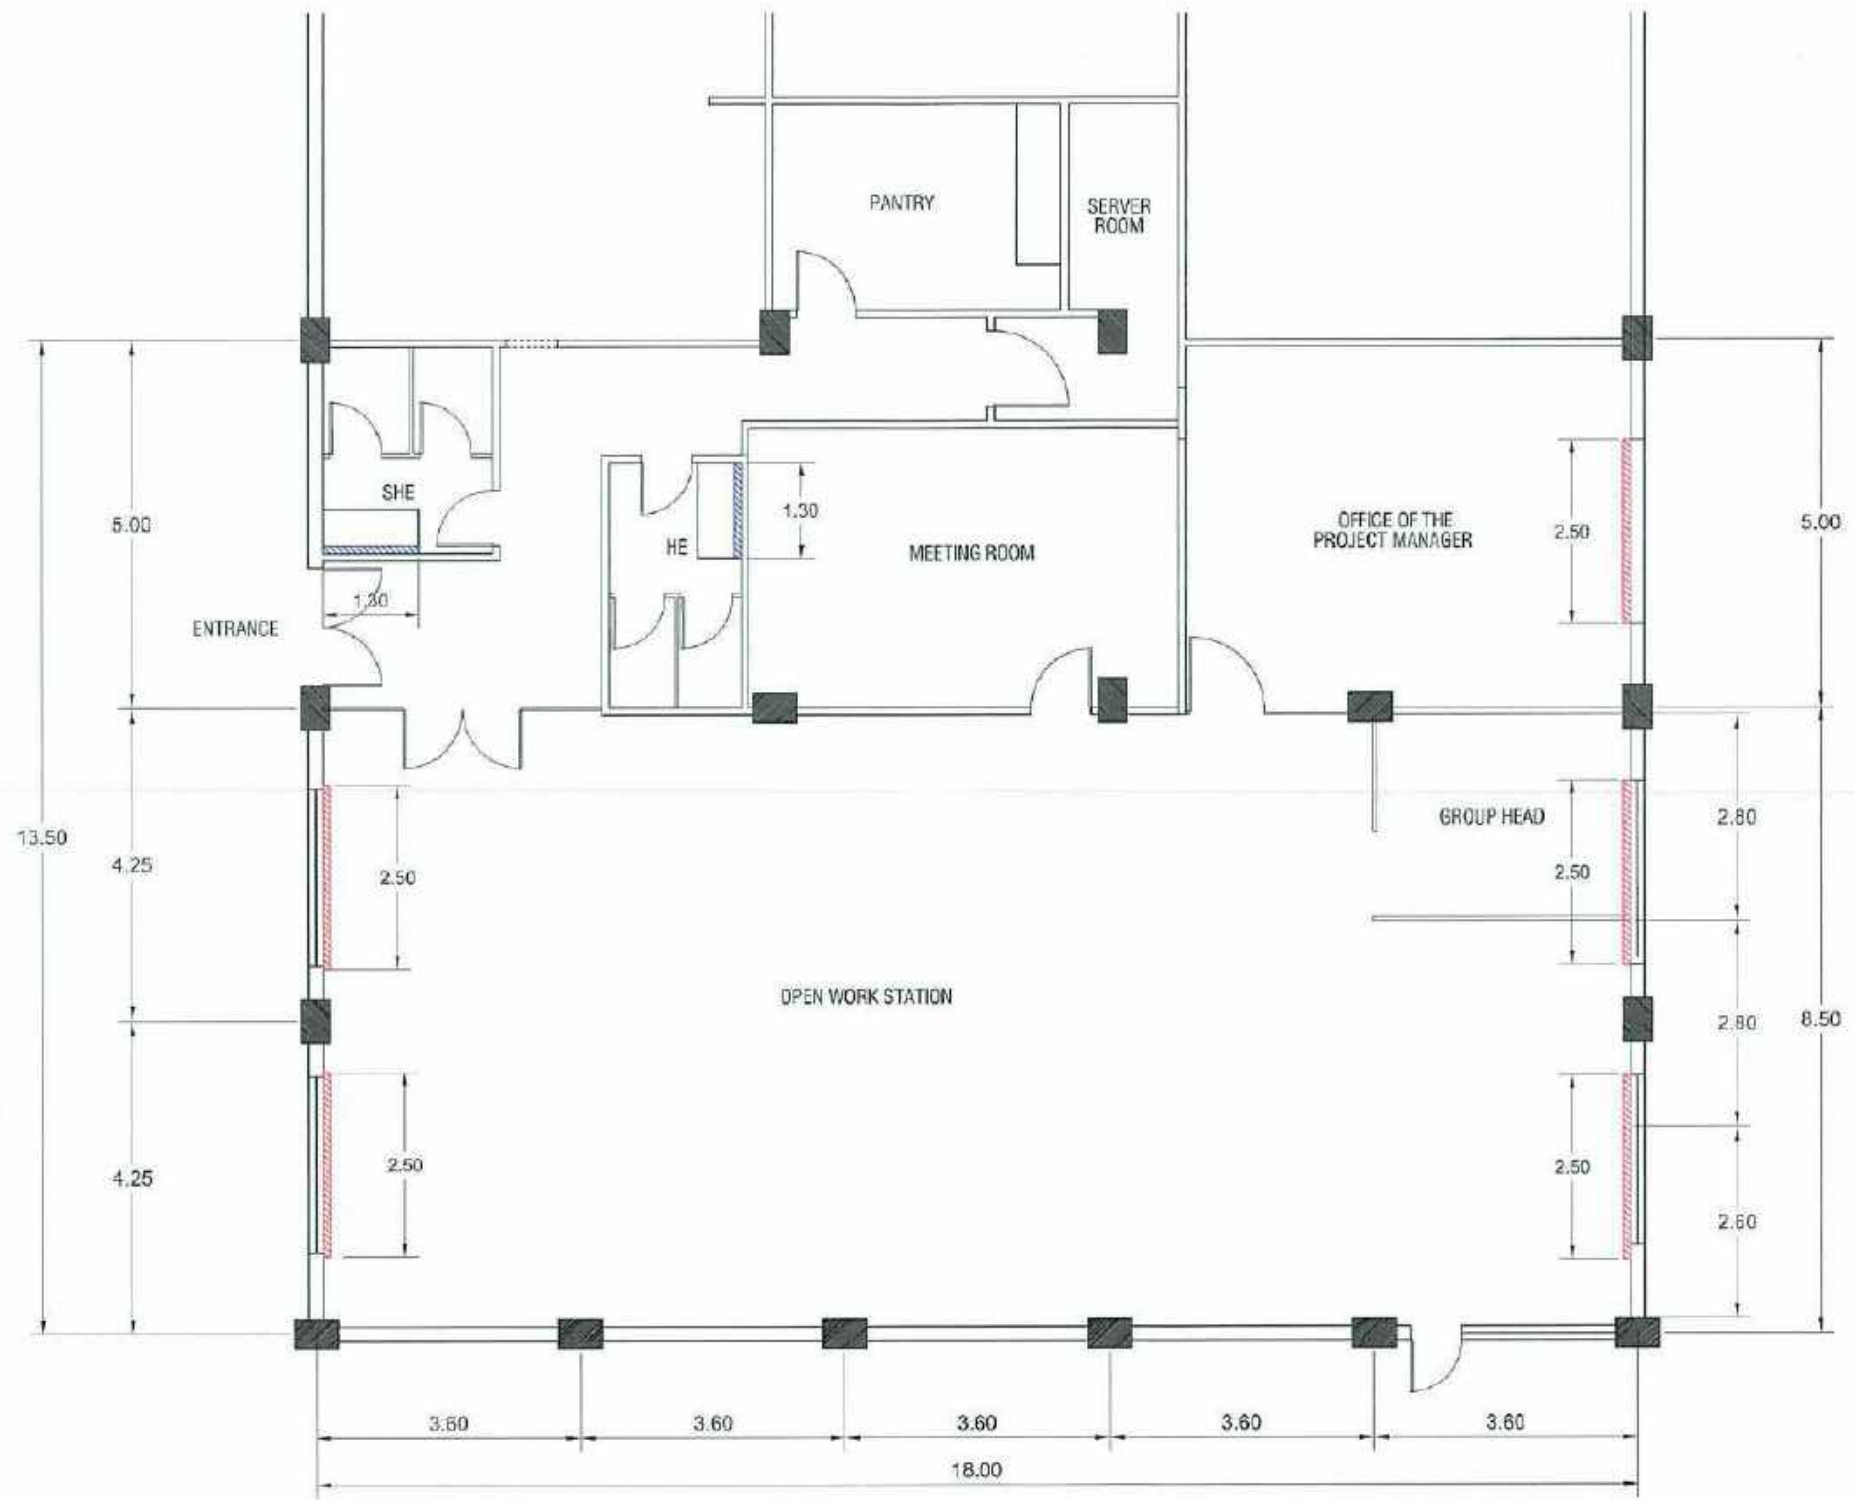


- 5 SET WINDOW BLINDS (ROLL UP)
- 2 PCS. CLEAR GLASS FRAMELESS MIRROR




PROJECT NAME	PREPARED BY	CHECKED / REVIEWED BY	RECOMMENDING APPROVAL	APPROVED BY	SHEET CONTENT	SHEET NO.
PROPOSED SCRP OFFICE CLARK FREE PORT ZONE, PAMPANGA	AR. JUDENE G. LAGOY ARCHITECT, MCCOMO AR. ALBERT S. REYES CAD OPERATOR, SCRP	REY S. LIM PROJECT MANAGER SCRP	AILEEN ANUNCIACION R. ZOSA EXECUTIVE VICE PRESIDENT	VIVENCIO B. DIXON PRESIDENT AND CEO	WINDOW BLINDS & MIRROR SCALE: 1:100 M. DATE: 06-02-2020	A 10

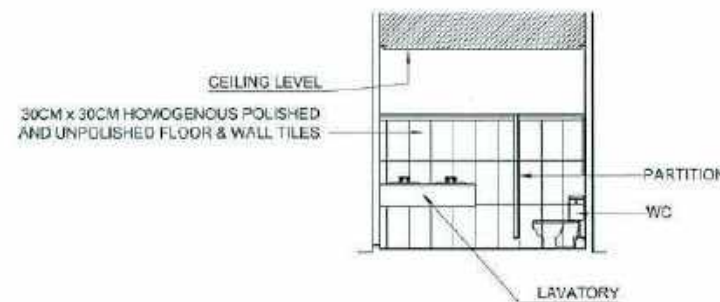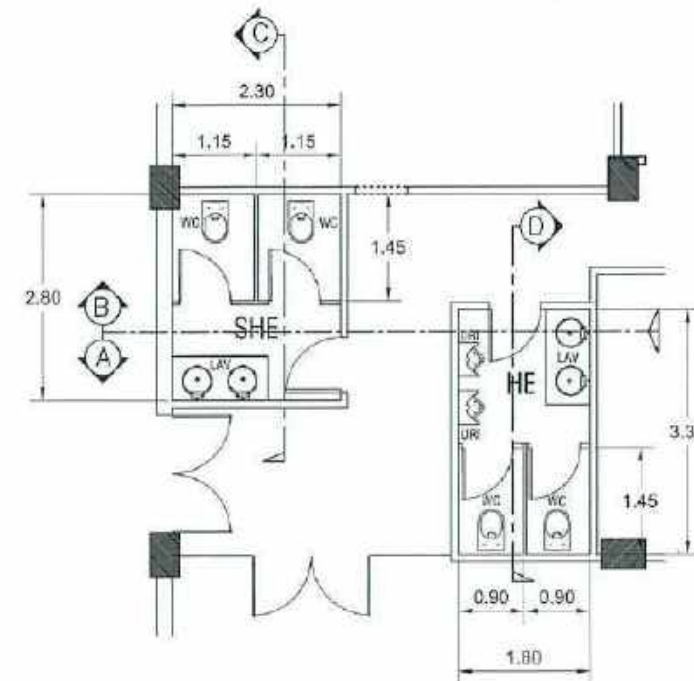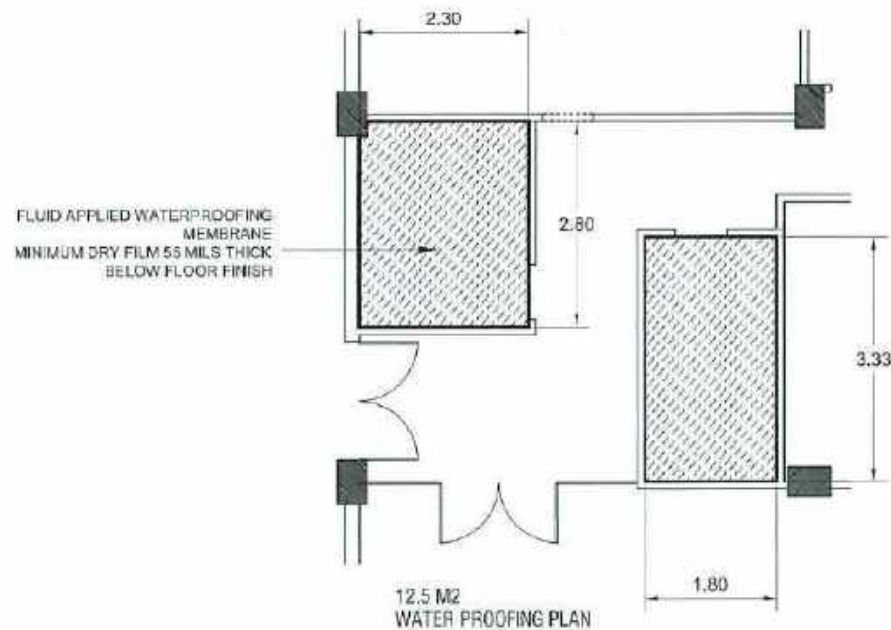


MENS TOILET
SECTION D-D
SCALE 1:100M

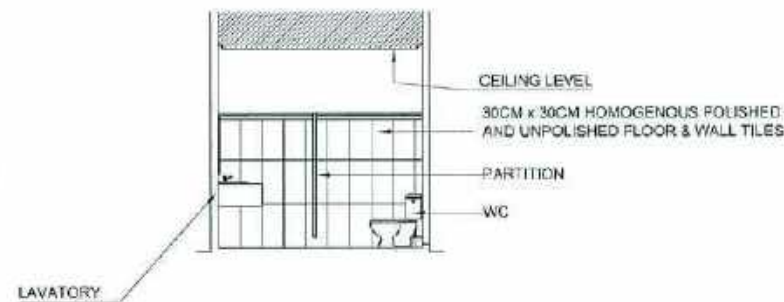

WOMENS TOILET
SECTION C-C
SCALE 1:100M

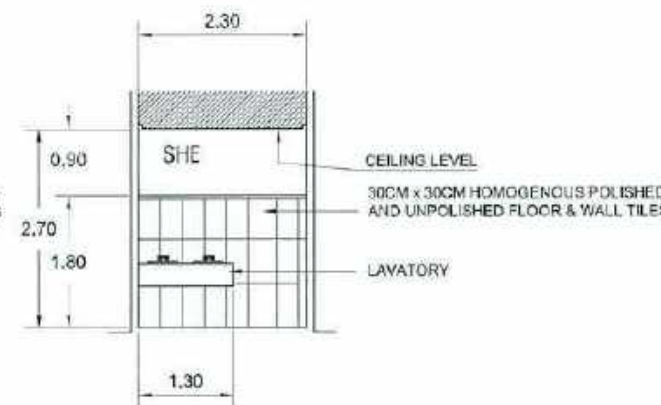


WOMENS TOILET
SECTION A-A
SCALE 1:100M

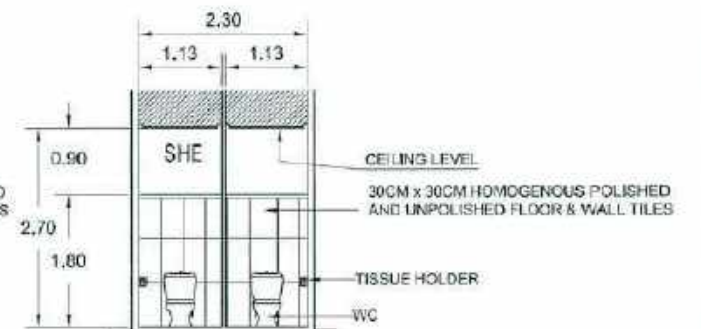

WOMENS TOILET
SECTION B-B
SCALE 1:100M




PROJECT NAME	PREPARED BY	CHECKED & REVIEWED BY	RECOMMENDING APPROVAL	APPROVED BY	SHEET CONTENT	SHEET NO.
PROPOSED SCRP OFFICE CLARK FREE PORT ZONE, PAMPANGA	AR. JUDENE G. LAGOY ARCHITECT, NCA PMO AR. ALBERTO G. REYES CAD OPERATOR, SCRP	REY S. LIM PROJECT MANAGER, SCRP	AILEEN ANUNCIACION R. ZORBA EXECUTIVE VICE PRESIDENT	VENCIO B. DIXON PRESIDENT AND CEO	TYPICAL TOILET DETAILS SCALE 1:100 M, DATE: 06-02-2020	A 11

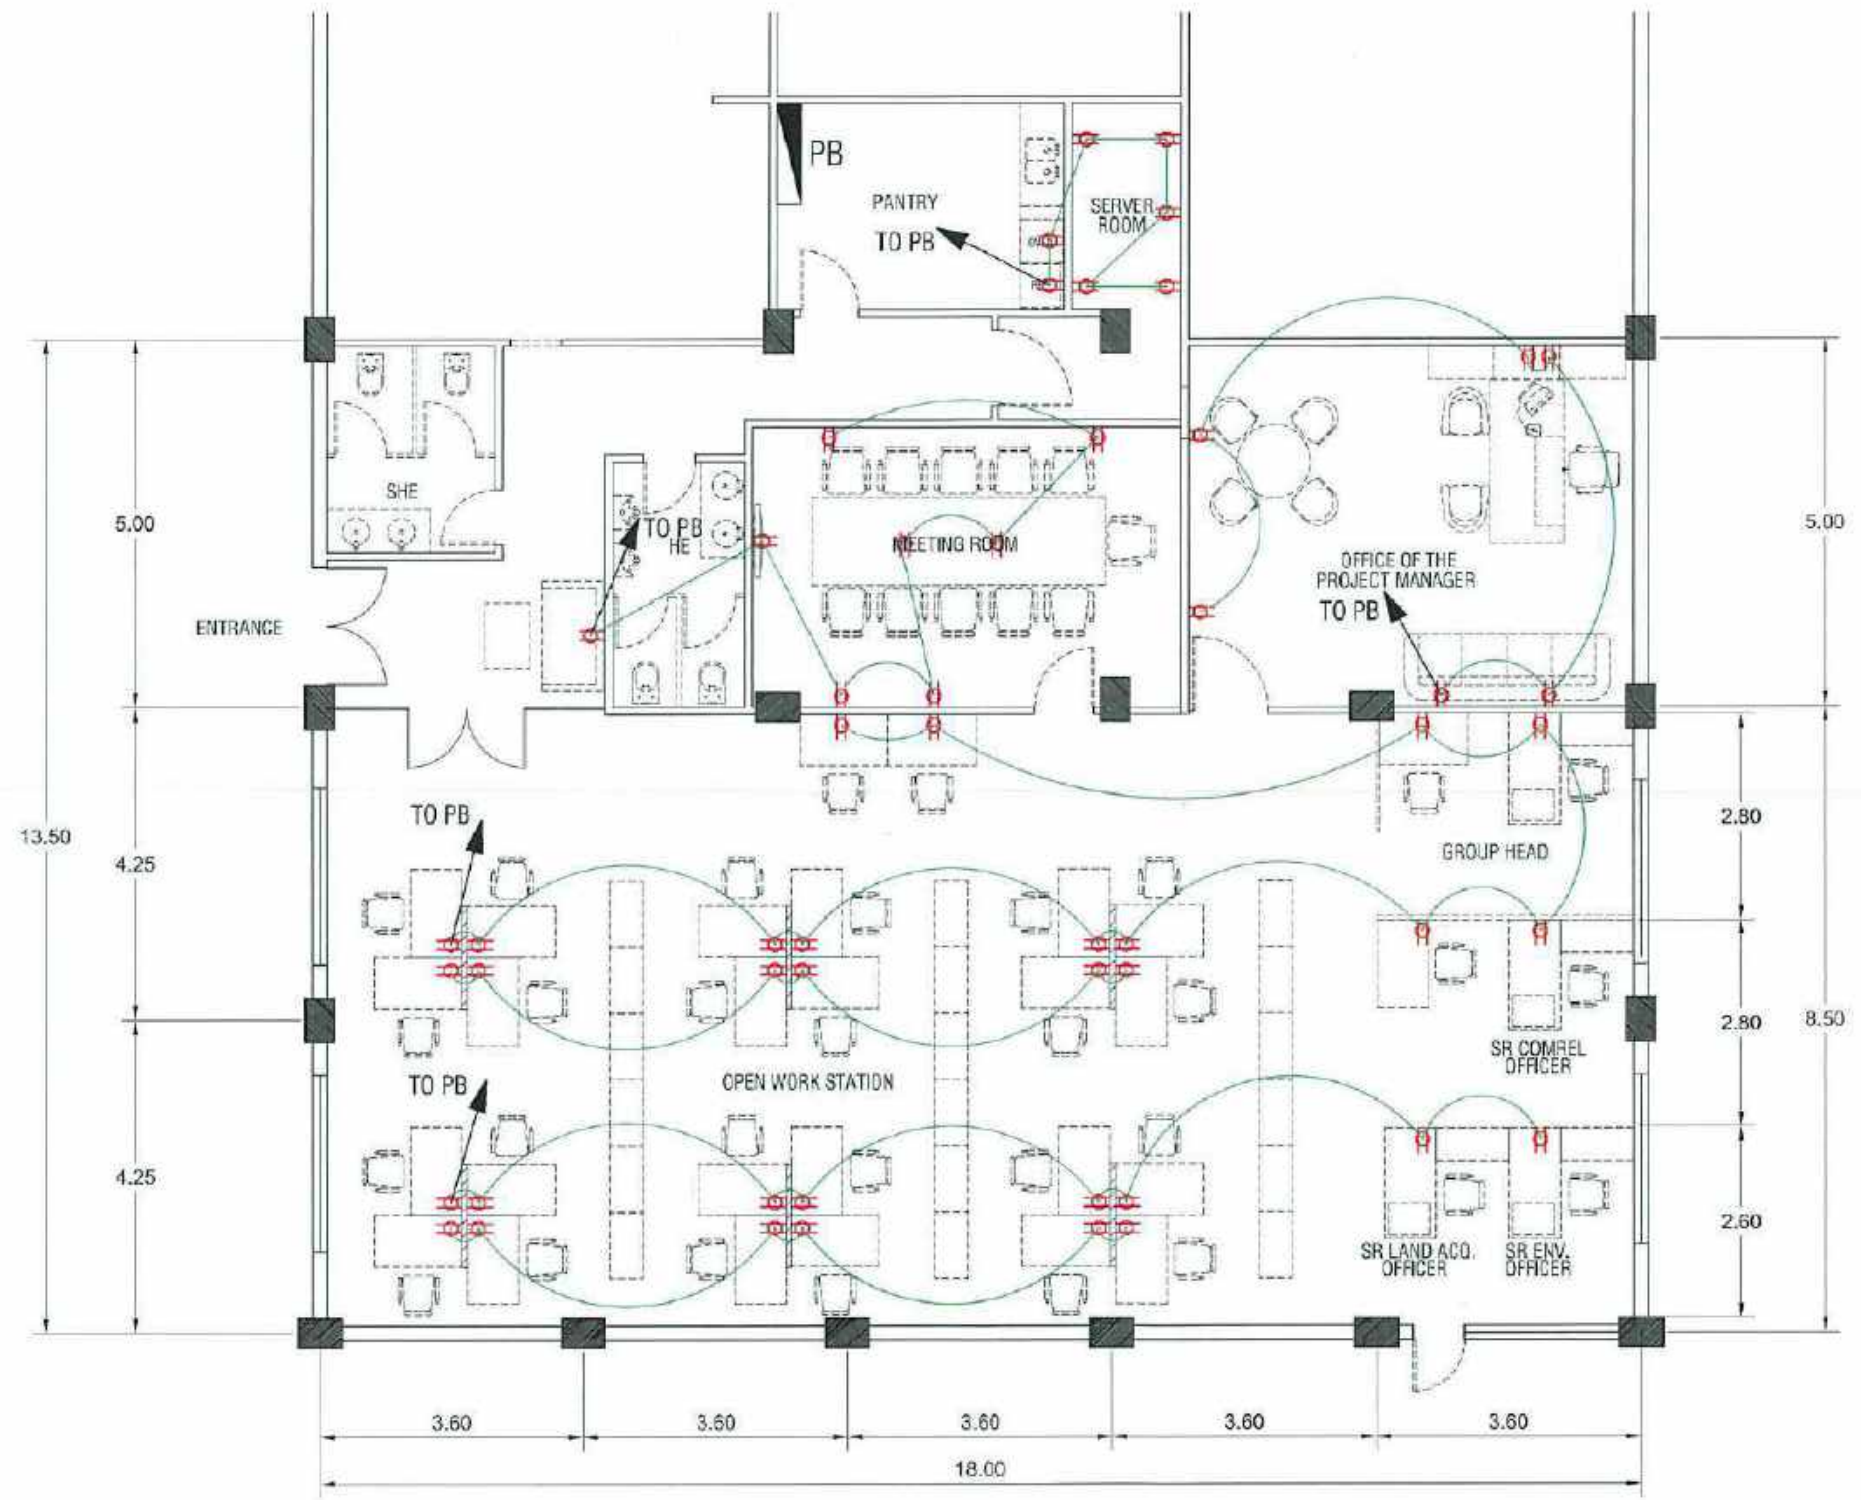

NOTE: 52 PCS. CONVENIENCE OUTLET DUPLEX POINTS
1 PC PANEL BOARD



PROJECT NAME	PREPARED BY	CHECKED & REVIEWED BY	RECOMMENDING APPROVAL	APPROVED BY	SHEET CONTENT	SHEET NO.
PROPOSED SCRP OFFICE CLARK FREE PORT ZONE, PAMPANGA	AR. JUDENE G. LAGOY ARCHITECT, NCCEDM AR. ALBERT G. REYES CO-OPERATOR, SCRP	REYS, LIM PROJECT MANAGER, SCRP	AILEEN ANUNCIACION R. ZOSA EXECUTIVE VICE PRESIDENT	VIVENCIO B. DIZON PRESIDENT AND CEO	POWER LAYOUT	E 01
					SCALE: 1:100 M.	DATE: 06-02-2020

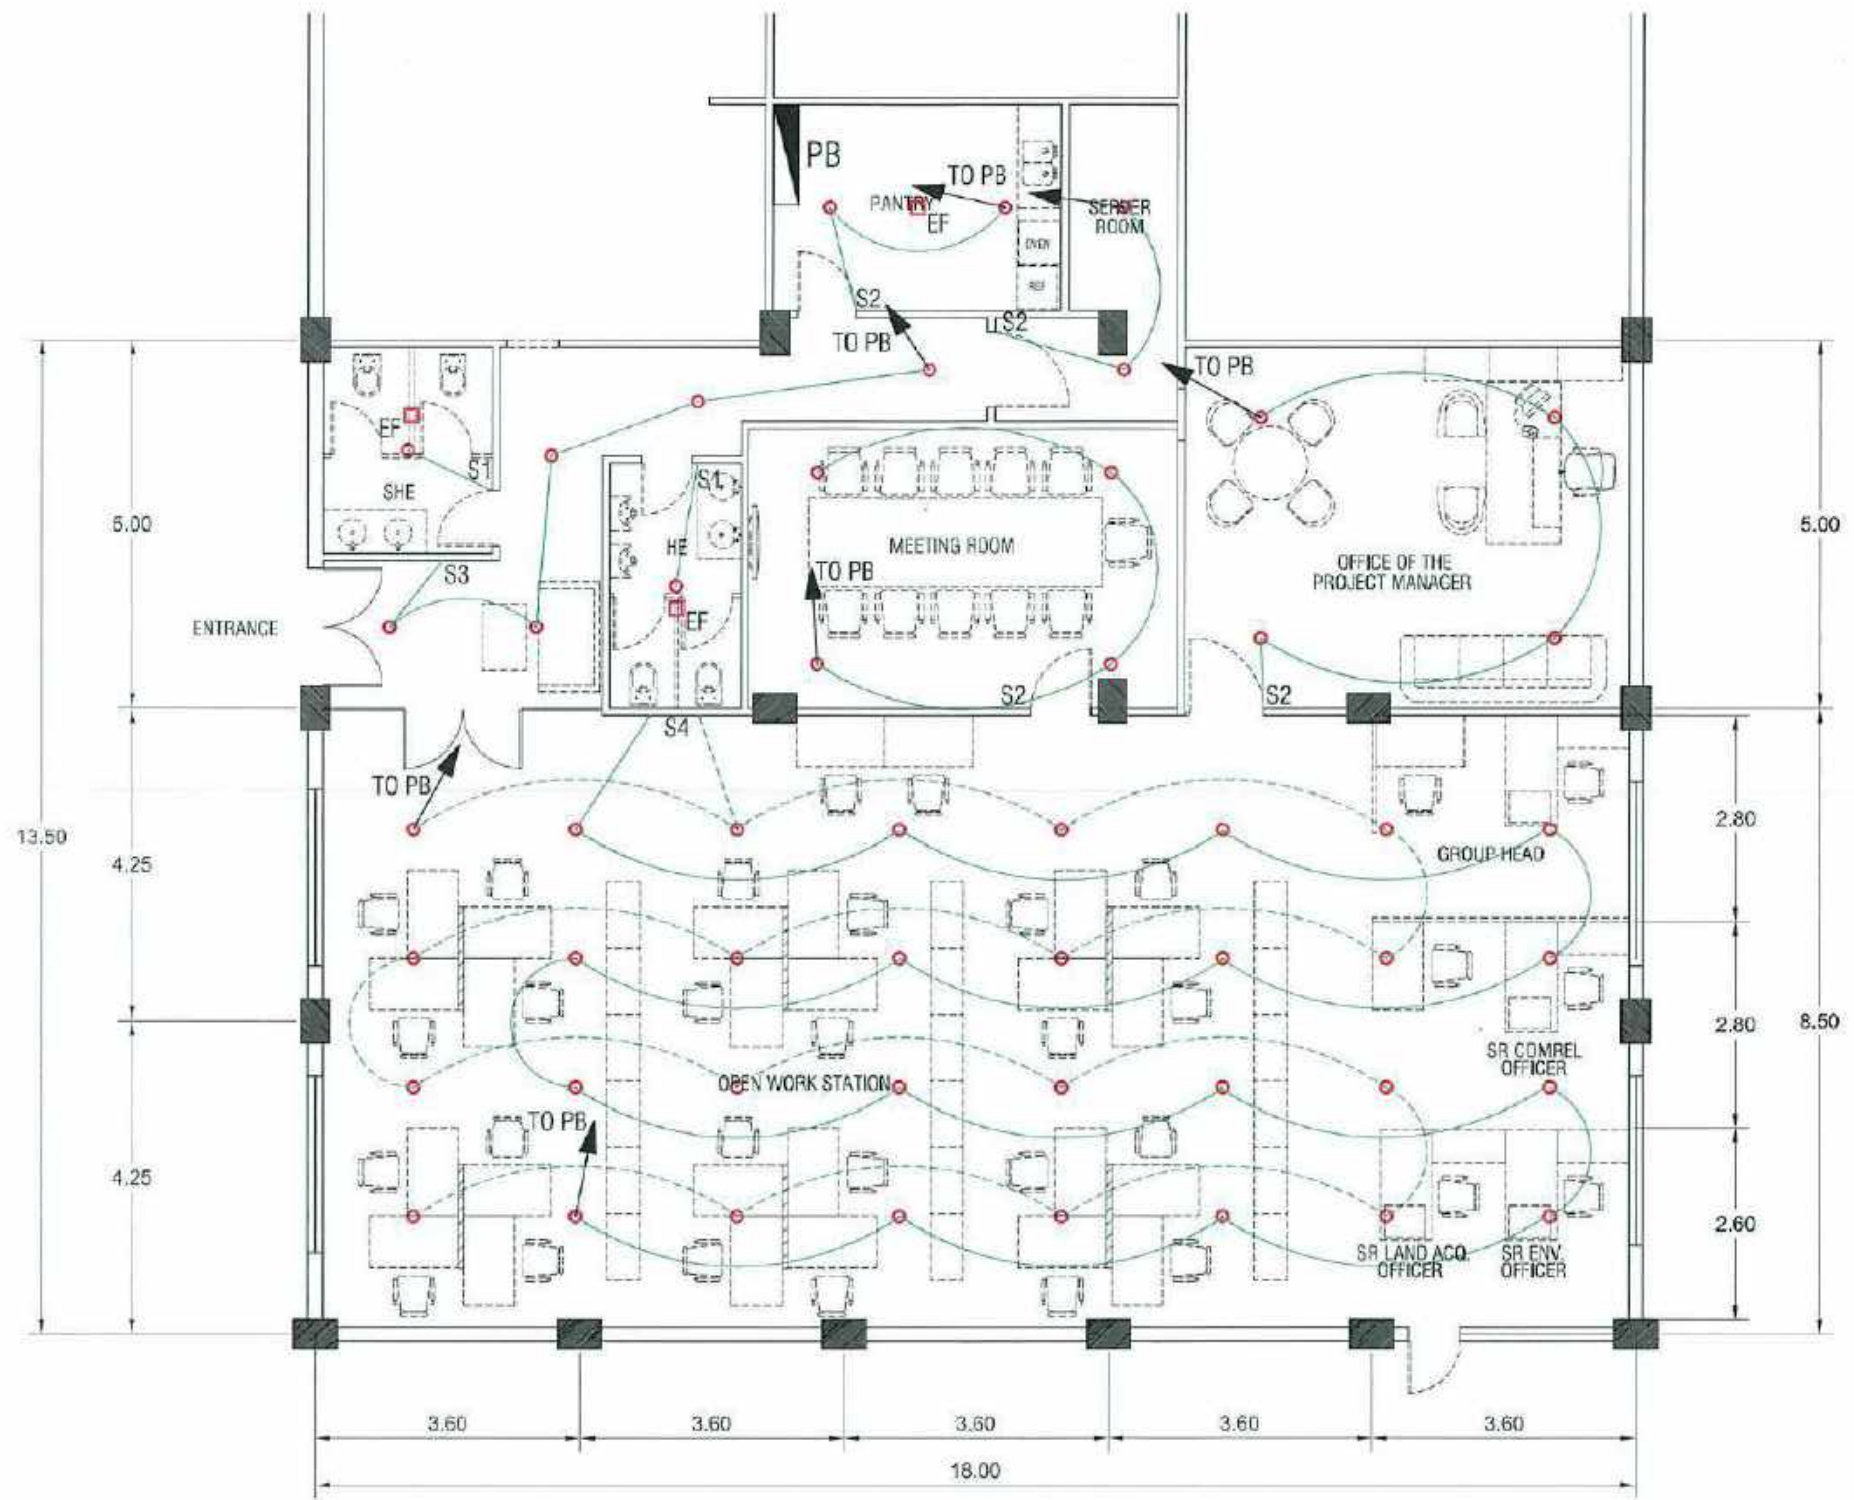




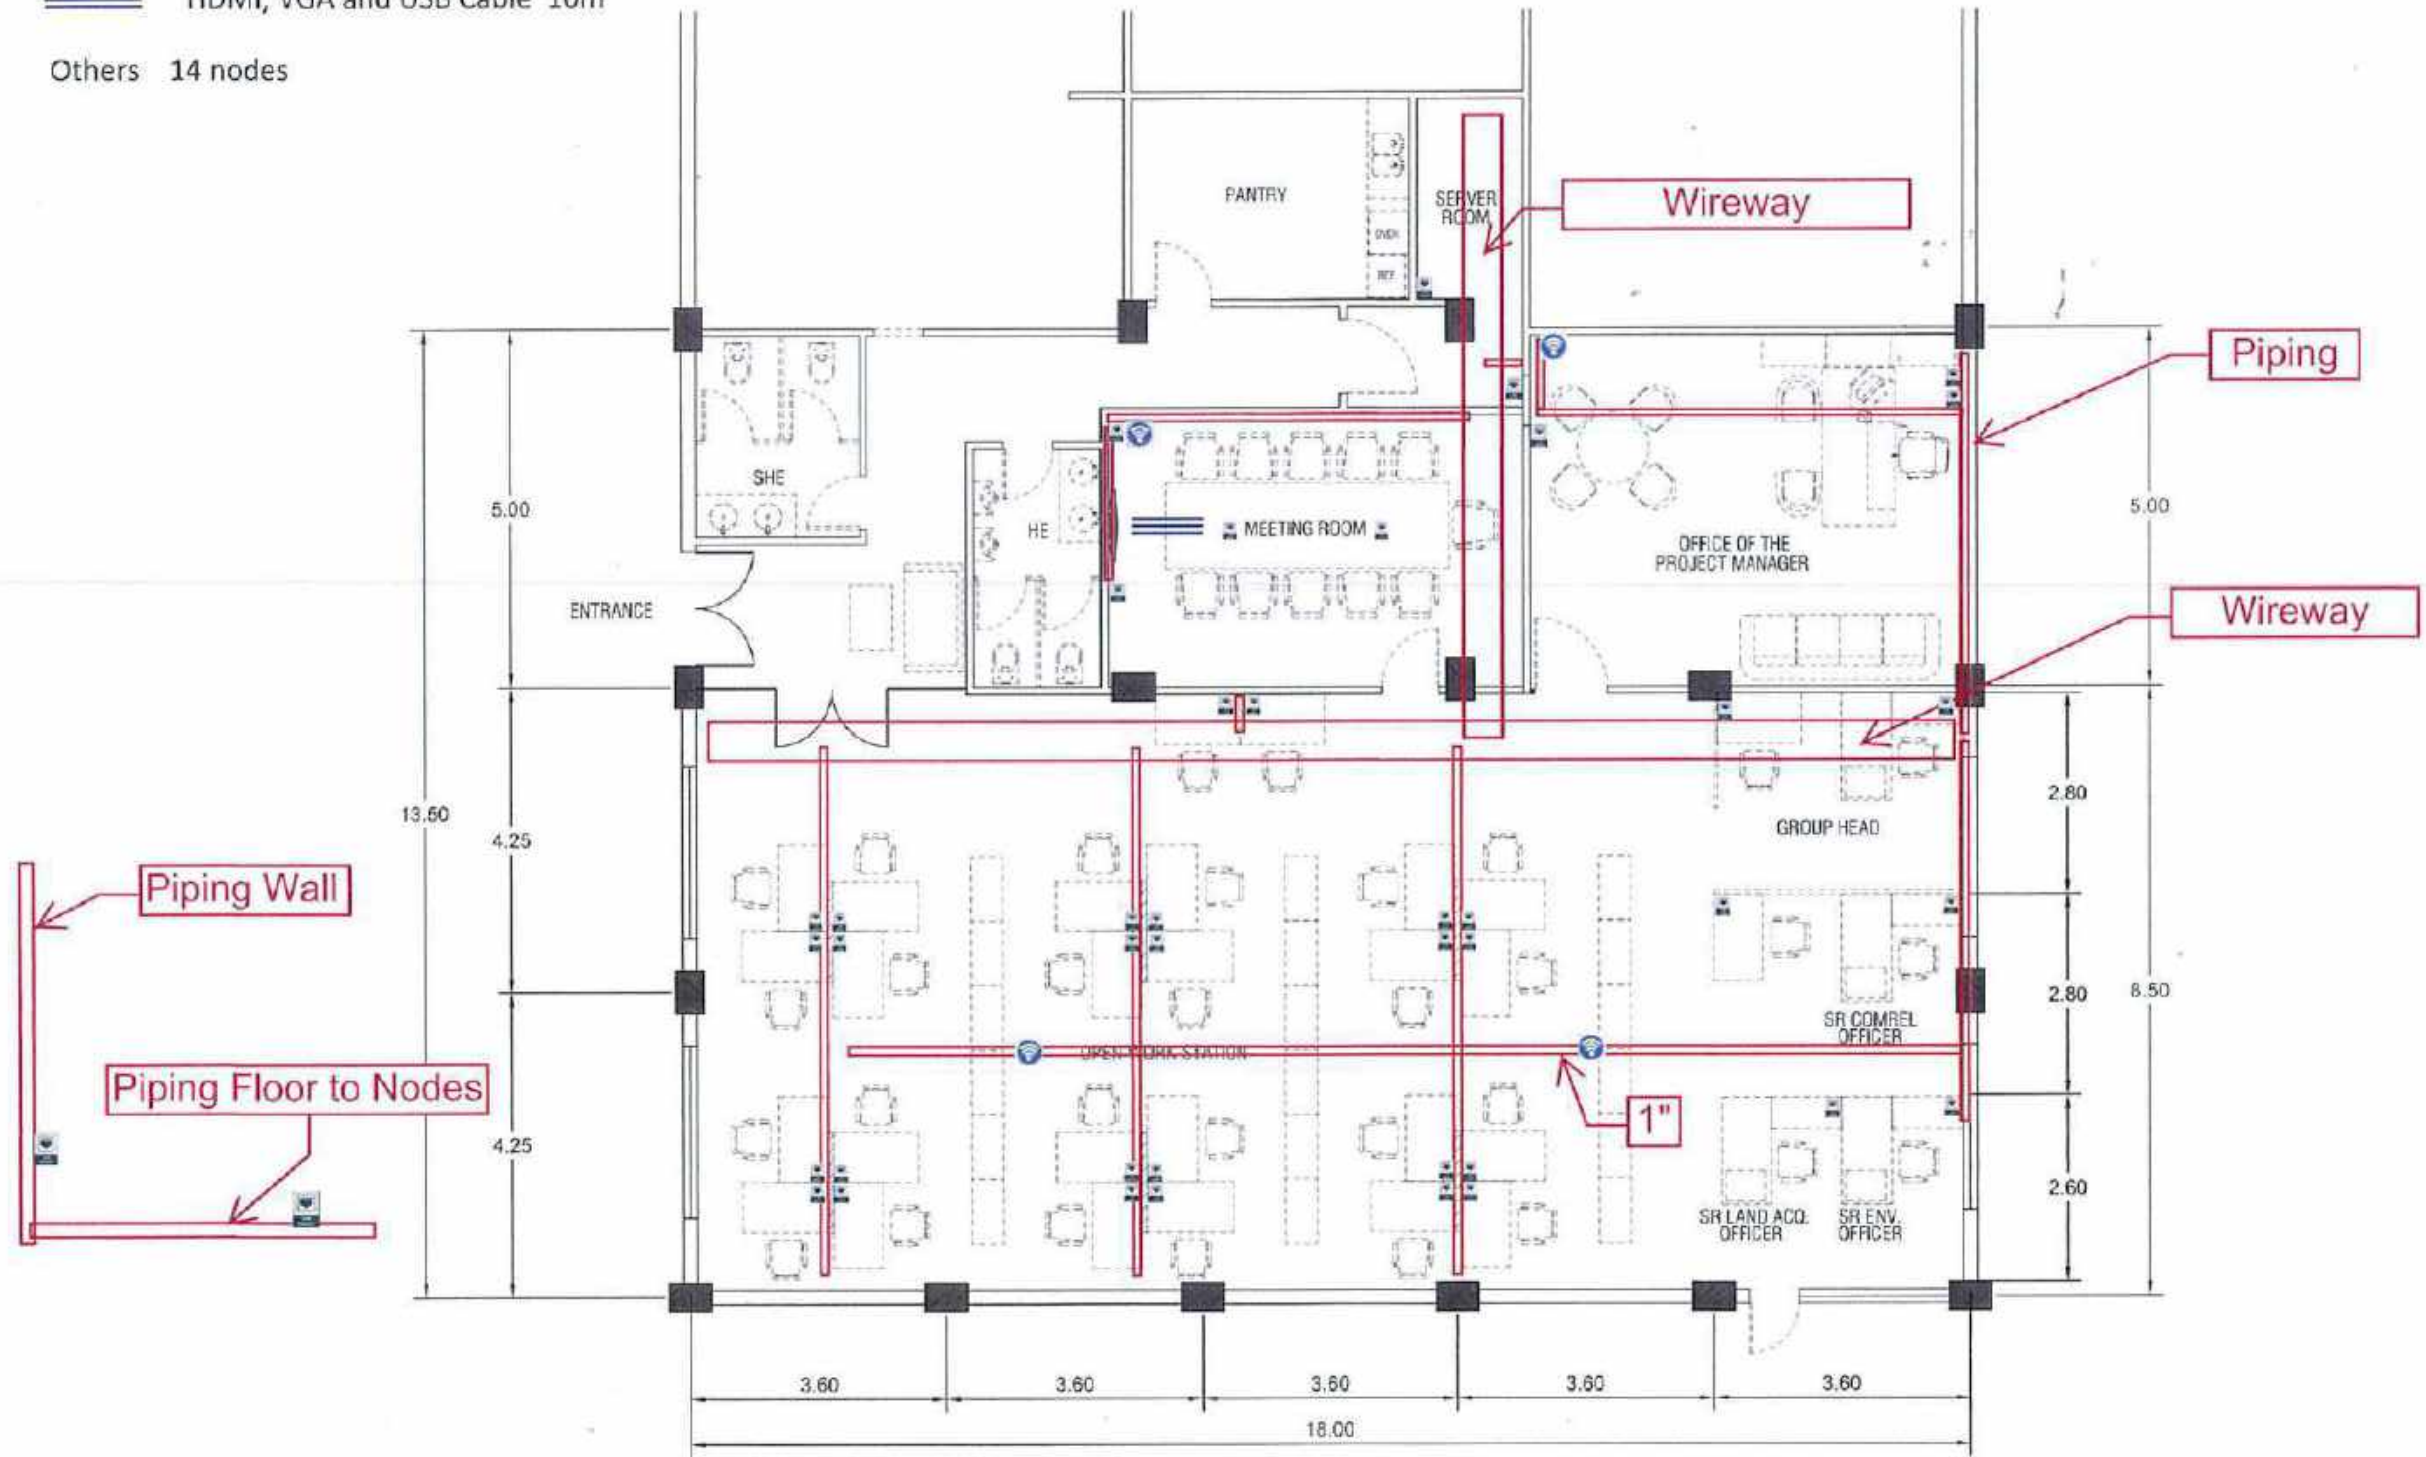
NOTE: 51 PCS. LIGHTING POINTS
 8 PCS. LIGHTING SWITCH
 3 PCS. EXHAUST FANS




PROJECT NAME	PREPARED BY	CHECKED & REVIEWED BY	RECOMMENDING APPROVAL	APPROVED BY	SHEET CONTENT	SHEET NO.
PROPOSED SCRIP OFFICE CLARK FREE PORT ZONE, PAMPANGA	AR. JUDENE G. LAGOY ARCHITECT, NCRMO AR. ALBERTO REYES JOB OPERATOR, SCRIP	REYES, LIM PROJECT MANAGER, SCRIP	AILEEN ANUNCIACION R. ZORA EXECUTIVE VICE PRESIDENT	VIVENCIO B. DIZON PRESIDENT AND CEO	LIGHTING LAYOUT SCALE: 1 : 100 M. DATE: 06-02-2020	E 02

PROVISION FOR NETWORK AND AUDIO/VIDEO STRUCTURED CABLING

-  LAN Port 41 nodes (wall, floor mount)
-  Access Point 4 nodes (ceiling mount)
-  HDMI, VGA and USB Cable 10m
- Others 14 nodes



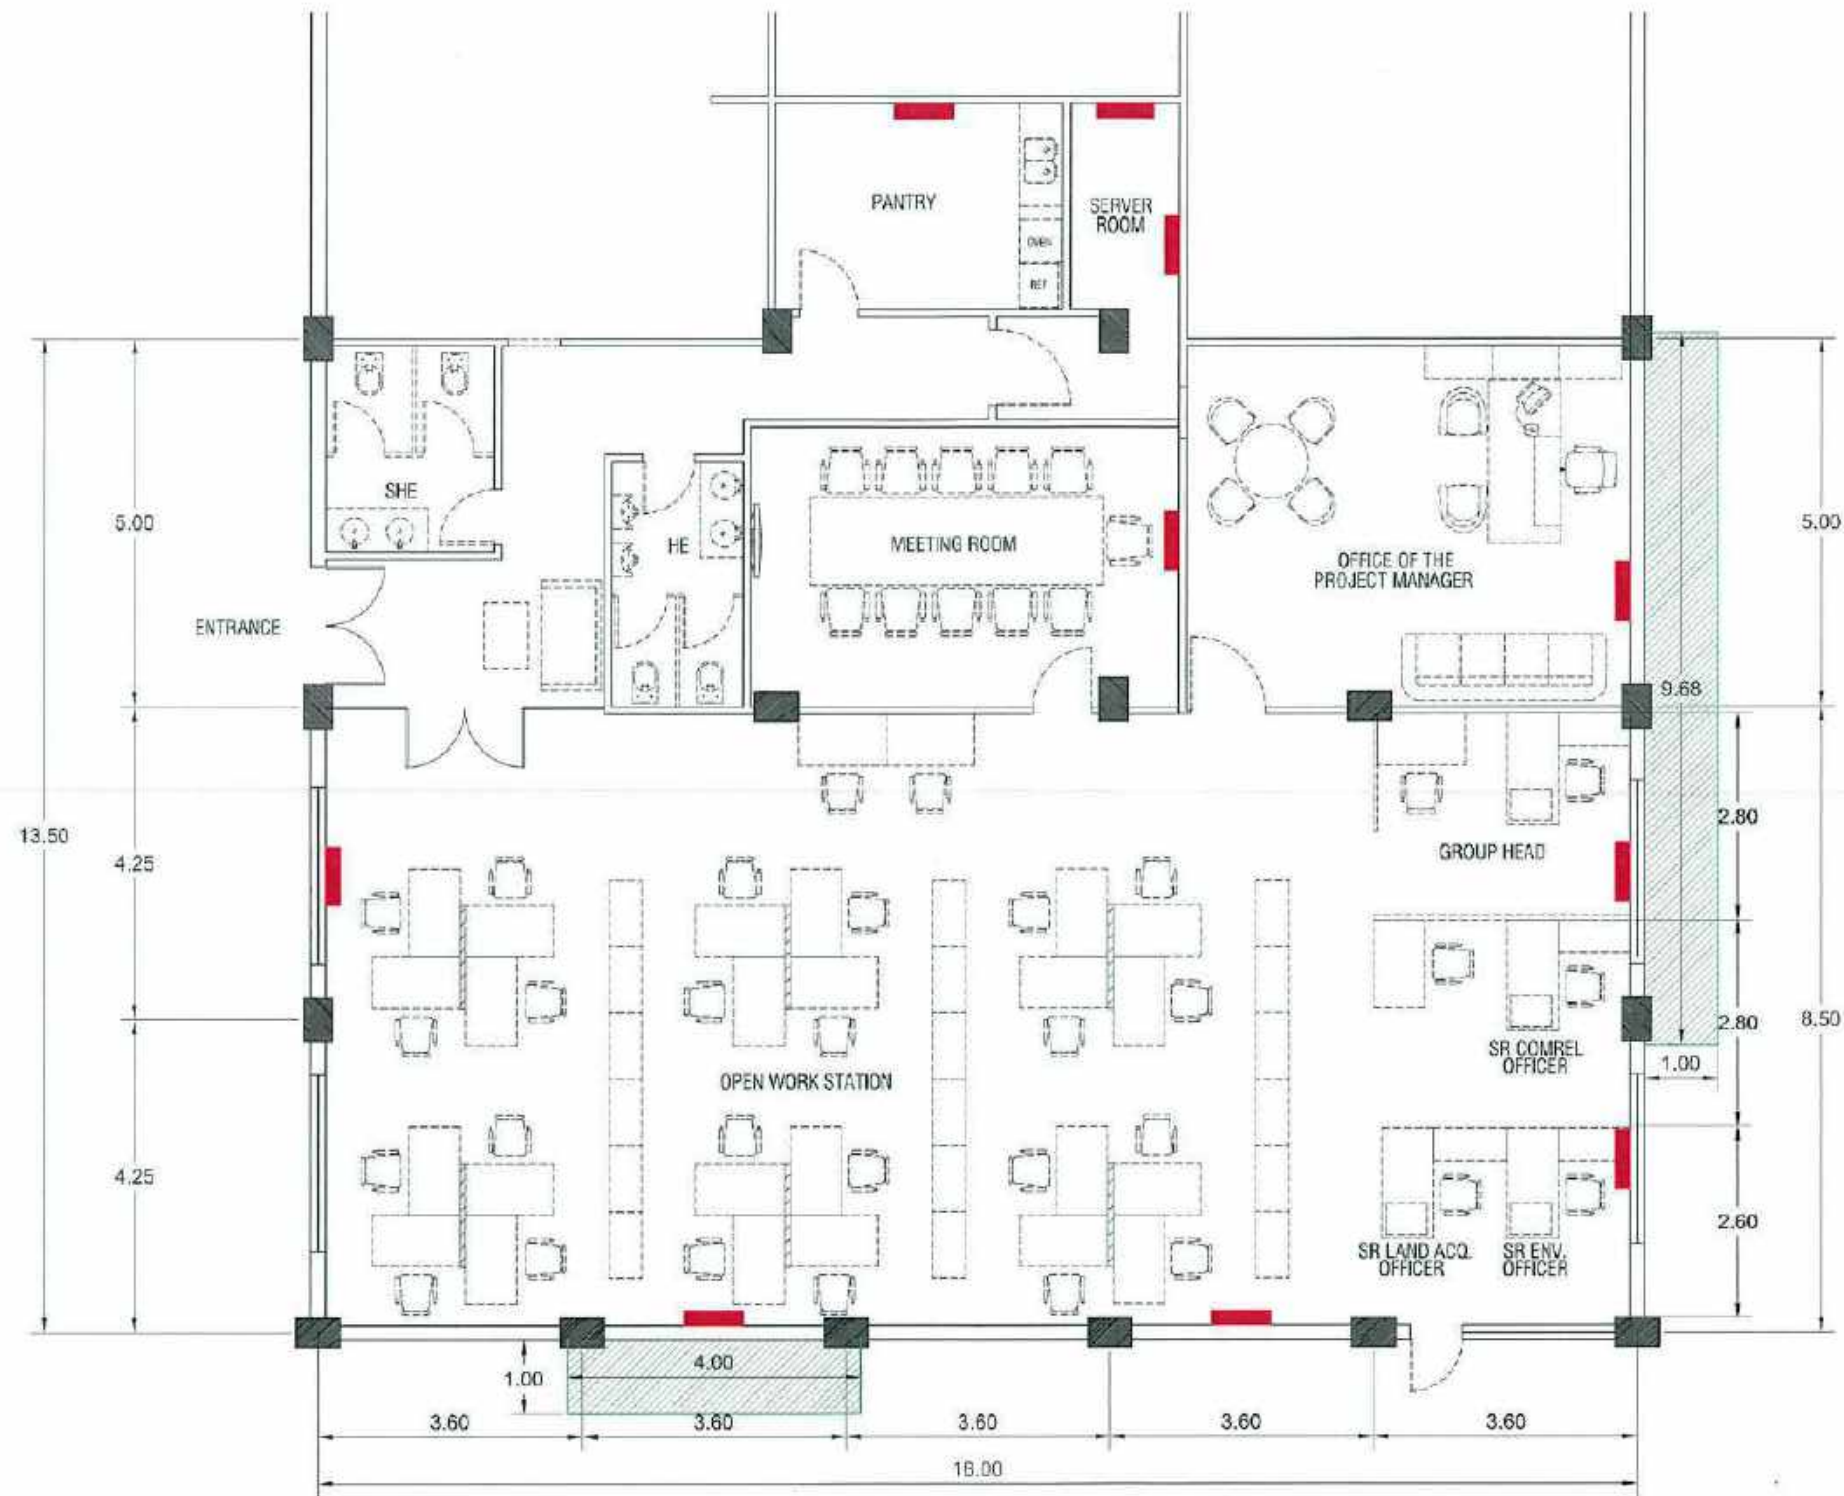


ACU INDOOR UNIT

CONCRETE PLATFORM FOR ACU OUTDOOR UNIT

A=13.70 sq.m THK=100mm



PROJECT NAME	PREPARED BY	CHECKED & REVIEWED BY	RECOMMENDING APPROVAL	APPROVED BY	SHEET CONTENT	SHEET NO.
PROPOSED SCRP OFFICE CLARK FREE PORT ZONE, PAUPANGA	AR. JUDENE G. LAGOY ARCHITECT, NCP, PMA AR. ALBERT G. REYES Landscape Architect, SCRP	MEY S. LIM PROJECT MANAGER, SCRP	AILEEN ANUNCIACION R. ZOS EXECUTIVE VICE PRESIDENT	VIVENCIO B. DIZON PRESIDENT AND CEO	ACU LAYOUT SCALE: 1:100 M. DATE: 06-02-2020	E 05

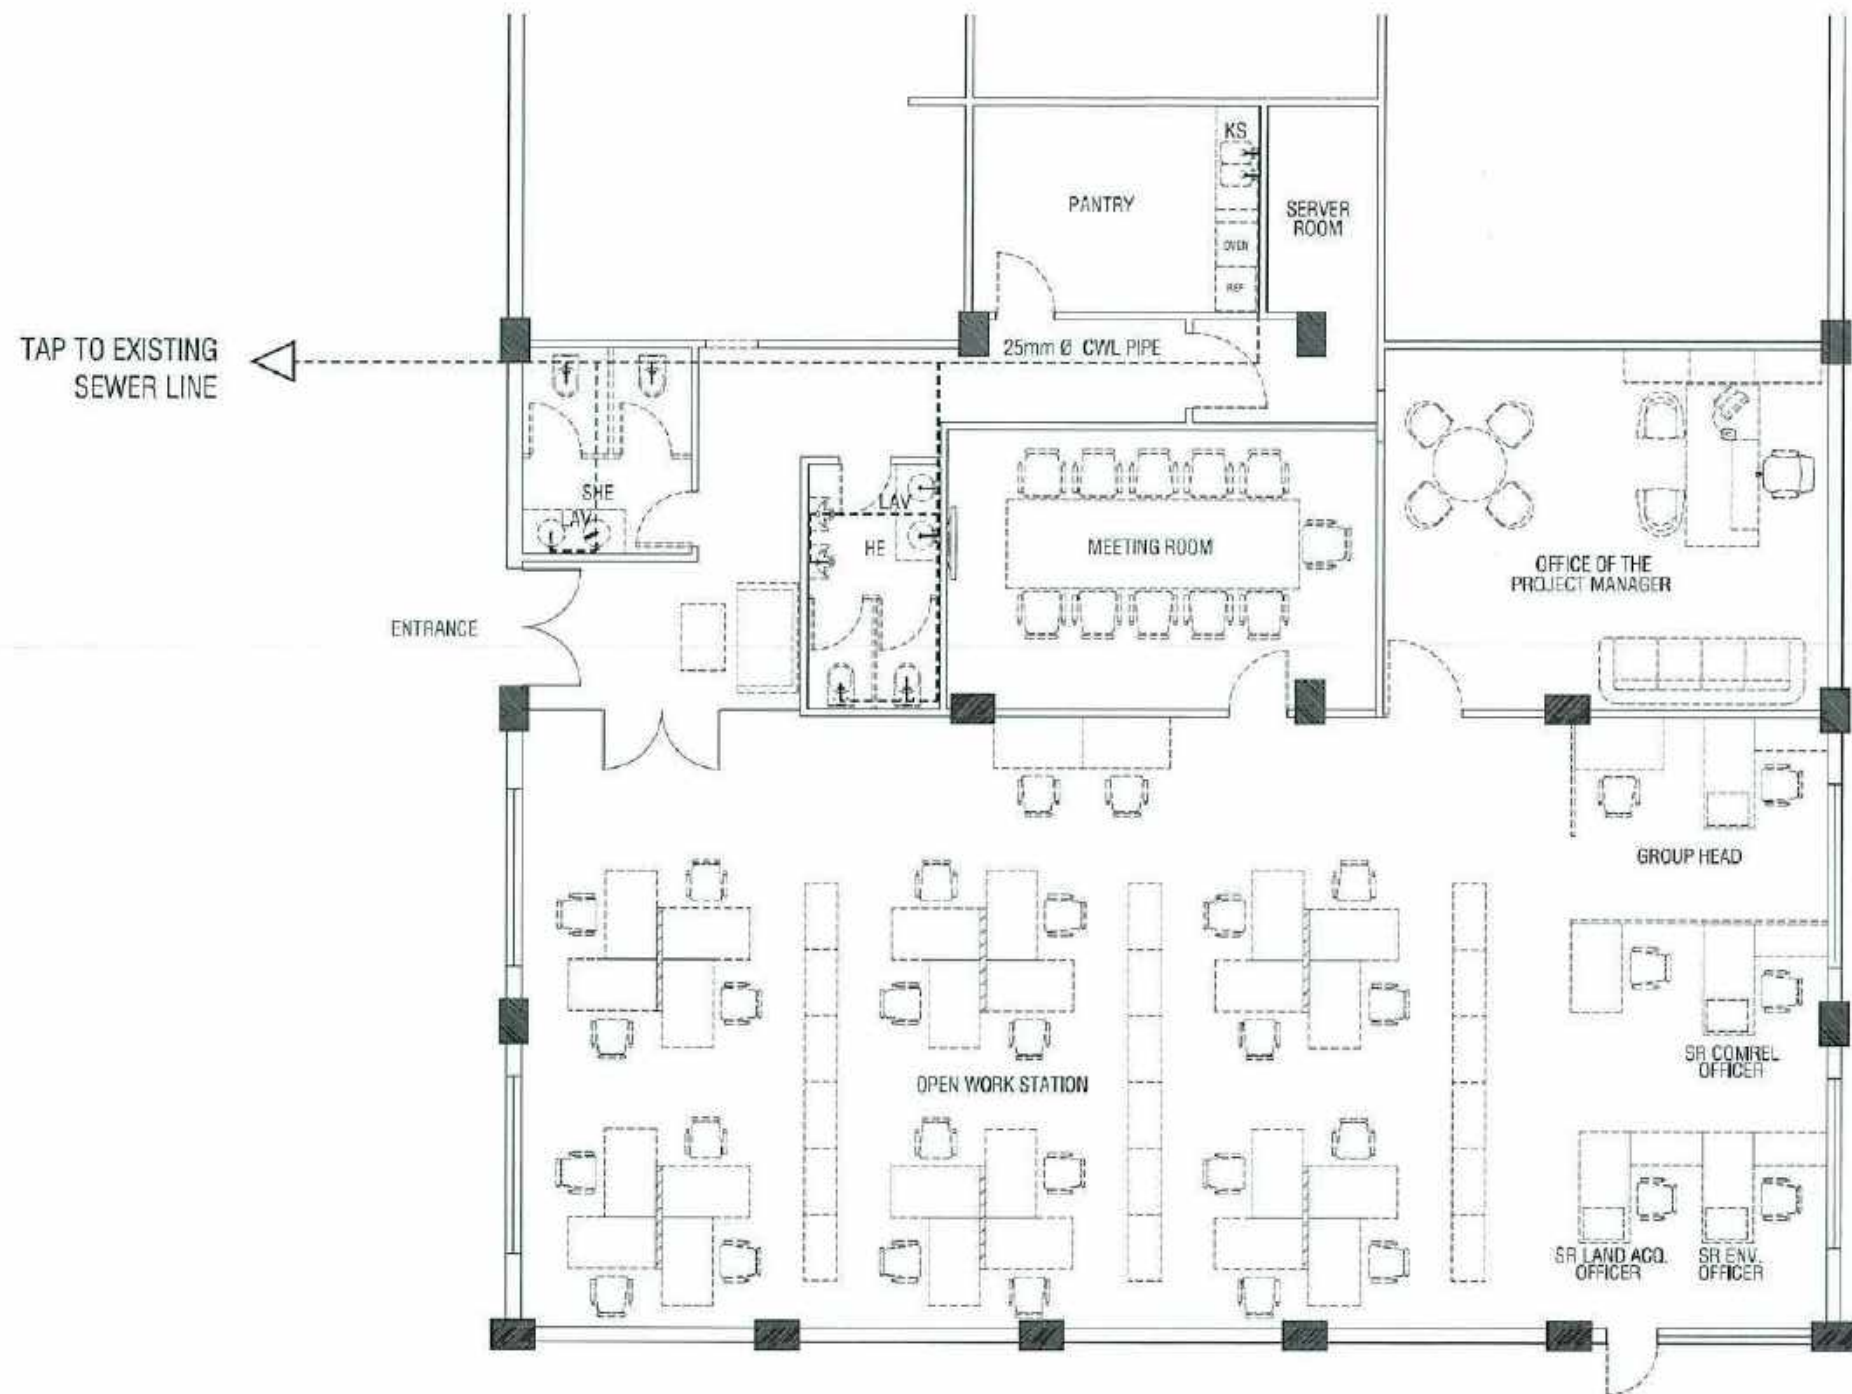

FLOOR SHOULD HAVE A WATER PROOFING,
DRAIN WITH CONTAINMENT. SINK WASTE DRAIN
SHALL ALSO HAVE AN IN-LINE GREASE TRAP.

FLOOR DRAIN MUST BE 50mmØ
WITH 100mm STRAINER FOR TOILETS.

TAP TO EXISTING
SEWER LINE

FLOOR DRAIN MUST BE 50mmØ
WITH 100mm STRAINER FOR TOILETS.

