


SCRIP PROPOSED OFFICE
J. TOPACIO STREET COR. C.M. RECTO HI-WAY
CLARK FREEPORT ZONE PAMPANGA

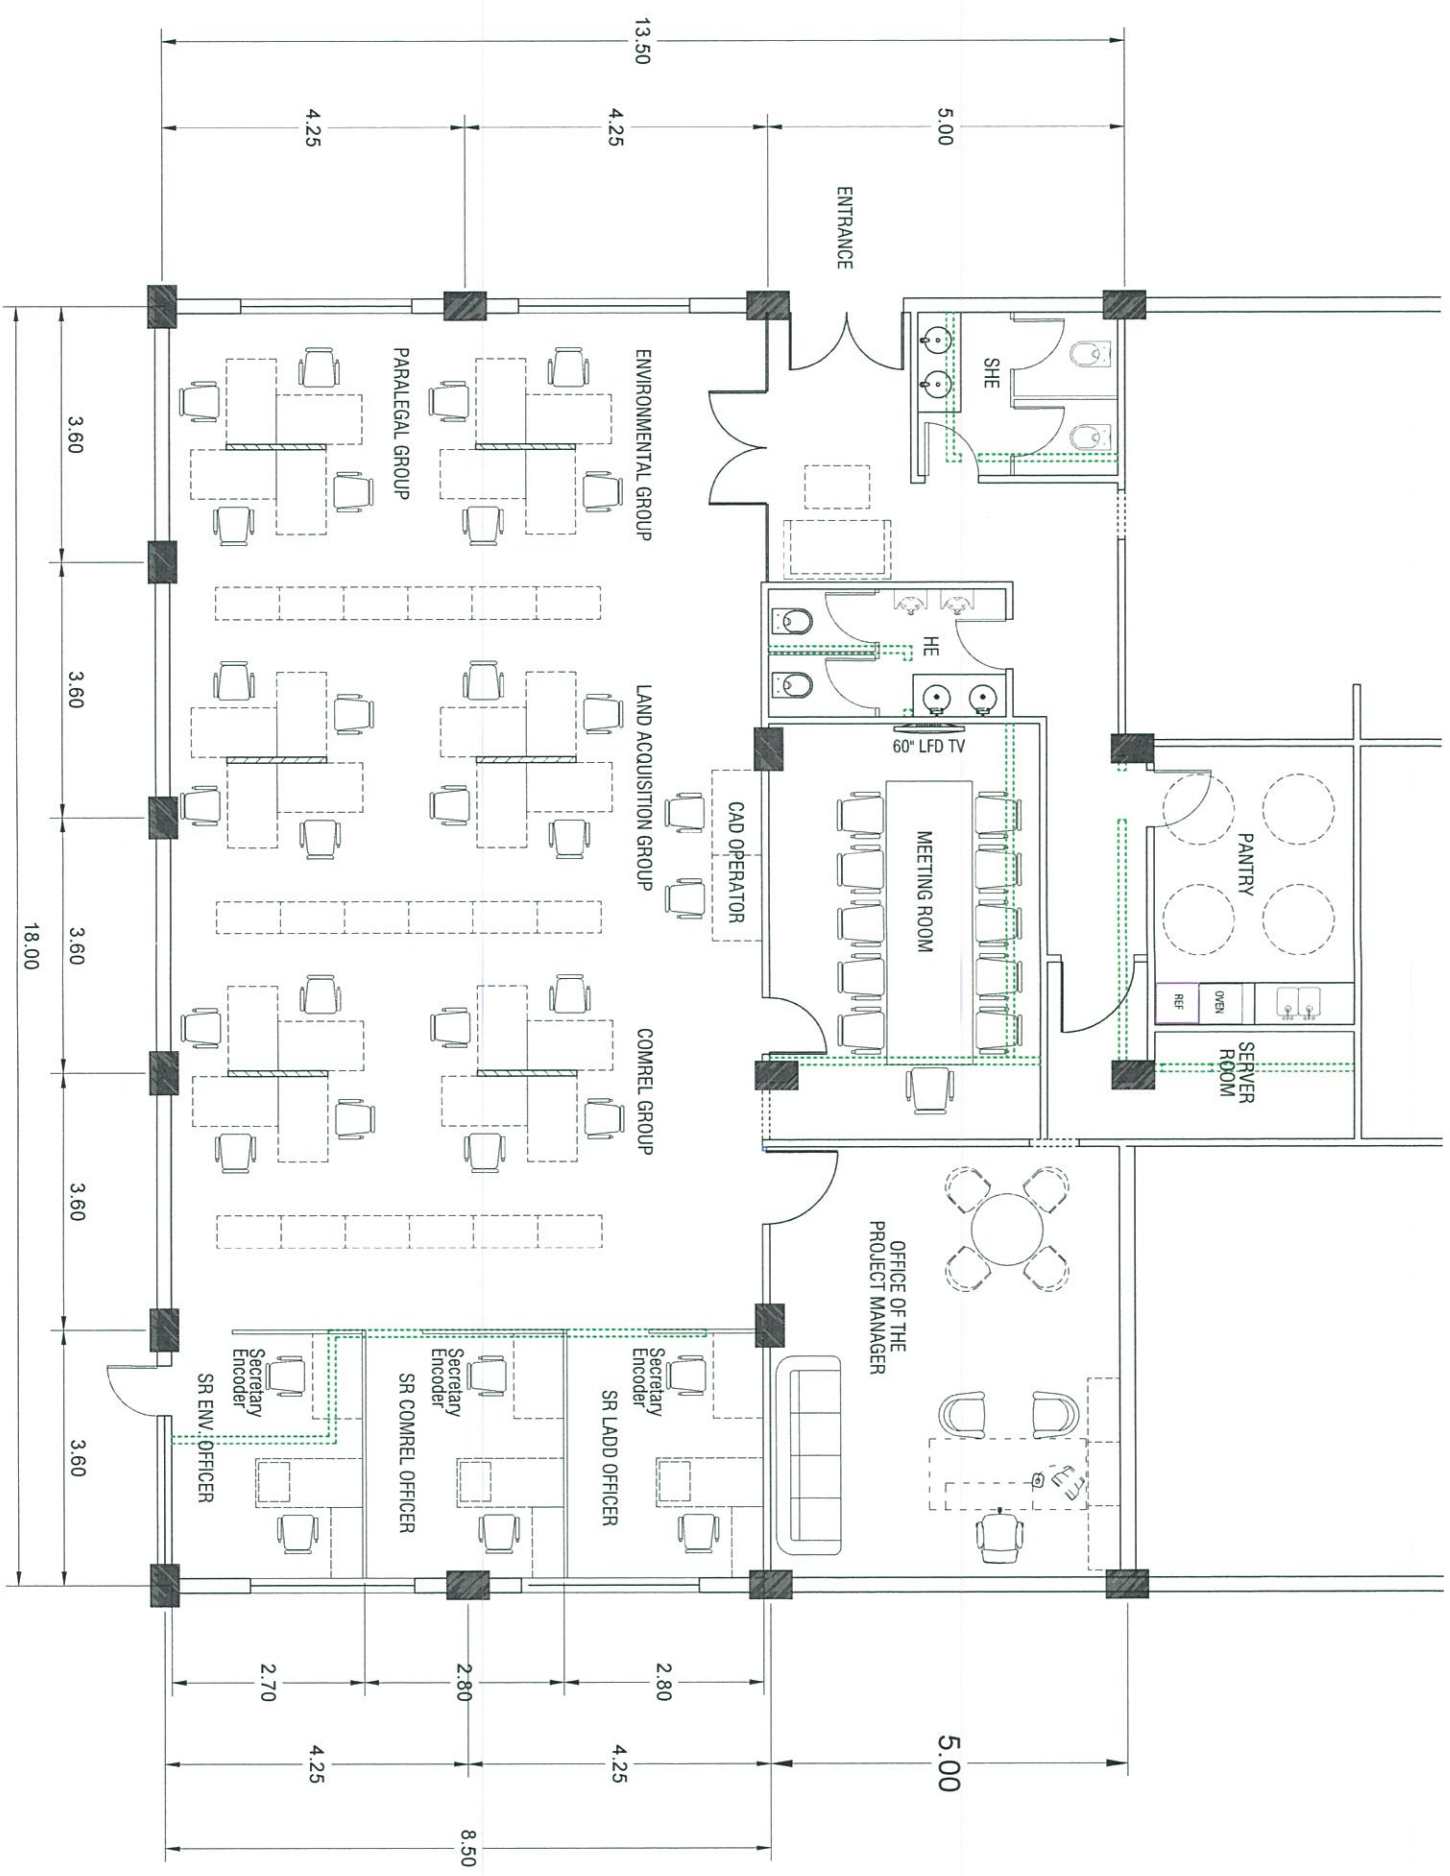




----- WALL TO BE DEMOLISHED




PROJECT NAME PROPOSED SCRP OFFICE CLARK FREE PORT ZONE, PAMPANGA	PREPARED BY JUDENE G. LAGOSY NCC PMO	CHECKED & REVIEWED BY KEY S. LIM PROJECT MANAGER, SCRP	RECOMMENDING APPROVAL AILEEN ANUNCIACION R. ROSA EXECUTIVE VICE PRESIDENT	APPROVED BY VENCIO B. DIZON PRESIDENT AND CEO	SHEET CONTENT GENERAL FLOOR PLAN	SHEET NO. A 01
SCALE 1 : 100 M.	DATE : 10-15-2019					

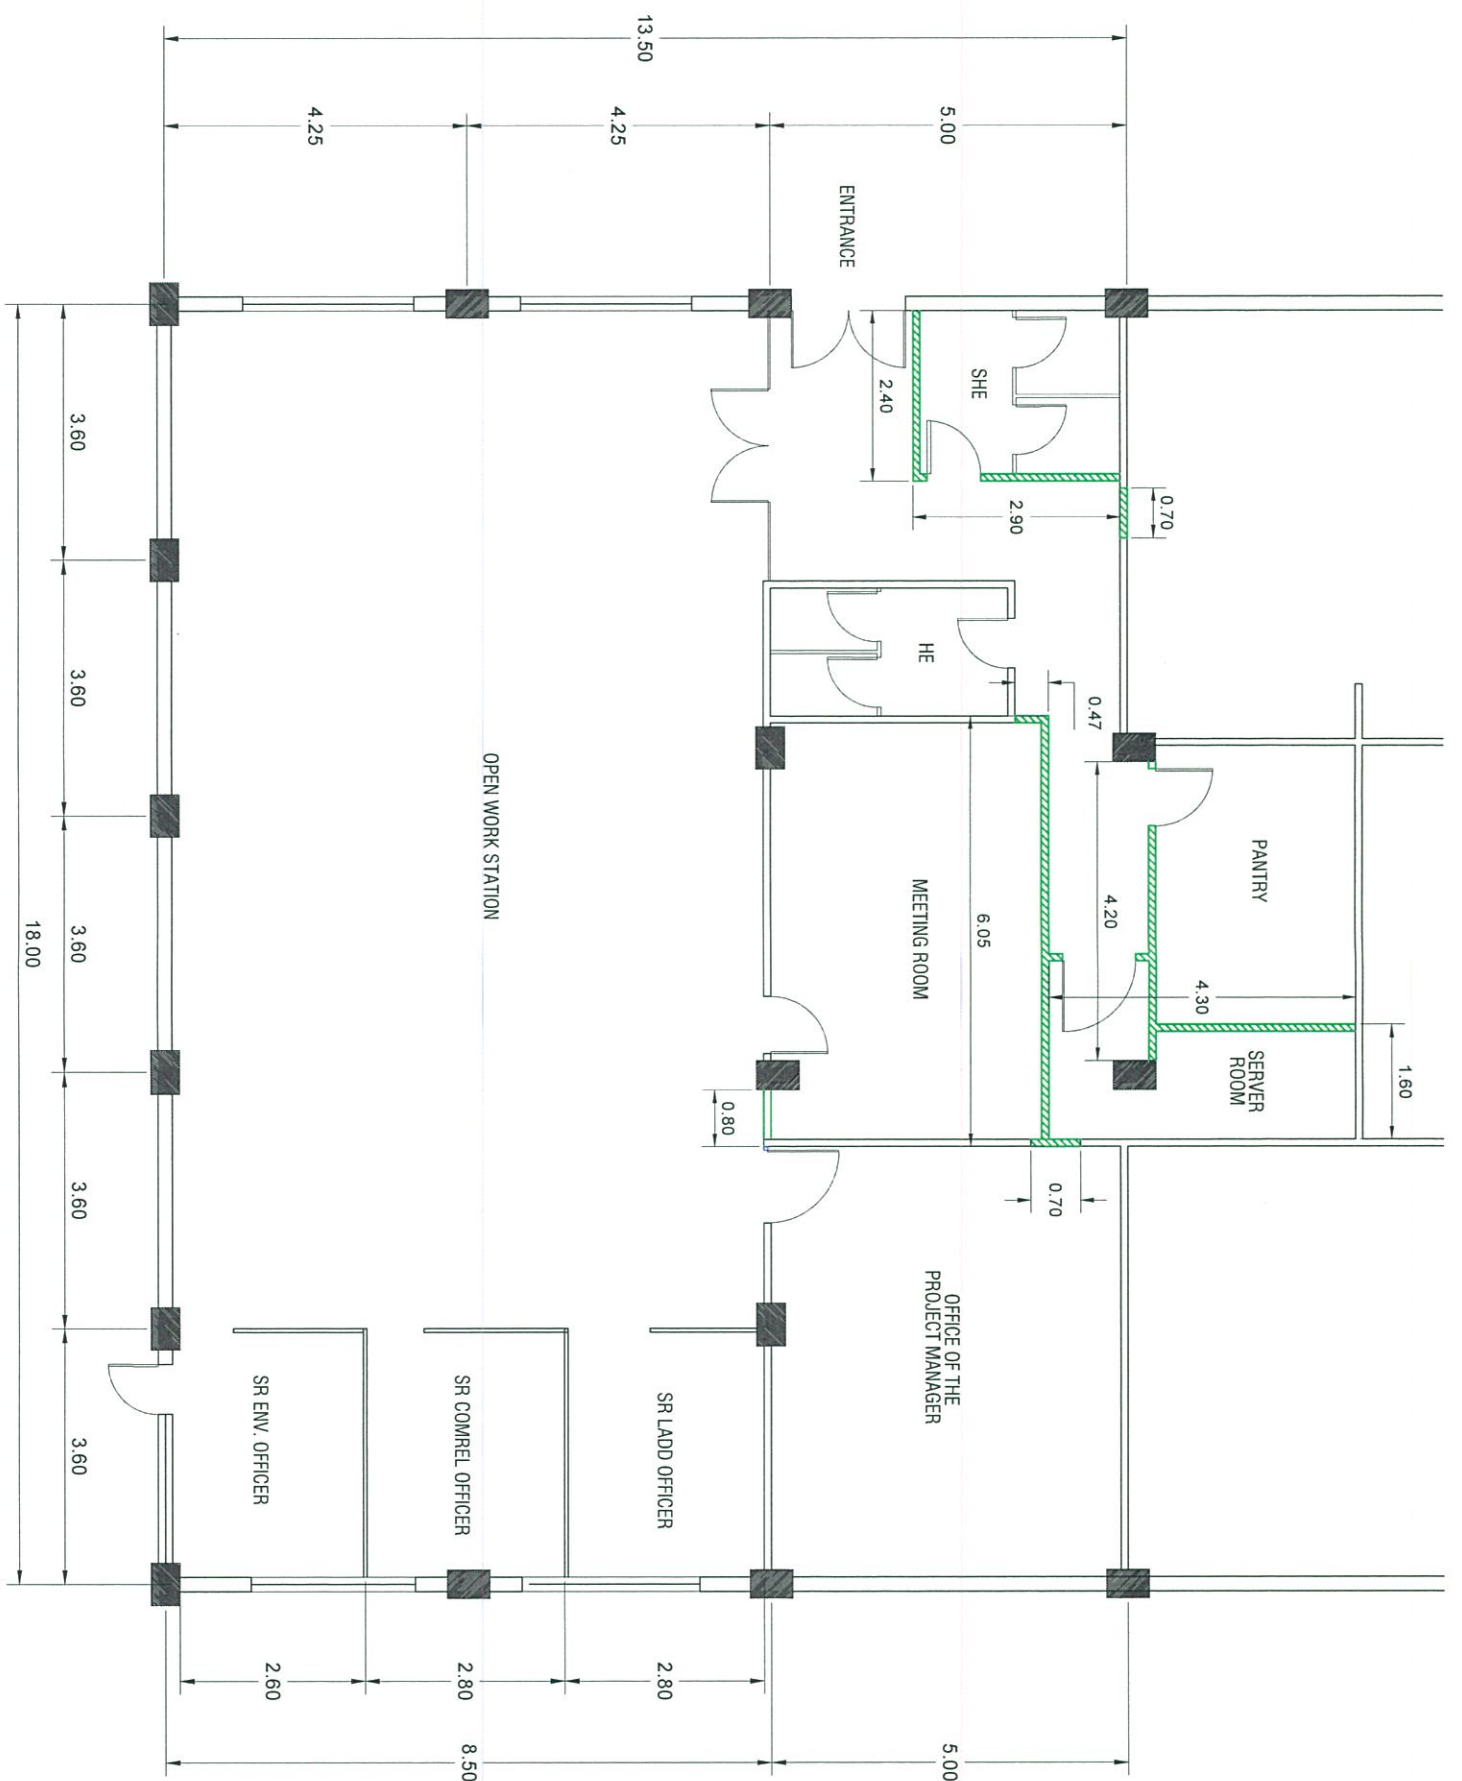

NOTE: 16mm THK GYPSUM BOARD WITH INSULATION (1 HOUR Rating)
 A=111.90 m²




PROJECT NAME PROPOSED SCRP OFFICE CLARK FREE PORT ZONE, PAMPANGA	PREPARED BY JUDENE G. LAGOS NCT/MO	CHECKED & REVIEWED BY REN S. LIM PROJECT MANAGER, SCRP	RECOMMENDING APPROVAL ALLEN ANTONIO EXECUTIVE VICE PRESIDENT	APPROVED BY VENCENIO B. DIZON PRESIDENT AND CEO	SHEET CONTENT DRY WALL PARTITION PLAN SCALE: 1 : 100 M. DATE: 10-15-2019	SHEET NO. A 02
---	---	---	---	--	---	------------------------------------

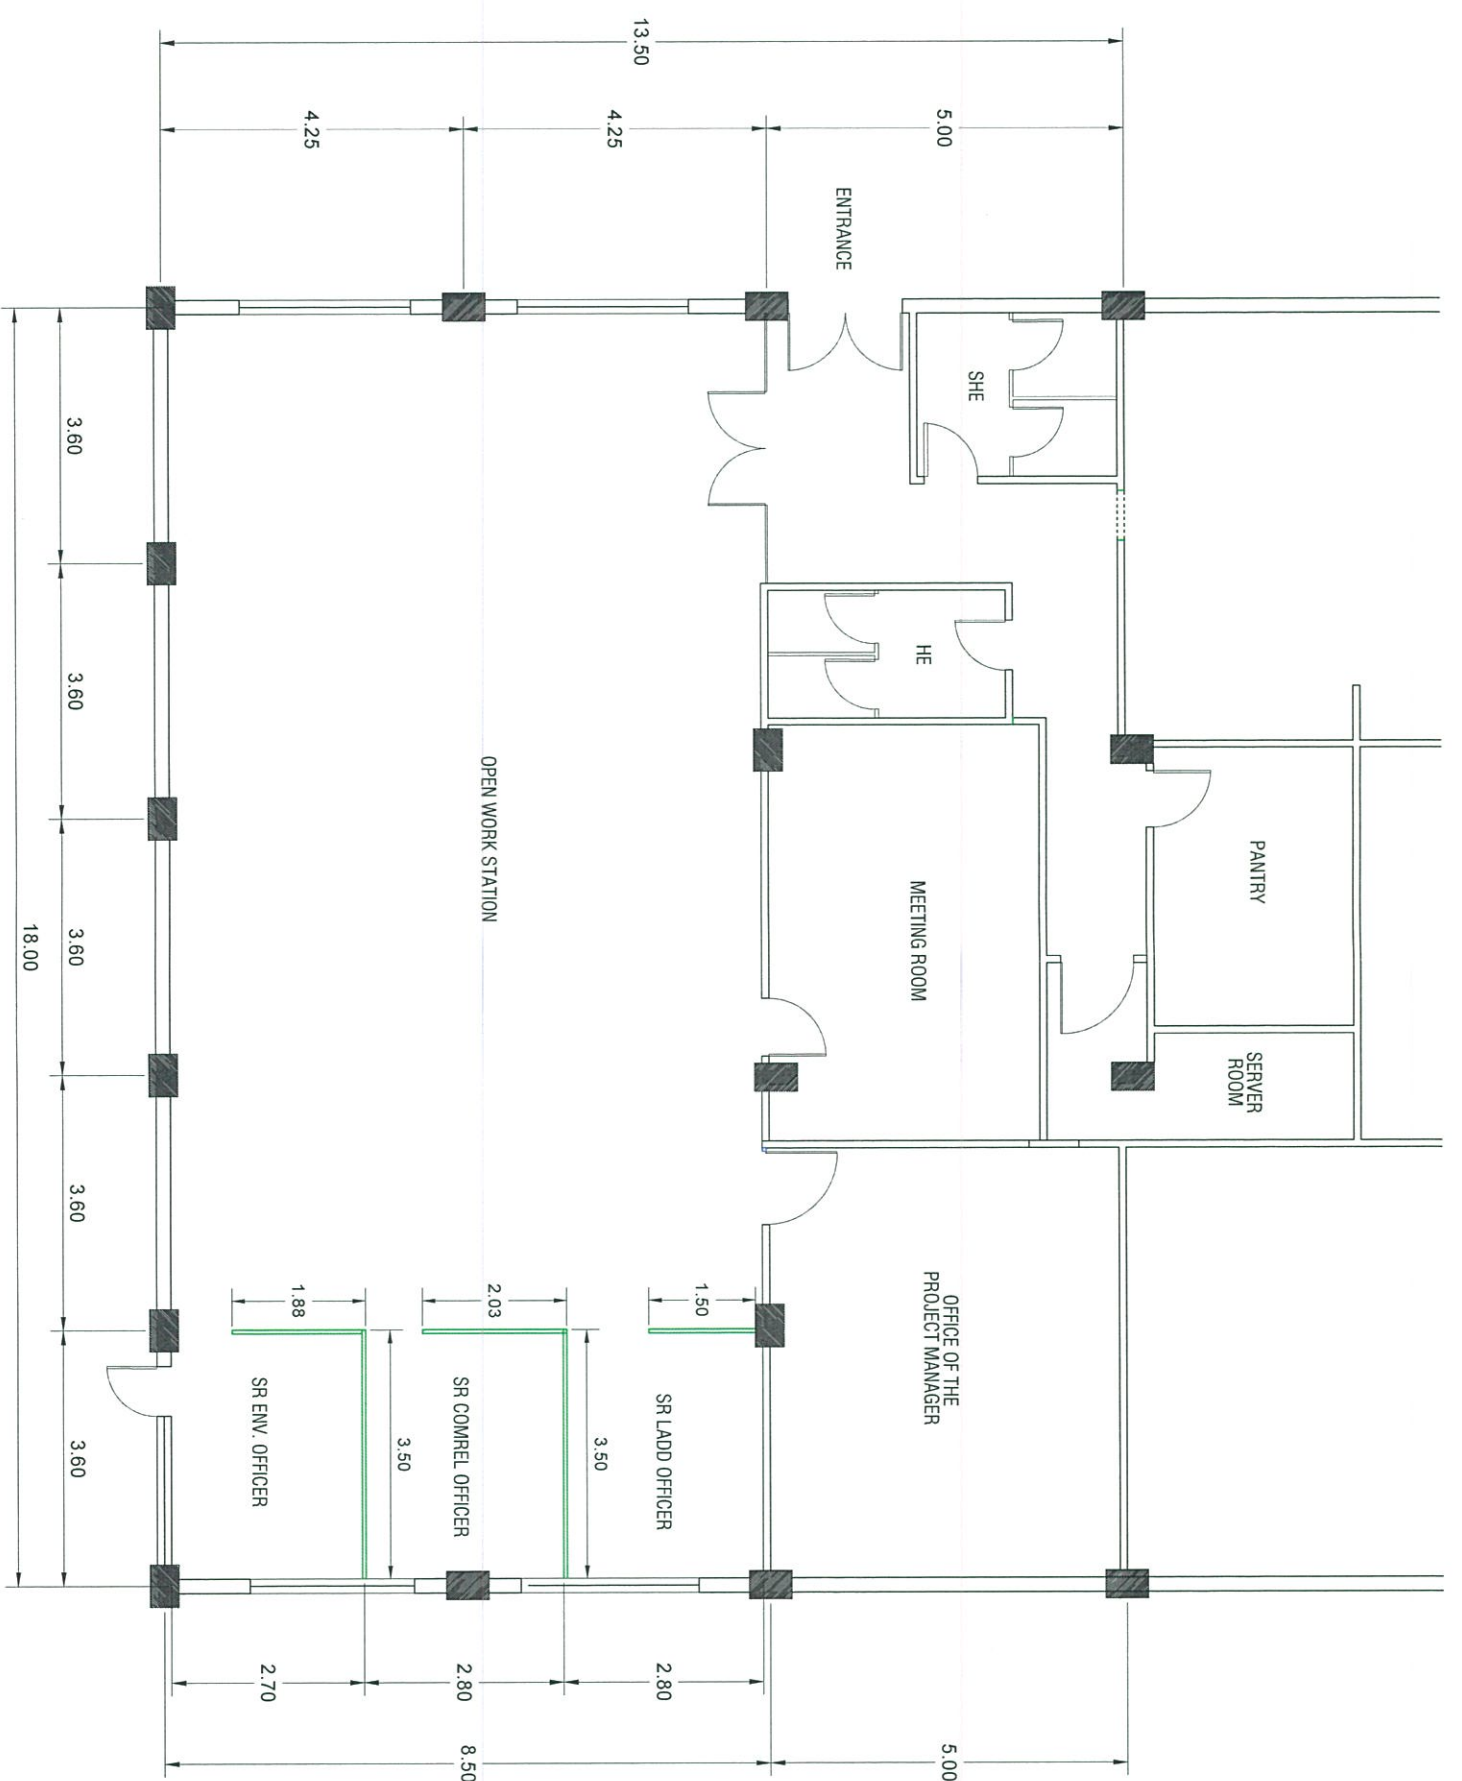

NOTE: 2" x 2" x 3mm STEEL TUBE
 ON HARDIFLEX PANEL
 SPRAY PAINTED FINISH TOP COAT
 COLOR: OFF WHITE




PROJECT NAME PROPOSED SCRP OFFICE CLARK FREE PORT ZONE, PAMPANGA	PREPARED BY JUDENE G. LAGOY NEG-PWD	CHECKED & REVIEWED BY REN S. LIM PROJECT MANAGER, SCRP	RECOMMENDING APPROVAL ALLEEN ANUNCIAACION R. ZOSA EXECUTIVE VICE PRESIDENT	APPROVED BY VIVENCIO B. DIZON PRESIDENT AND CEO	SHEET CONTENT LOW PANEL PARTITION PLAN	SHEET NO. A 03
SCALE 1 : 100 M.	DATE : 10-15-2019					

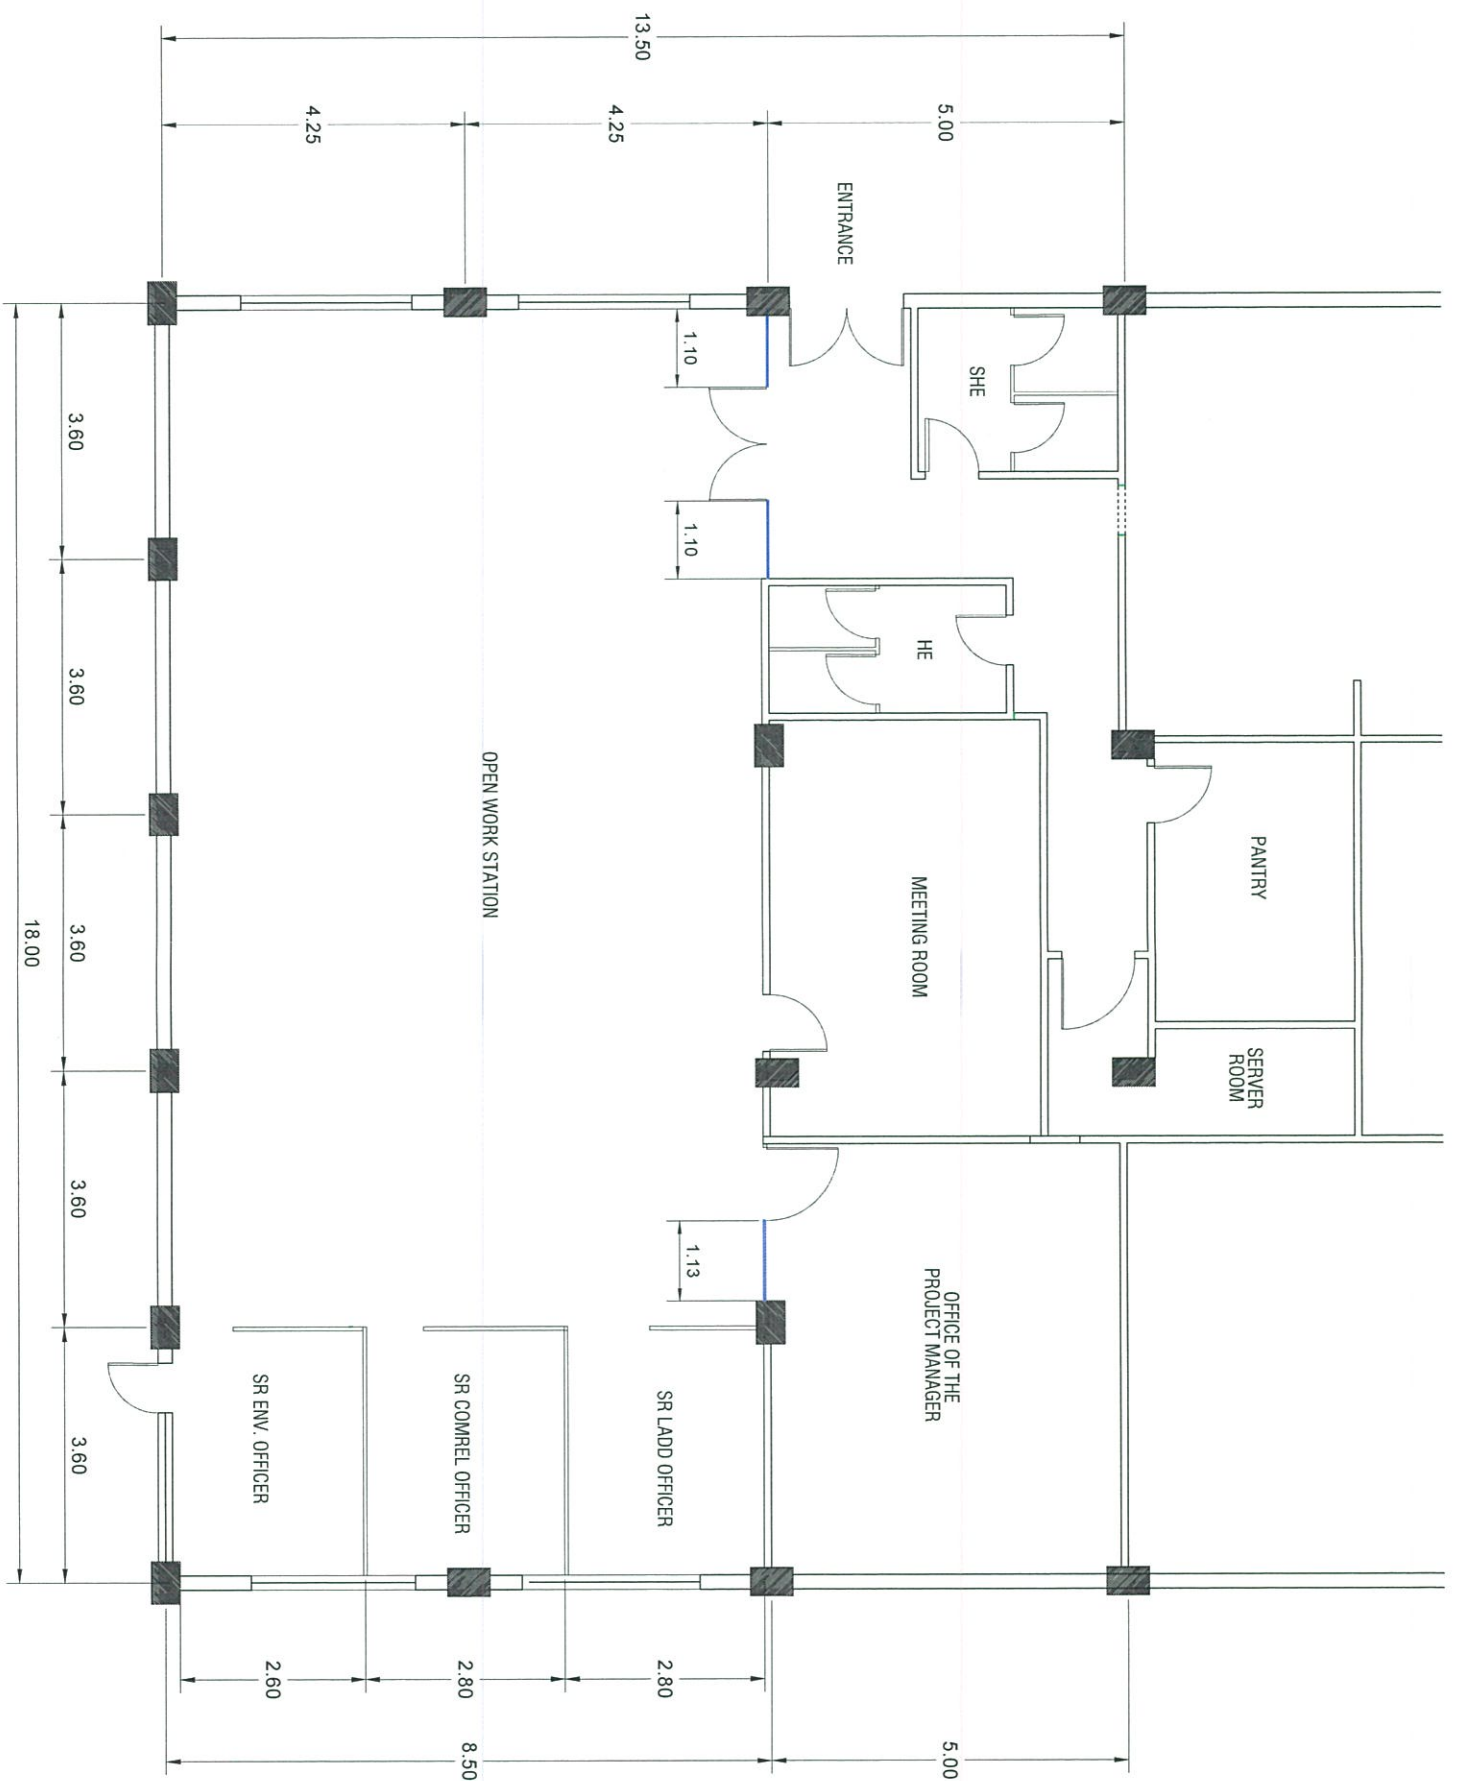

NOTE: 12mm THK. TEMPERED GLASS
FRAMELESS



PROJECT NAME PROPOSED SCRP OFFICE CLARK FREE PORT ZONE, PAMPANGA	PREPARED BY JUDENE G. LAGOY NCC PMO	CHECKED & REVIEWED BY REY S. LIM PROJECT MANAGER, SCRP	RECOMMENDING APPROVAL ALIEN ANUNCIACION R. ZOSA EXECUTIVE VICE PRESIDENT	APPROVED BY VINCENIO B. DIZON PRESIDENT AND CEO	SHEET CONTENT GLASS PARTITION PLAN SCALE: 1:100 M. DATE: 10-15-2019	SHEET NO. A 04
---	--	---	---	--	--	------------------------------------

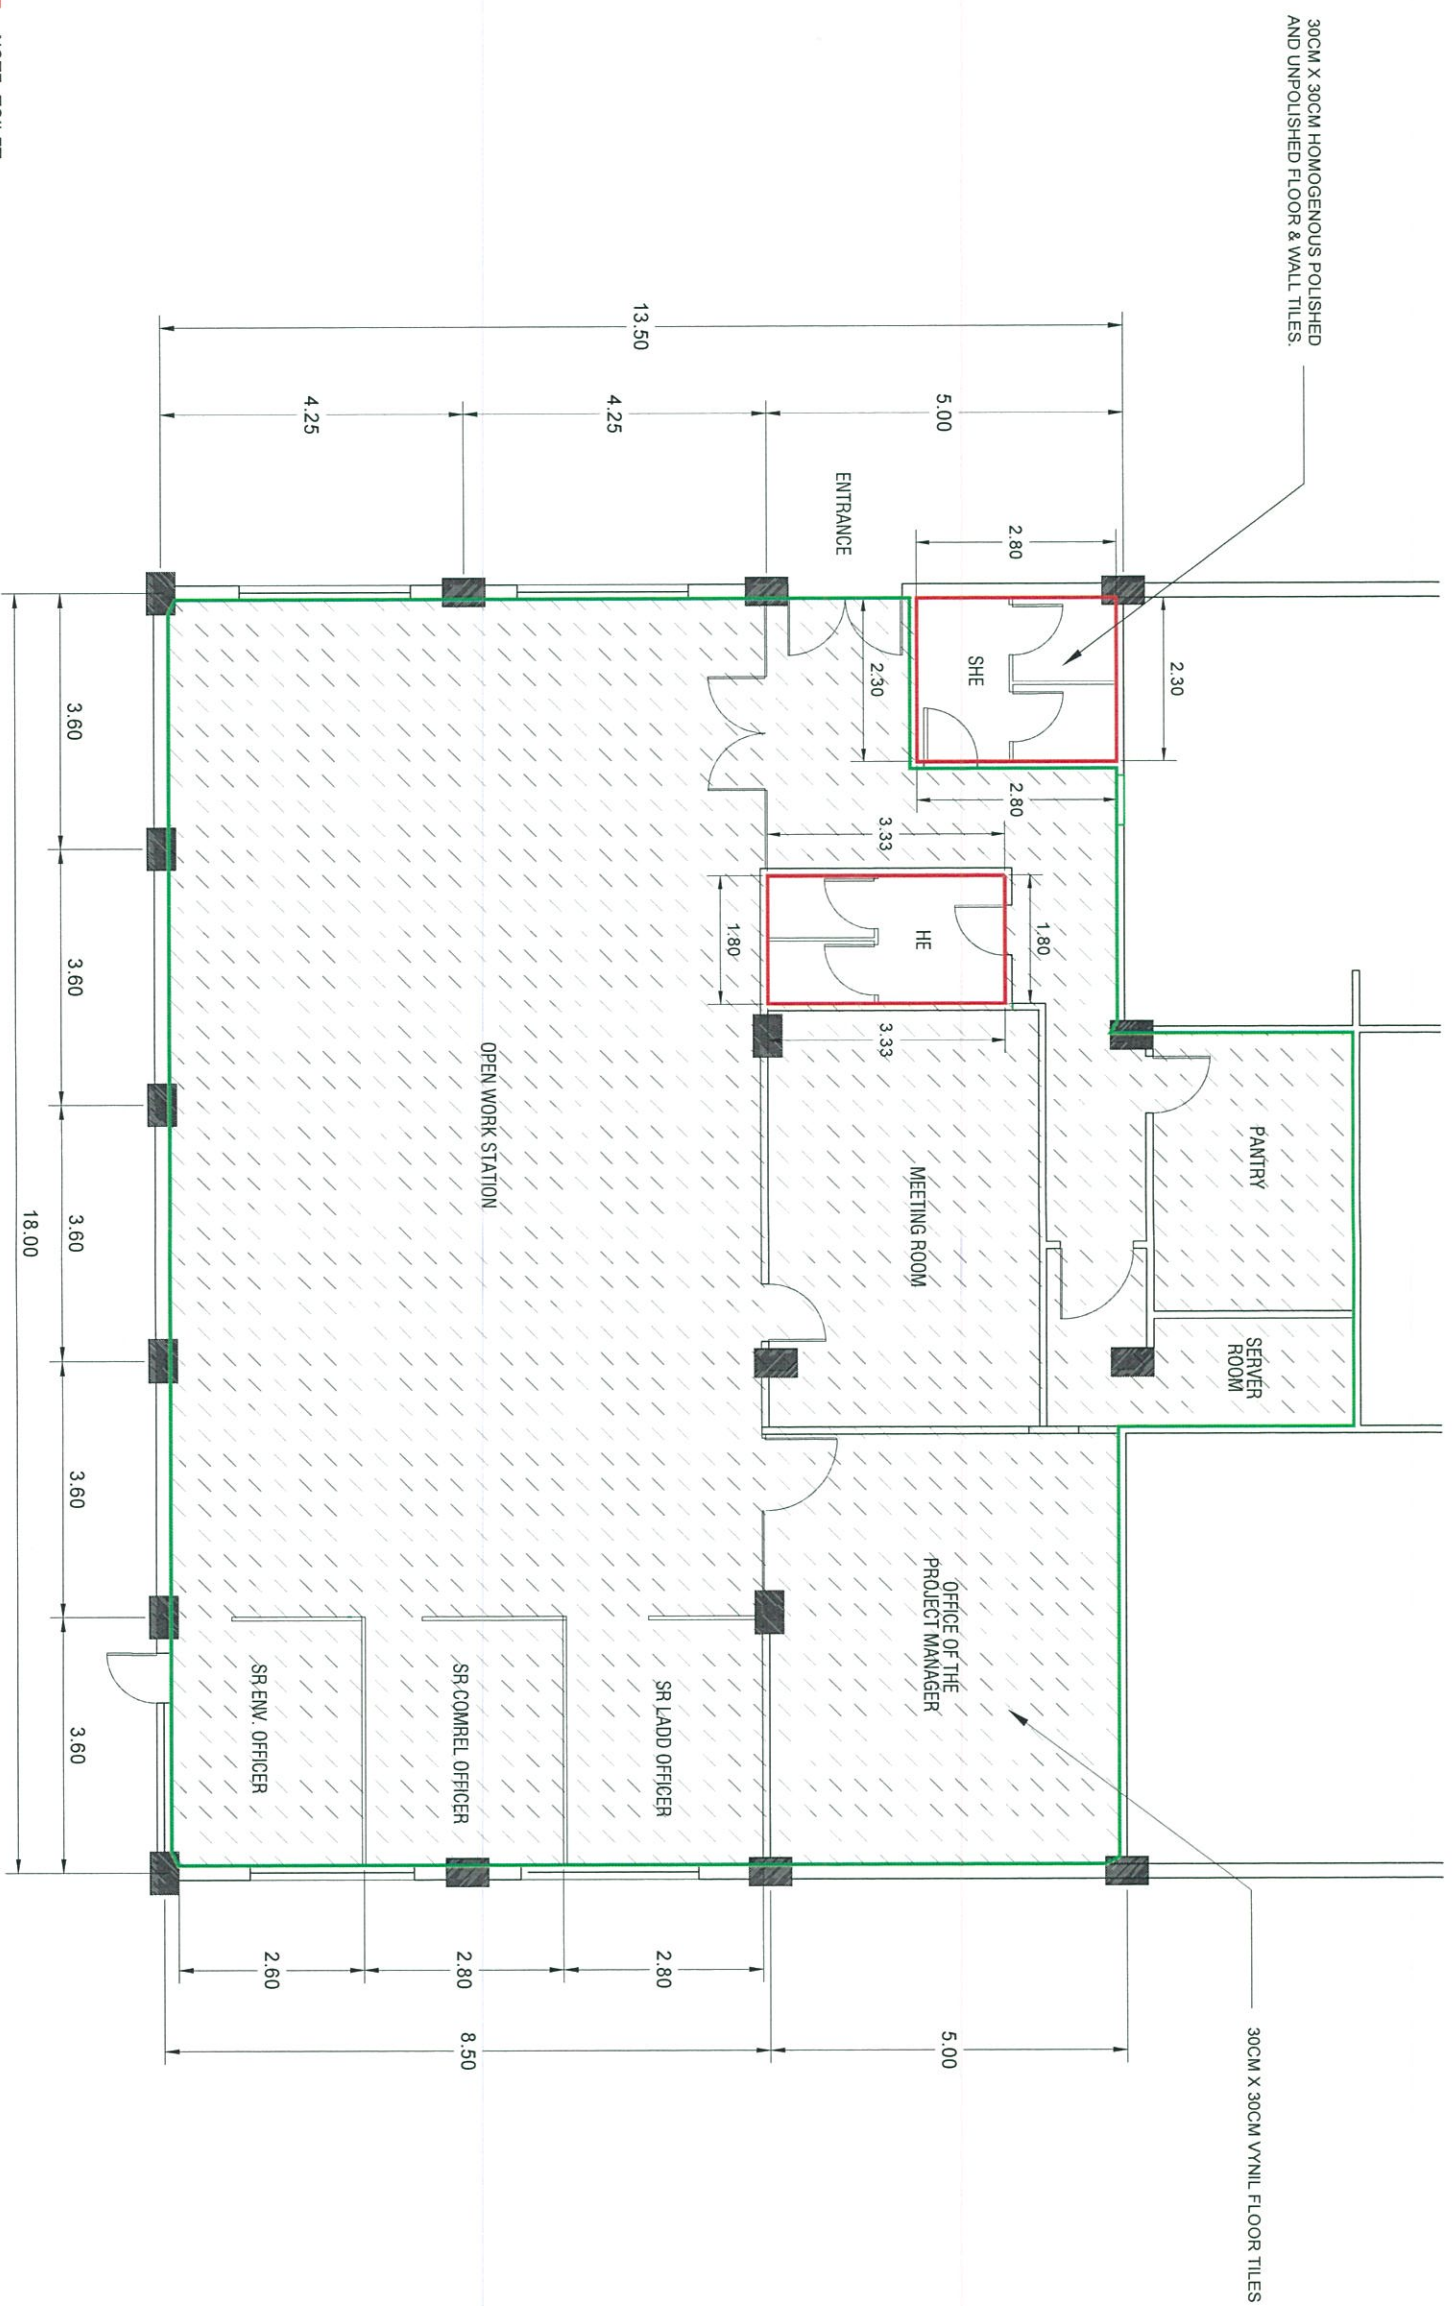

- ▭ NOTE: TOILET
- ▭ 30CM X 30CM FLOOR TILES (12.42 M2)
- ▭ 30CM X 30CM WALL TILES (49.44 M2)
- ▭ NOTE: WORKING AREA
- ▭ 30CM X 30CM FLOOR TILES (235 M2)

30CM X 30CM HOMOGENOUS POLISHED AND UNPOLISHED FLOOR & WALL TILES.

30CM X 30CM VYNIL FLOOR TILES



PROJECT NAME
PROPOSED SCRP OFFICE
CLARK FREE PORT ZONE, PAMPANGA

PREPARED BY
JUDENE G. LAGOS
MCC PMO



CHECKED & REVIEWED BY
REY S. LIM
PROJECT MANAGER, SCRP

RECOMMENDING APPROVAL
ALIEEN ANUNCIACION RIZOSA
EXECUTIVE VICE PRESIDENT


APPROVED BY
VENCIO B. DIZON
PRESIDENT AND CEO

SHEET CONTENT
CERAMIC TILES @ TOILET
VYNIL TILES @ WORKING AREA
SCALE 1 : 100 M. DATE : 10-15-2019


SHEET NO.
A
05

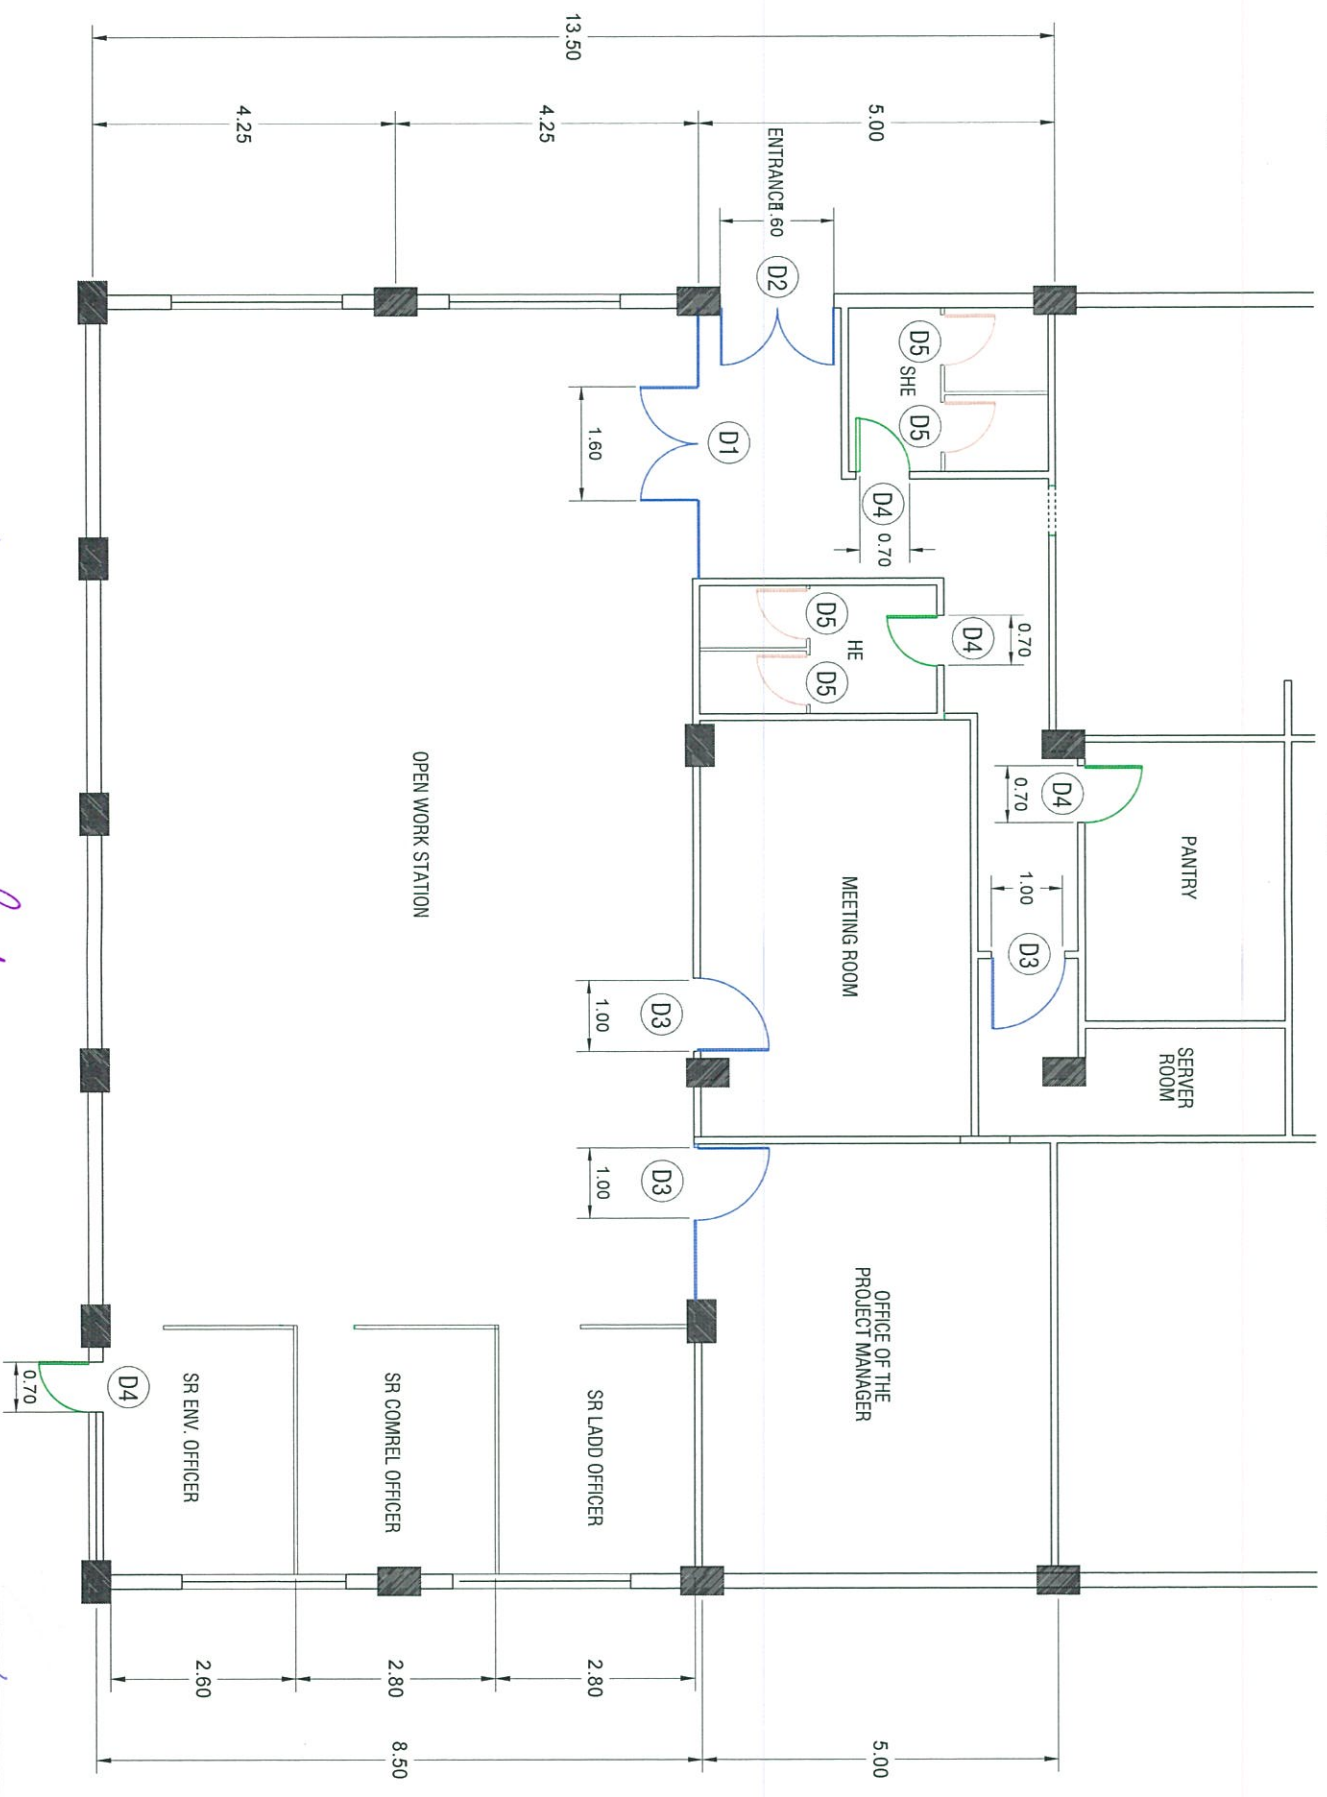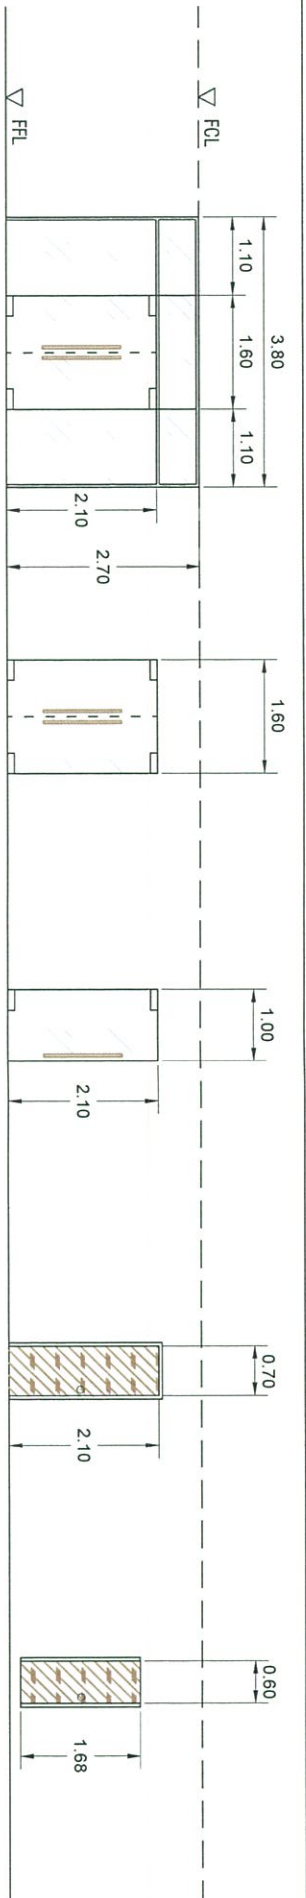

PROJECT NAME PROPOSED SCRP OFFICE CLARK FREE PORT ZONE, PAMPANGA	PREPARED BY JUDENE G. LAGOSY NOC. PMO	CHECKED & REVIEWED BY REY S. LIM PROJECT MANAGER, SCRP	RECOMMENDING APPROVAL ALLEEN ANUNCIACION R. ROSA EXECUTIVE VICE PRESIDENT	APPROVED BY VICENCIO B. DIZON PRESIDENT AND CEO	SHEET CONTENT SCHEDULE OF DOORS & WINDOWS SCALE: 1 : 100 M. DATE: 10-15-2019	SHEET NO. A 06
--	---	--	---	---	--	----------------------

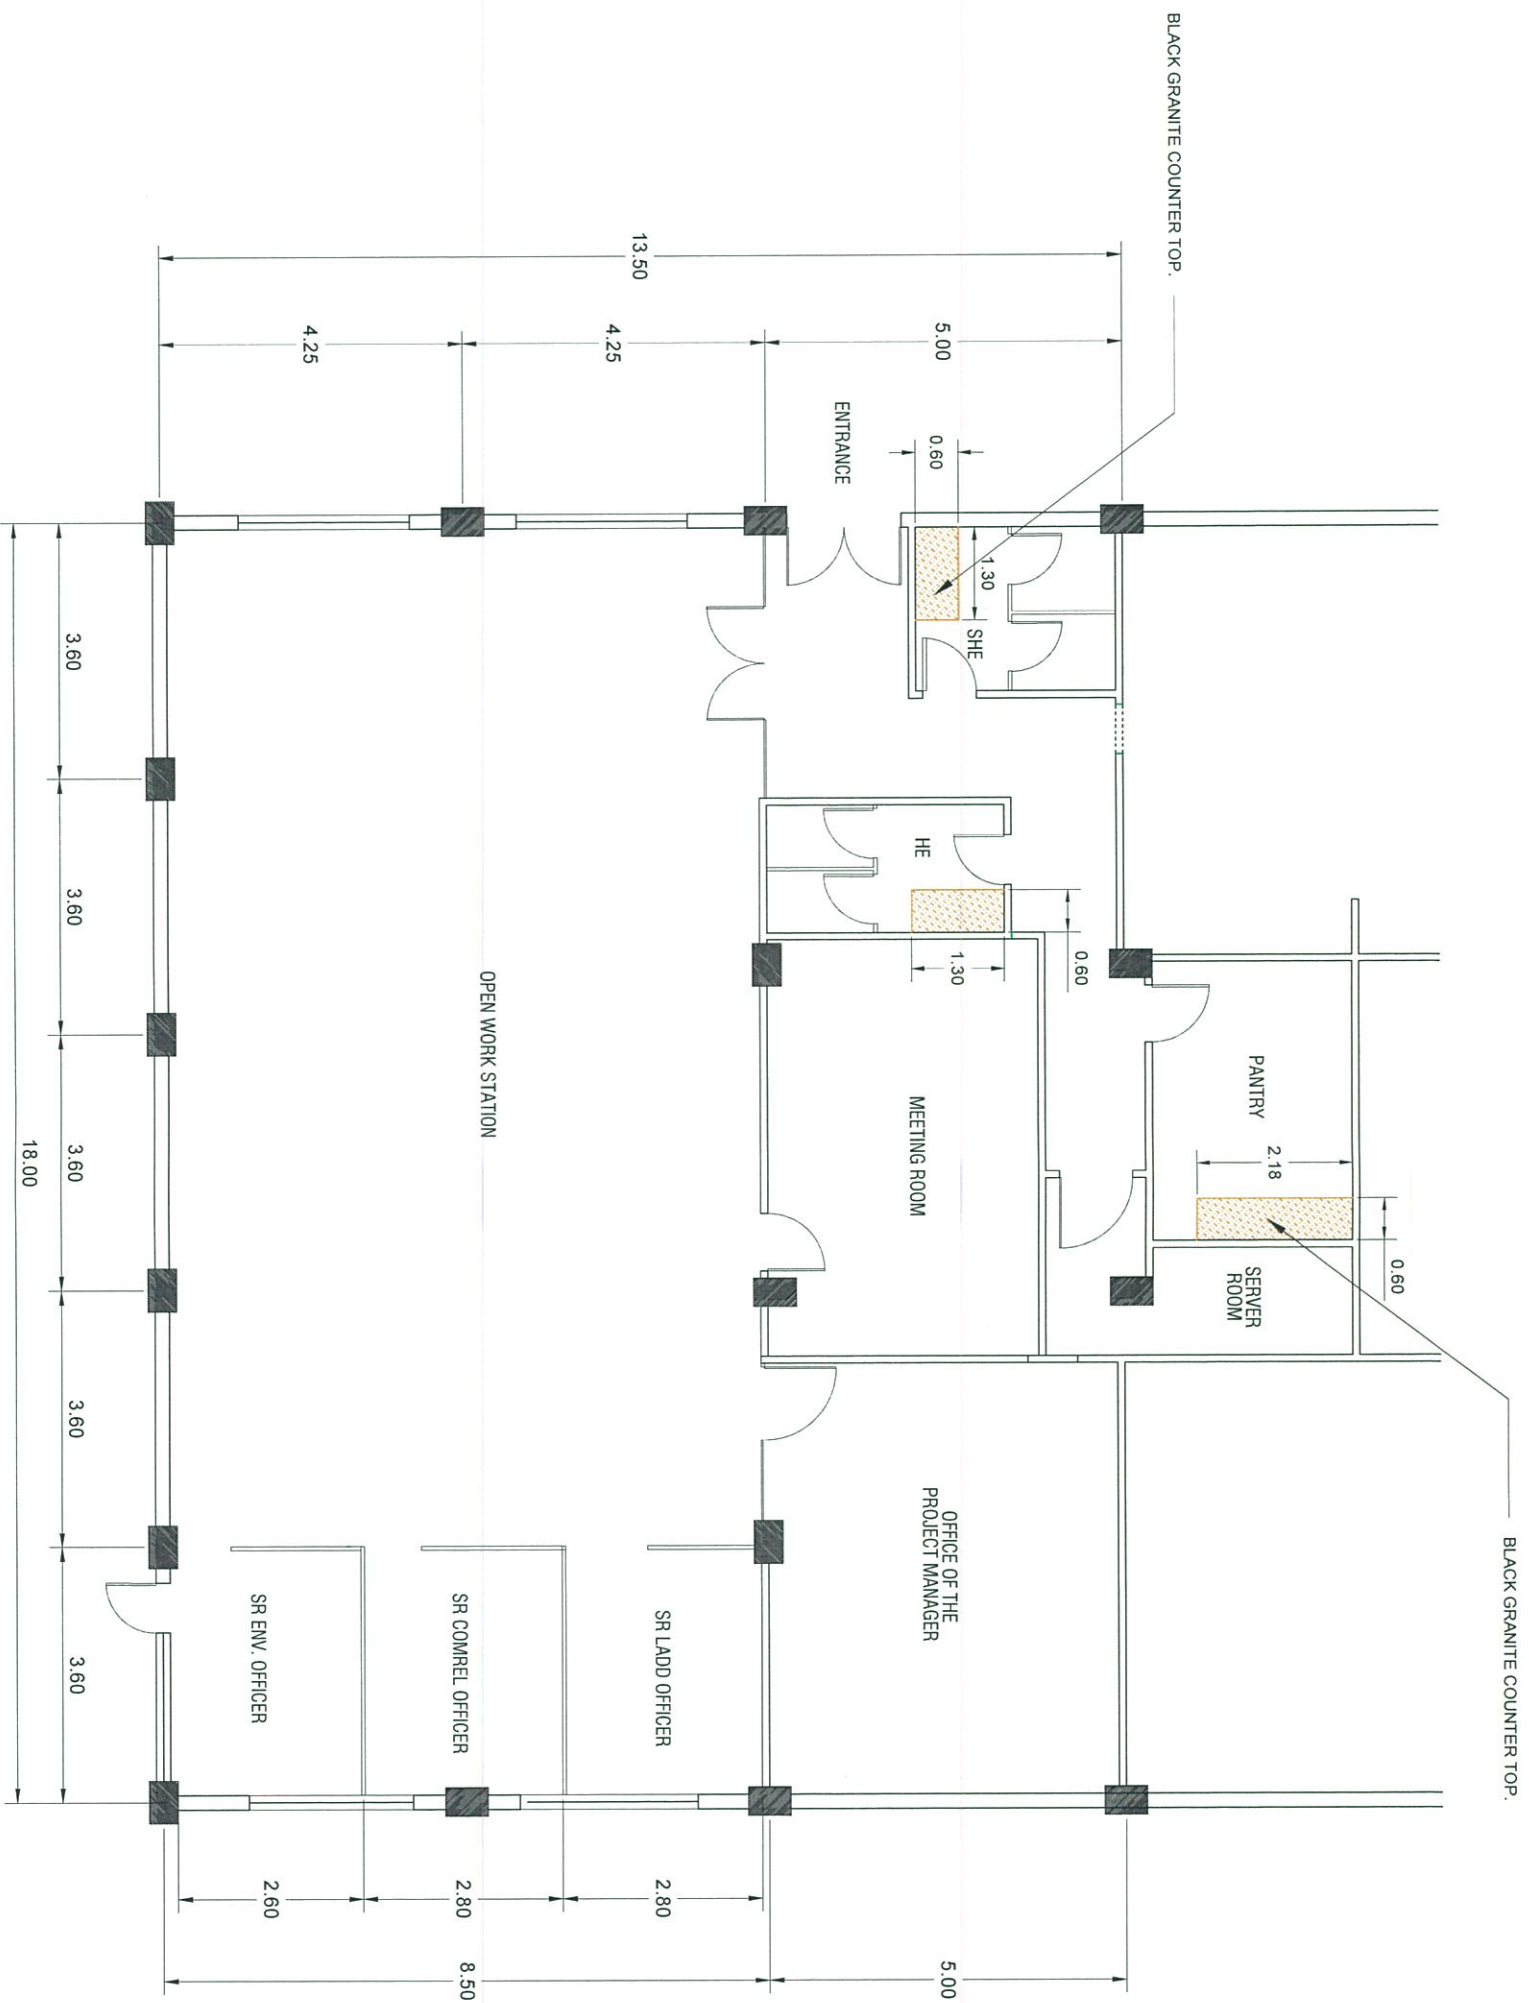

PROJECT NAME	PROPOSED SCRP OFFICE CLARK FREE PORT ZONE, PAMPANGA	PREPARED BY	JUDENE G. TAGOY NCC-PMO	CHECKED & REVIEWED BY	KEY S. LIM PROJECT MANAGER, SCRP	RECOMMENDING APPROVAL	AILEEN ANUNCIACION R. ZOSA EXECUTIVE VICE PRESIDENT	APPROVED BY	VENCIO B. DIZON PRESIDENT AND CEO	SHEET CONTENT	GRANITE COUNTER TOP PLAN SCALE 1 : 100 M. DATE : 10-15-2019	SHEET NO.	A 07
--------------	--	-------------	----------------------------	-----------------------	-------------------------------------	-----------------------	--	-------------	--------------------------------------	---------------	--	-----------	---------

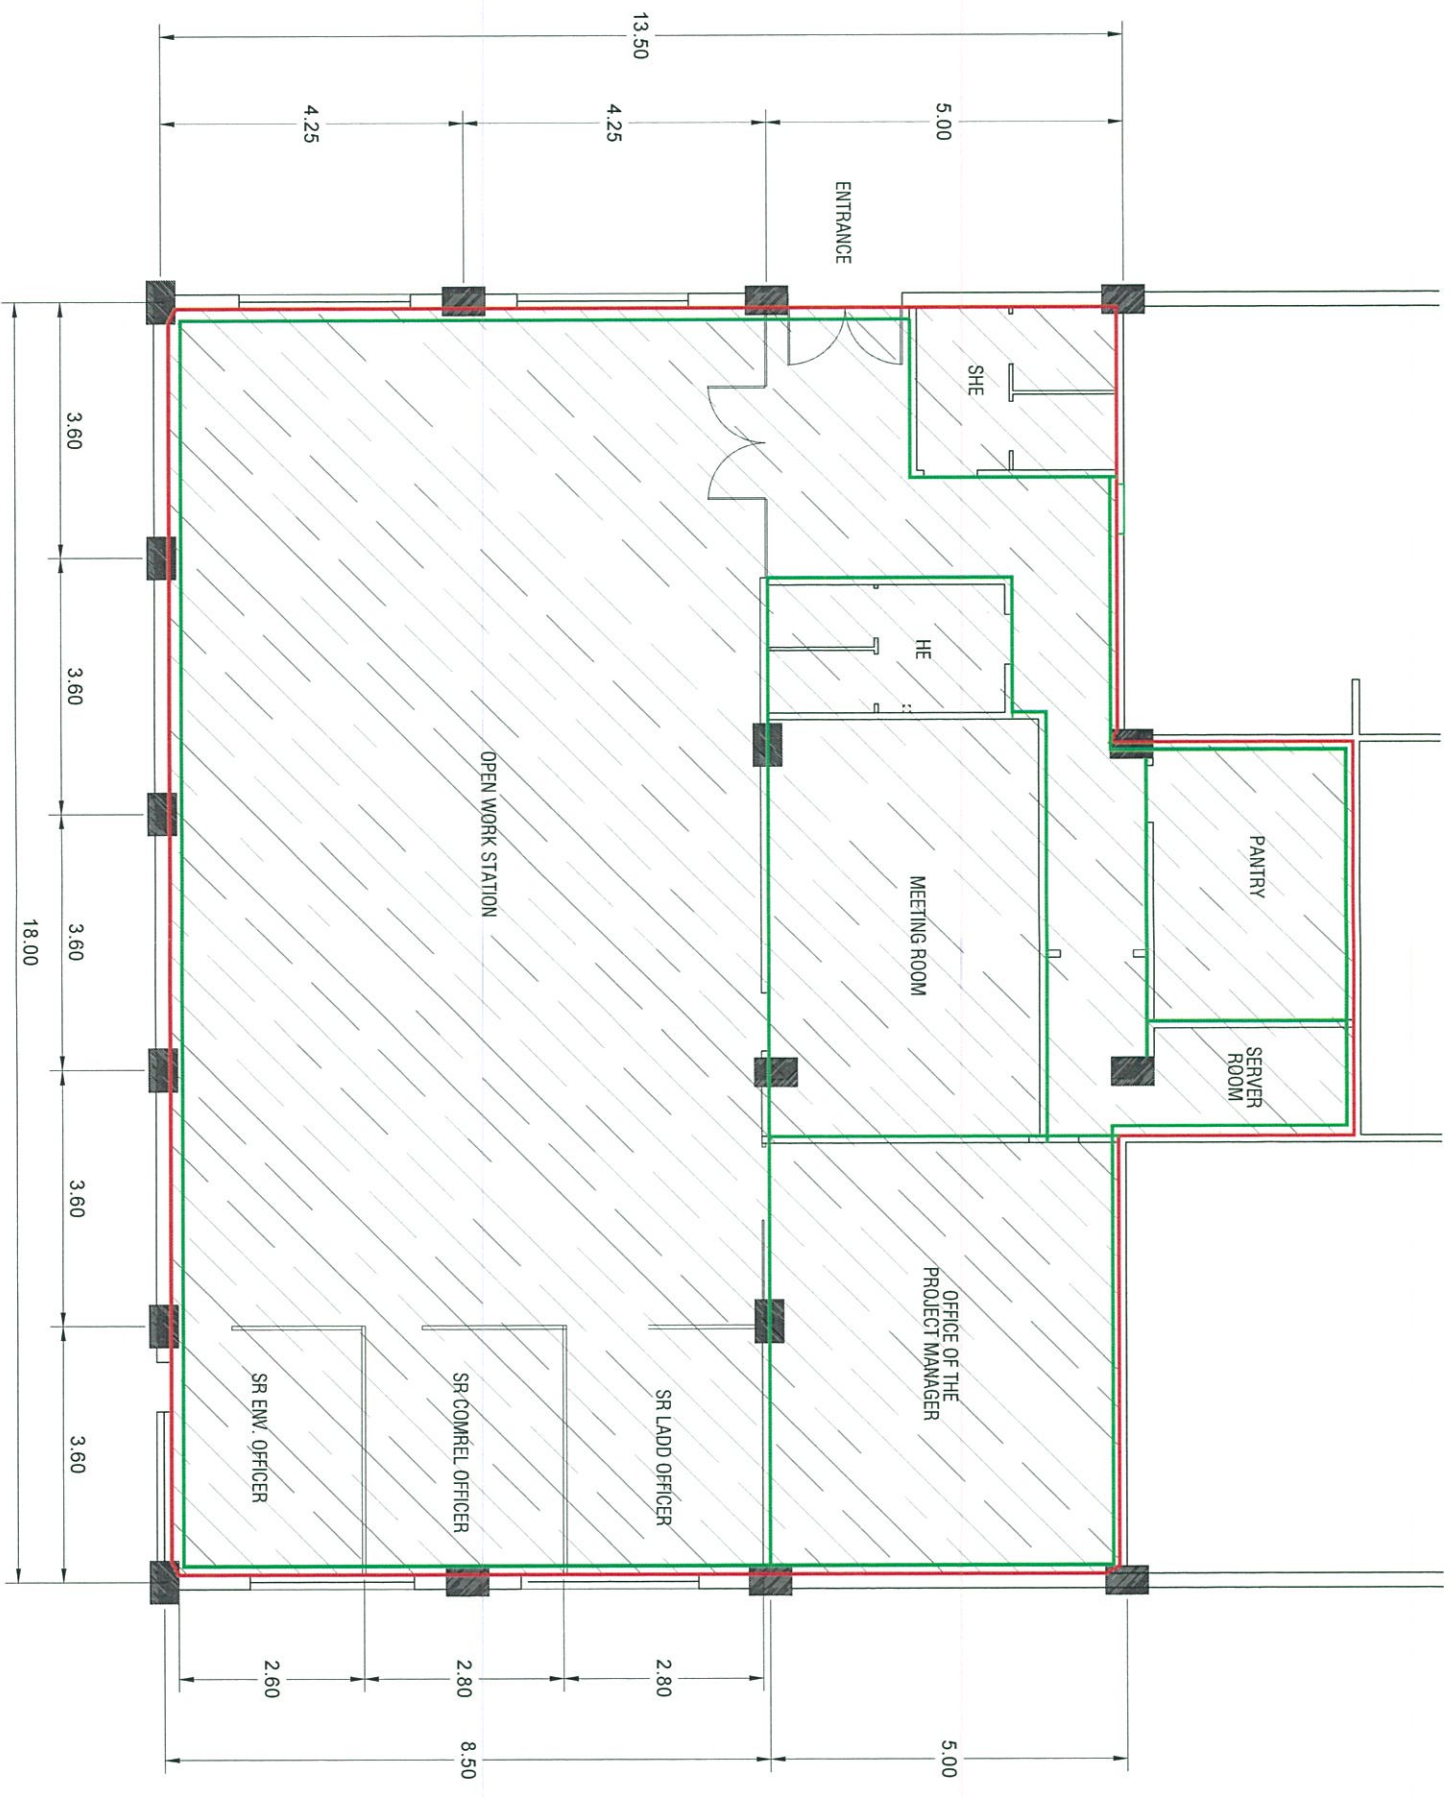


NOTE: PAINTING WORKS

- ▬ CEILING - 254 m²
- ▬ WALL - 111.90 m²




<p>PROJECT NAME PROPOSED SCRP OFFICE CLARK FREE PORT ZONE, PAMPANGA</p>	<p>PREPARED BY <i>Jude G. Lagoy</i> JUDENE G. LAGOY NCTMIO</p>	<p>CHECKED & REVIEWED BY <i>Rey S. Lim</i> REY S. LIM PROJECT MANAGER, SCRP</p>	<p>RECOMMENDING APPROVAL <i>Aileen Anunciacion R. Zosa</i> AILEEN ANUNCIACION R. ZOSA EXECUTIVE VICE PRESIDENT</p>	<p>APPROVED BY <i>Vivencio B. Dizon</i> VIVENCIO B. DIZON PRESIDENT AND CEO</p>	<p>SHEET CONTENT PAINTING WORKS PLAN</p> <p>SCALE: 1 : 100 M. DATE: 10-15-2019</p>	<p>SHEET NO. A 08</p>
--	---	--	---	--	--	---

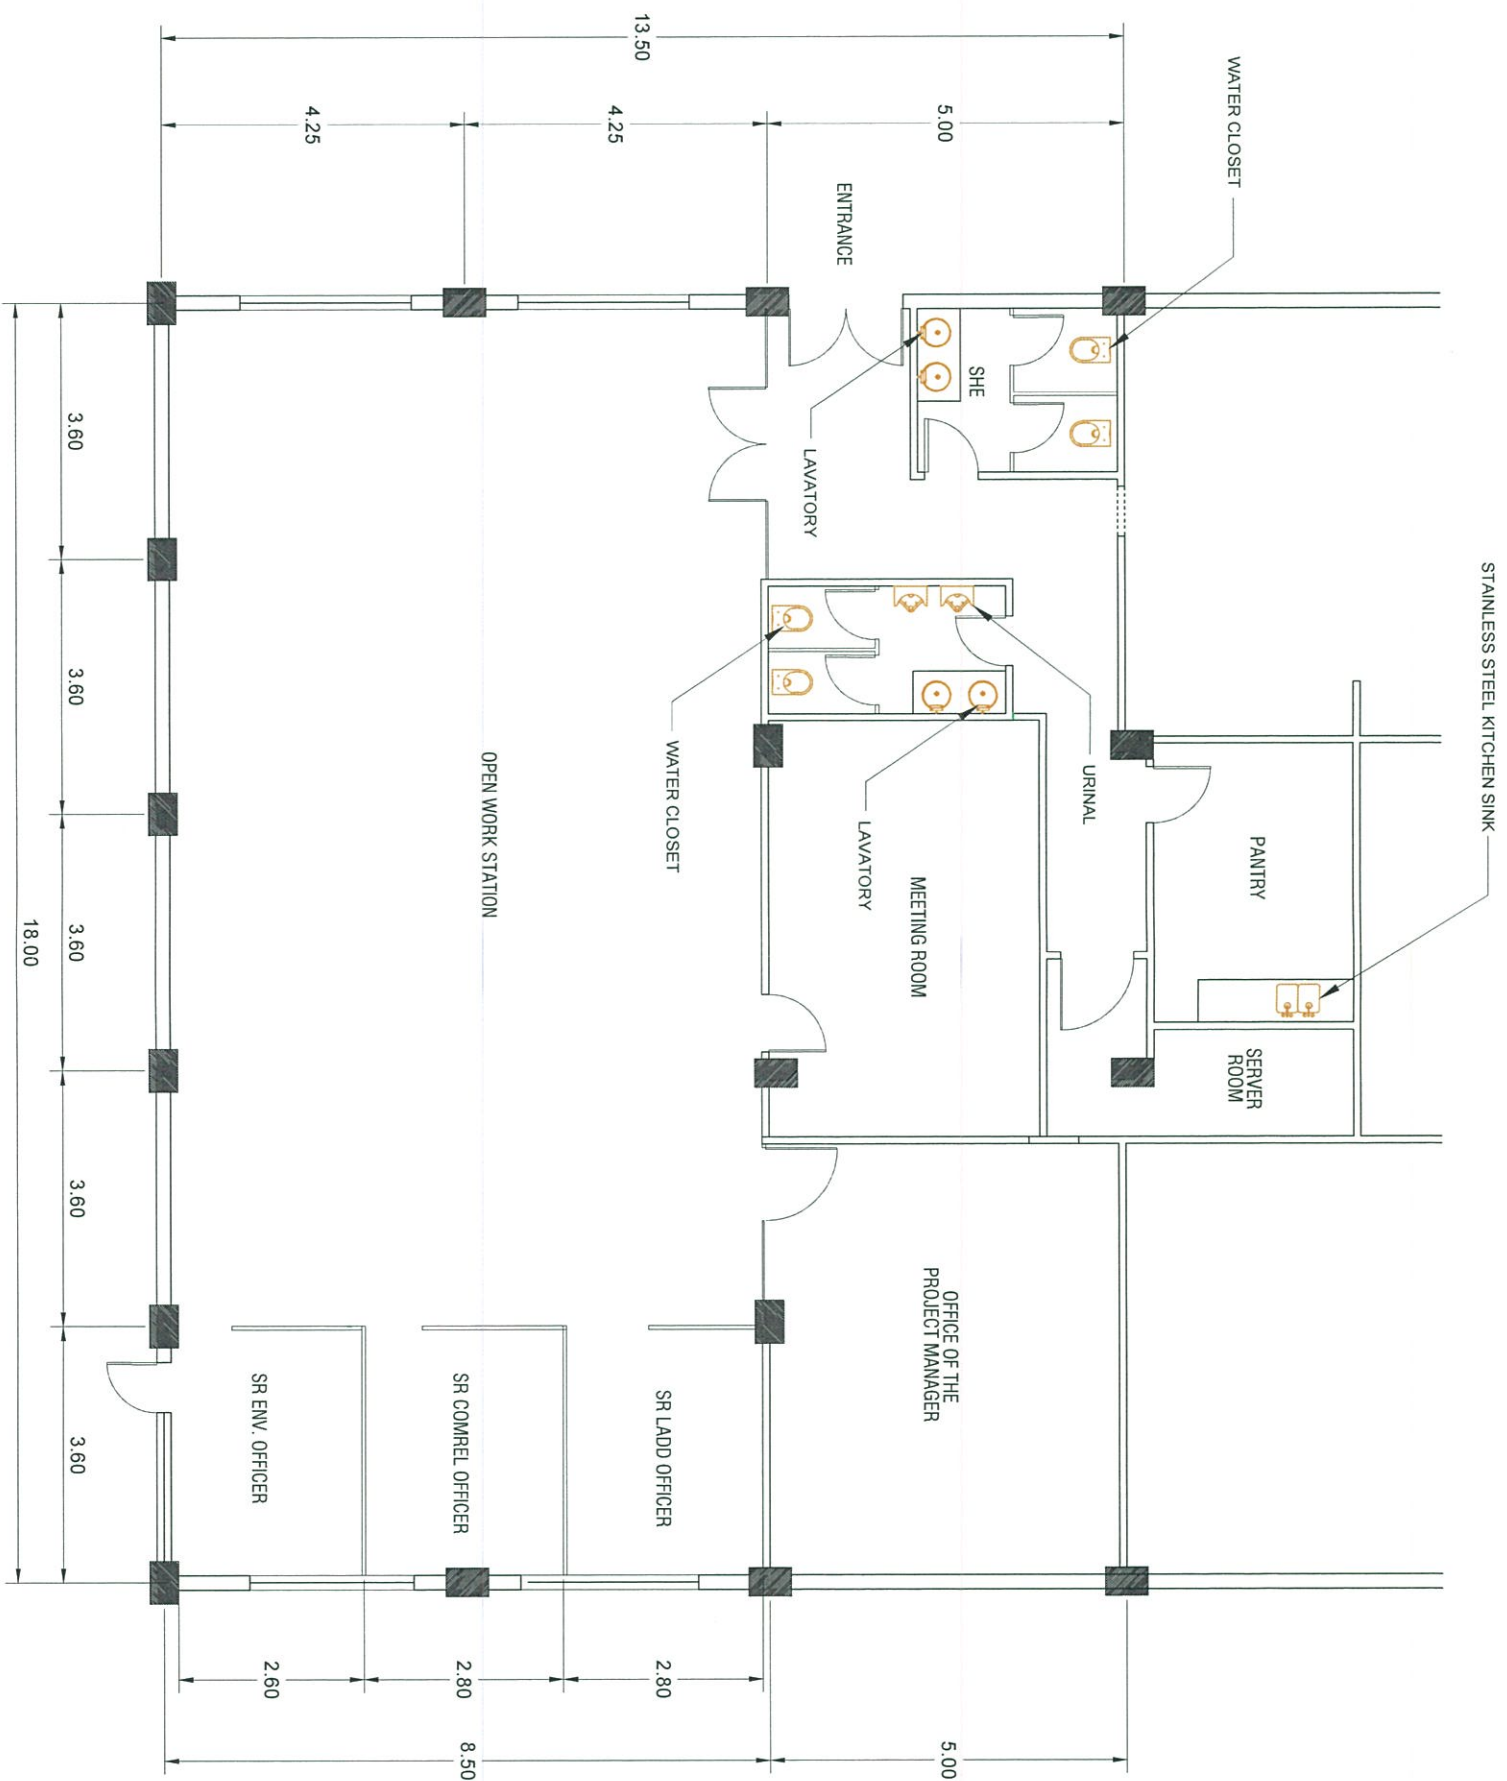


NOTE: 4 SET WATER CLOSET
 4 SET LAVATORY
 2 SET URINAL
 1 SET KITCHEN SINK (DOUBLE)




PROJECT NAME PROPOSED SCRP OFFICE CLARK FREE PORT ZONE, PAMPANGA	PREPARED BY JUDENE G. LAGAY NCC-FMG	CHECKED & REVIEWED BY HEX S. LIM PROJECT MANAGER, SCRP	RECOMMENDING APPROVAL ALLEEN ANUNCIACION R. ROSA EXECUTIVE VICE PRESIDENT	APPROVED BY VINCENIO B. DIZON PRESIDENT AND CEO	SHEET CONTENT PLUMBING FIXTURES PLAN SCALE 1:100 M. DATE: 10-15-2019	SHEET NO. A 09
--	---	--	---	---	--	----------------------



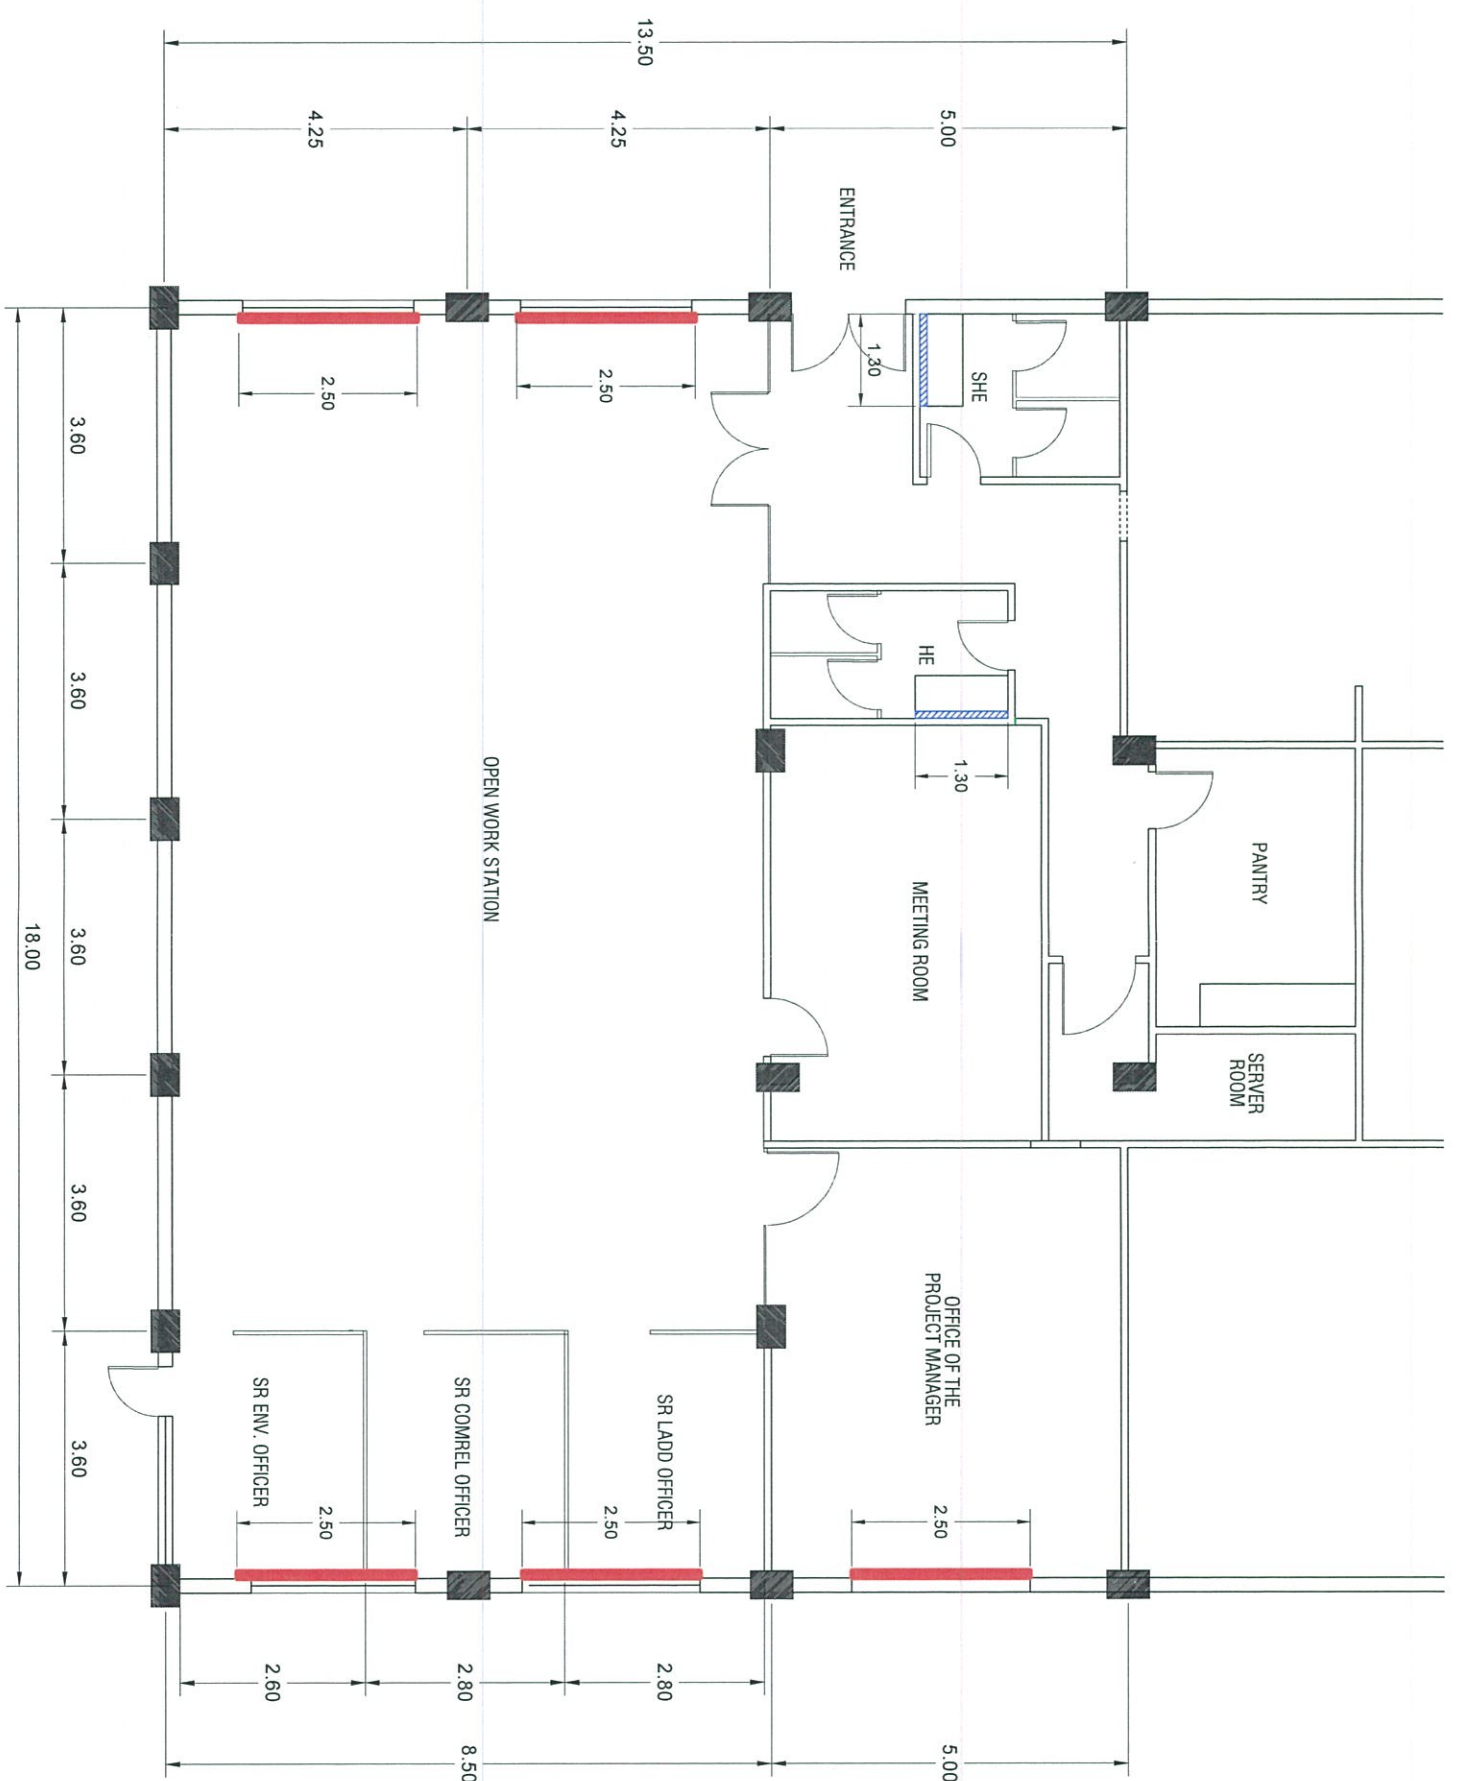


- 5 SET WINDOW BLINDS (ROLL UP)
- 2 PCS. CLEAR GLASS FRAMELESS MIRROR

 <p>BCDA Bases Conversion and Development Authority</p>	<p>PROJECT NAME PROPOSED SCRP OFFICE CLARK FREE PORT ZONE, PAMPANGA</p>	<p>PREPARED BY <i>Judene G. Lagoy</i> JUDENE G. LAGOY NCC PMO</p>	<p>CHECKED & REVIEWED BY <i>Rens Lim</i> RENS LIM PROJECT MANAGER, SCRP</p>	<p>RECOMMENDING APPROVAL <i>Alleen Anunciacion R. Zosa</i> ALLEEN ANUNCIACION R. ZOSA EXECUTIVE VICE PRESIDENT</p>	<p>APPROVED BY <i>Vencio B. Dizon</i> VENCIO B. DIZON PRESIDENT/AND CEO</p>
<p>SHEET CONTENT WINDOW BLINDS & MIRROR</p>		<p>SCALE 1 : 100 M.</p>		<p>DATE : 10-15-2019</p>	
<p>SHEET NO. A</p>					<p>10</p>


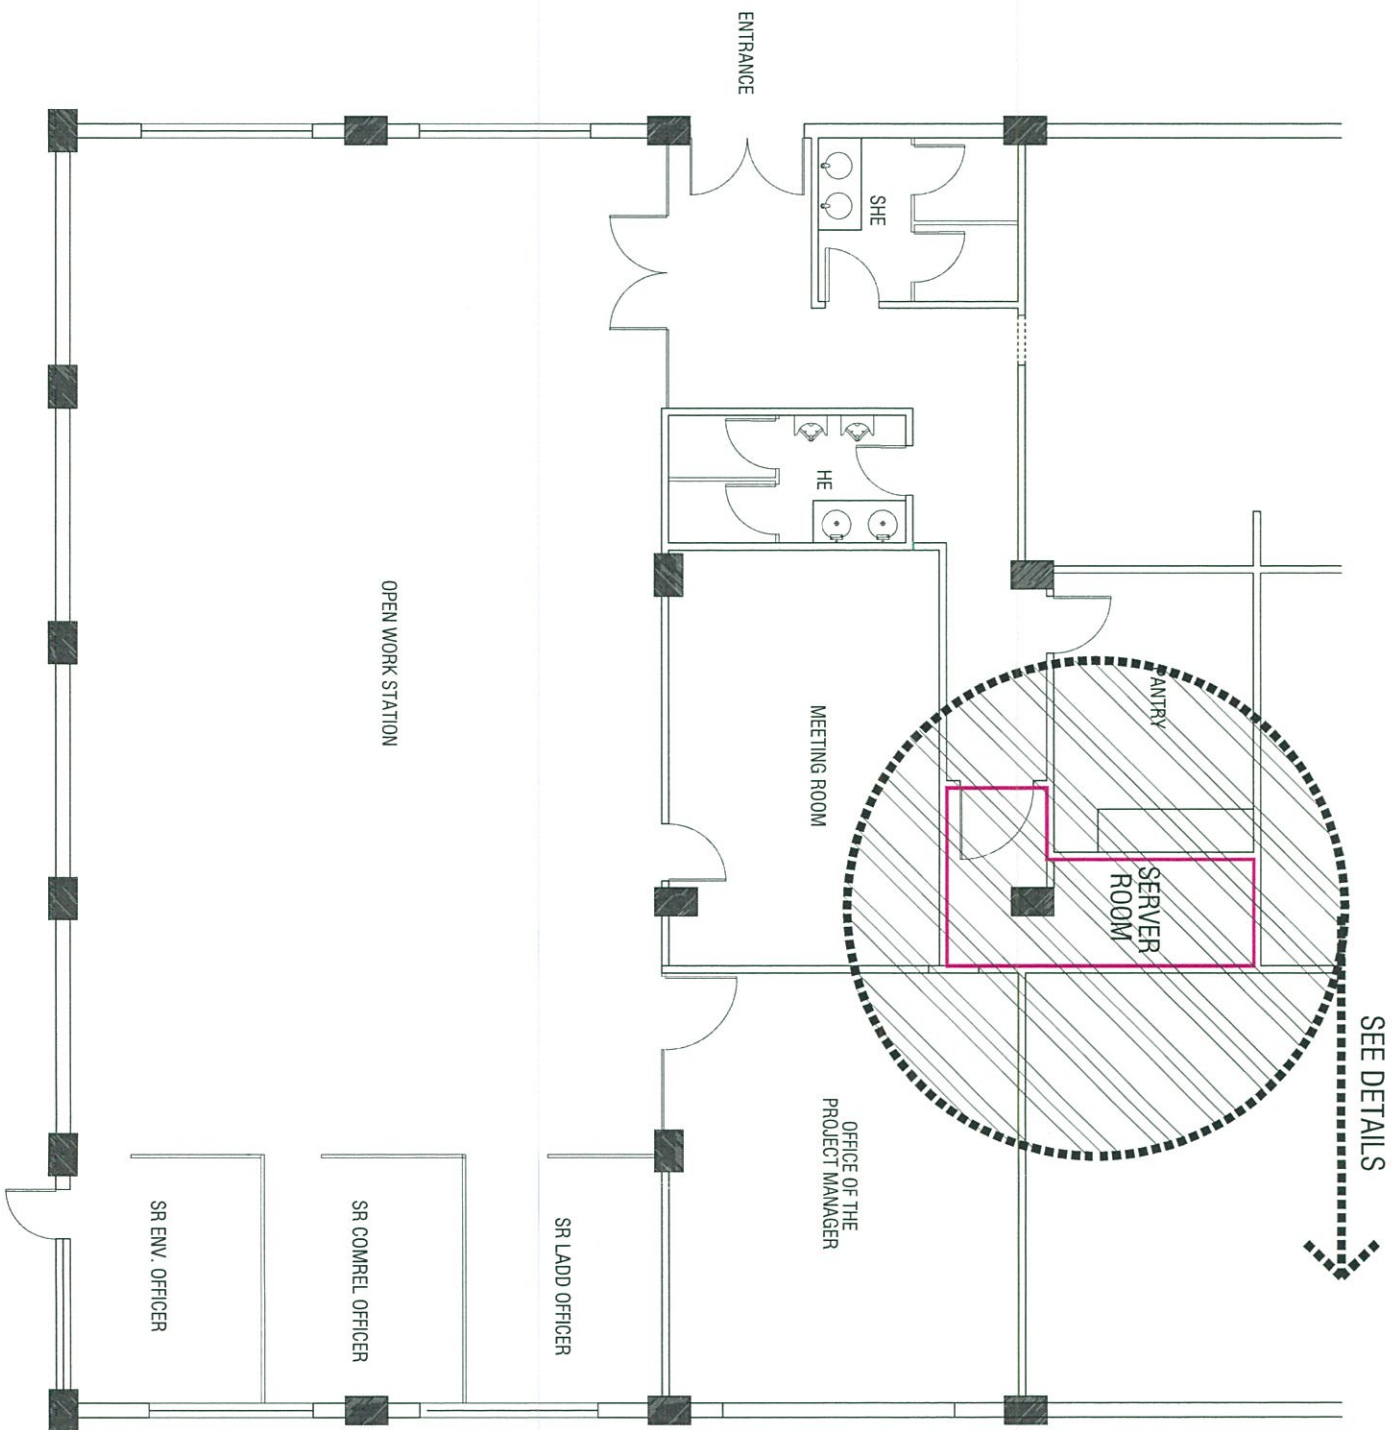


NOTE :NEED AIR-CONDITIONING SYSTEM & FIRE SUPPRESSION
 AT SERVER ROOM
 2 SET, 2HP ACU

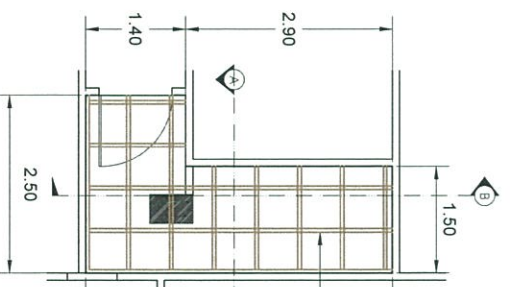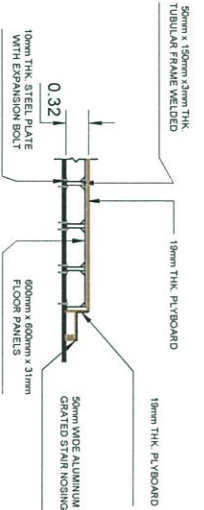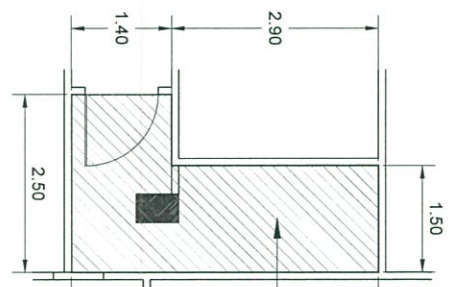

PROJECT NAME PROPOSED SCRP OFFICE AT SERVER ROOM CLARK FREE PORT ZONE, PAMPANGA		PREPARED BY JUDENE G. LAGAY NCC PMO	CHECKED & REVIEWED BY REY S. LIM PROJECT MANAGER, SCRP	RECOMMENDING APPROVAL ALEEN ANUNCIACION R. LOSA EXECUTIVE VICE PRESIDENT	APPROVED BY VICENCIO B. DIZON PRESIDENT AND CEO	SHEET CONTENT SERVER ROOM RAISED FLOOR FIRE SUPPRESSION SYSTEM SCALE 1 : 100 M.	DATE : 10-15-2019	SHEET NO. A 11
--	--	---	--	--	---	--	-------------------	----------------------

[Handwritten signature]

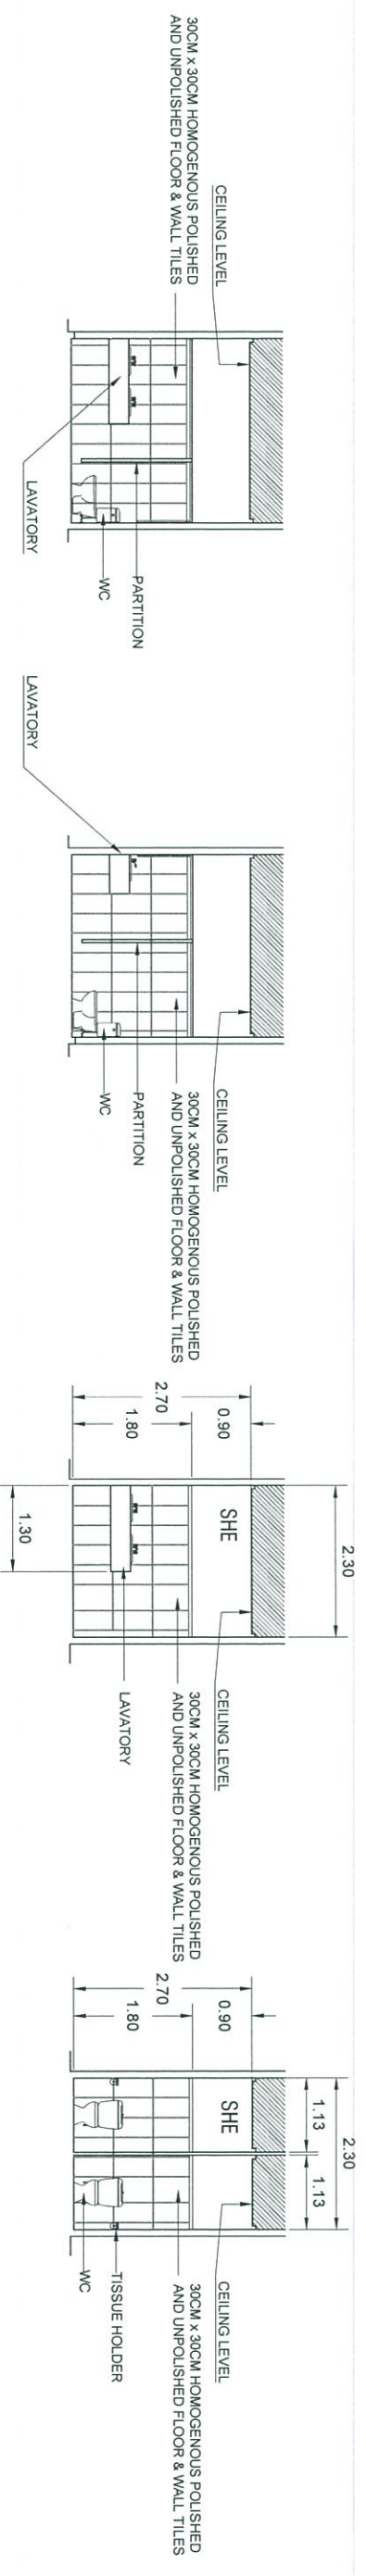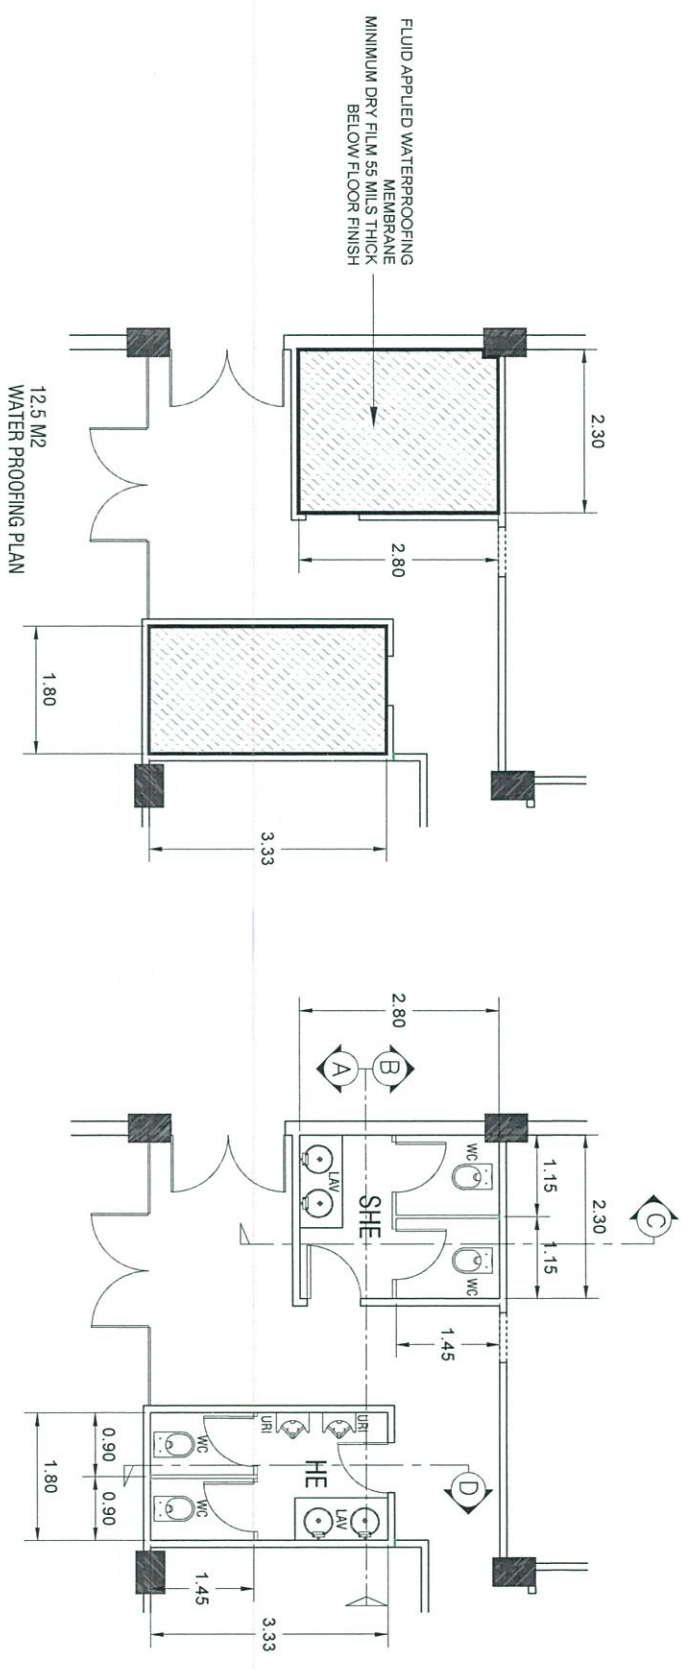

PROJECT NAME PROPOSED SCRIP OFFICE CLARK FREE PORT ZONE, PAMPANGA	PREPARED BY JUDENE G. LAGOY NOC, PNO	CHECKED & REVIEWED BY REY S. LIM PROJECT MANAGER, SCRIP	RECOMMENDING APPROVAL Aileen Anunciacion R. Zosa EXECUTIVE VICE PRESIDENT	APPROVED BY VENCENCIO B. DIZON PRESIDENT AND CEO	SHEET CONTENT TYPICAL TOILET DETAILS SCALE 1:100M DATE: 10-15-2019	SHEET NO. A 12
--	---	--	--	---	---	------------------------------------

PROJECT NAME
PROPOSED SCRP OFFICE
CLARK FREE PORT ZONE, PAMPANGA

PREPARED BY
JUDENE G. LAGOY
MCC PMO


CHECKED & REVIEWED BY
JERRY S. LIM
PROJECT MANAGER, SCRP

RECOMMENDING APPROVAL
ALEEN ANUNCIACION RIZOSA
EXECUTIVE VICE PRESIDENT

APPROVED BY
VENCENIO B. DIZON
PRESIDENT AND CEO

SHEET CONTENT
WATER PIPE PLAN
SCALE 1 : 100 M. DATE : 10-15-2019

SHEET NO.
P
01

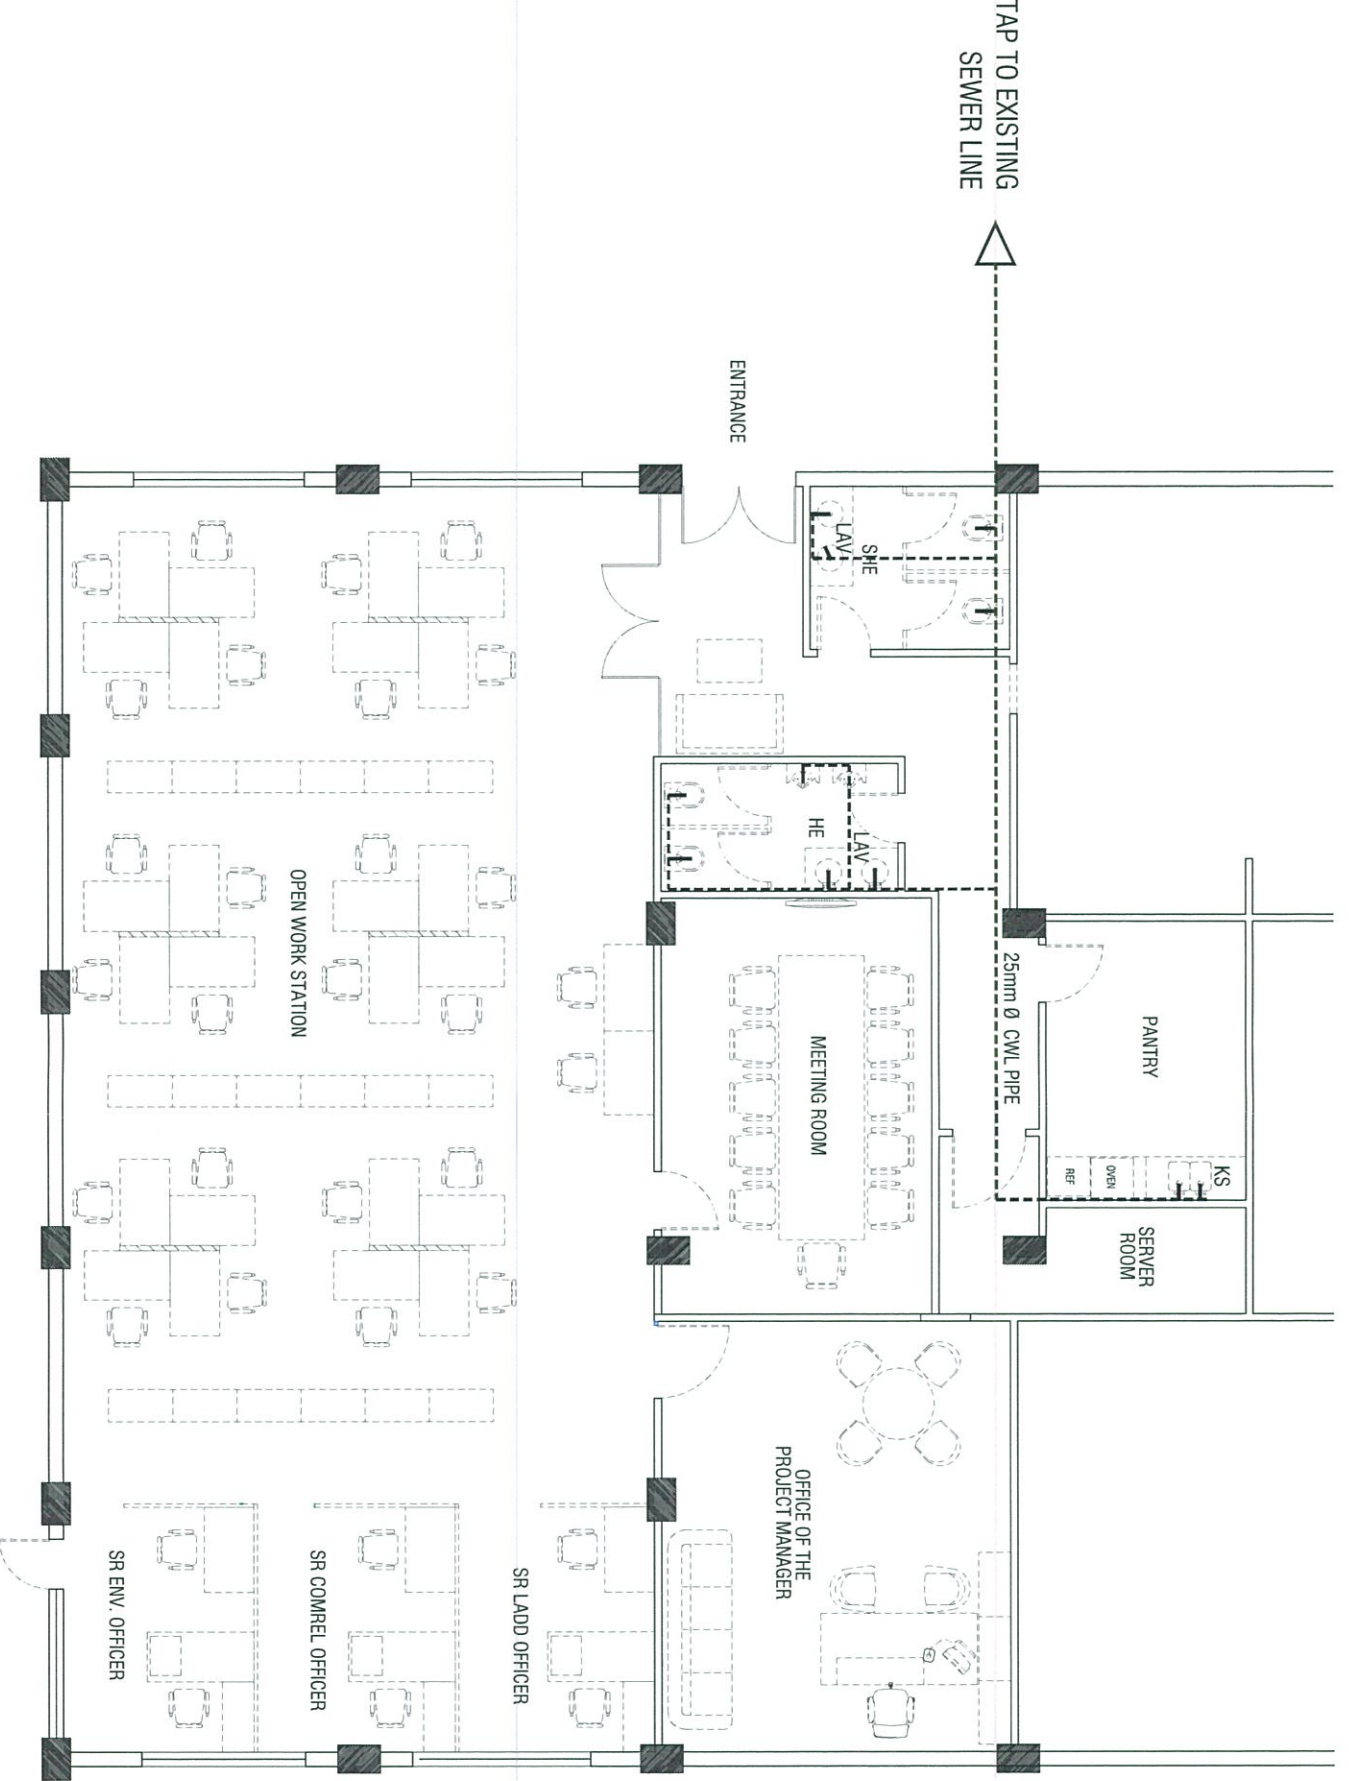

TAP TO EXISTING
SEWER LINE

ENTRANCE

25mm Ø CWL PIPE

PANTRY

SERVER ROOM

MEETING ROOM

OFFICE OF THE
PROJECT MANAGER

SR LADD OFFICER

SR COMREL OFFICER

SR ENV. OFFICER

OPEN WORK STATION

SHE

HE

KS

REF

OVEN

LAV


LAV

REF

OVEN

REF

FLOOR SHOULD HAVE A WATER PROOFING, DRAIN WITH CONTAINMENT. SINK WASTE DRAIN SHALL ALSO HAVE AN IN-LINE GREASE TRAP.

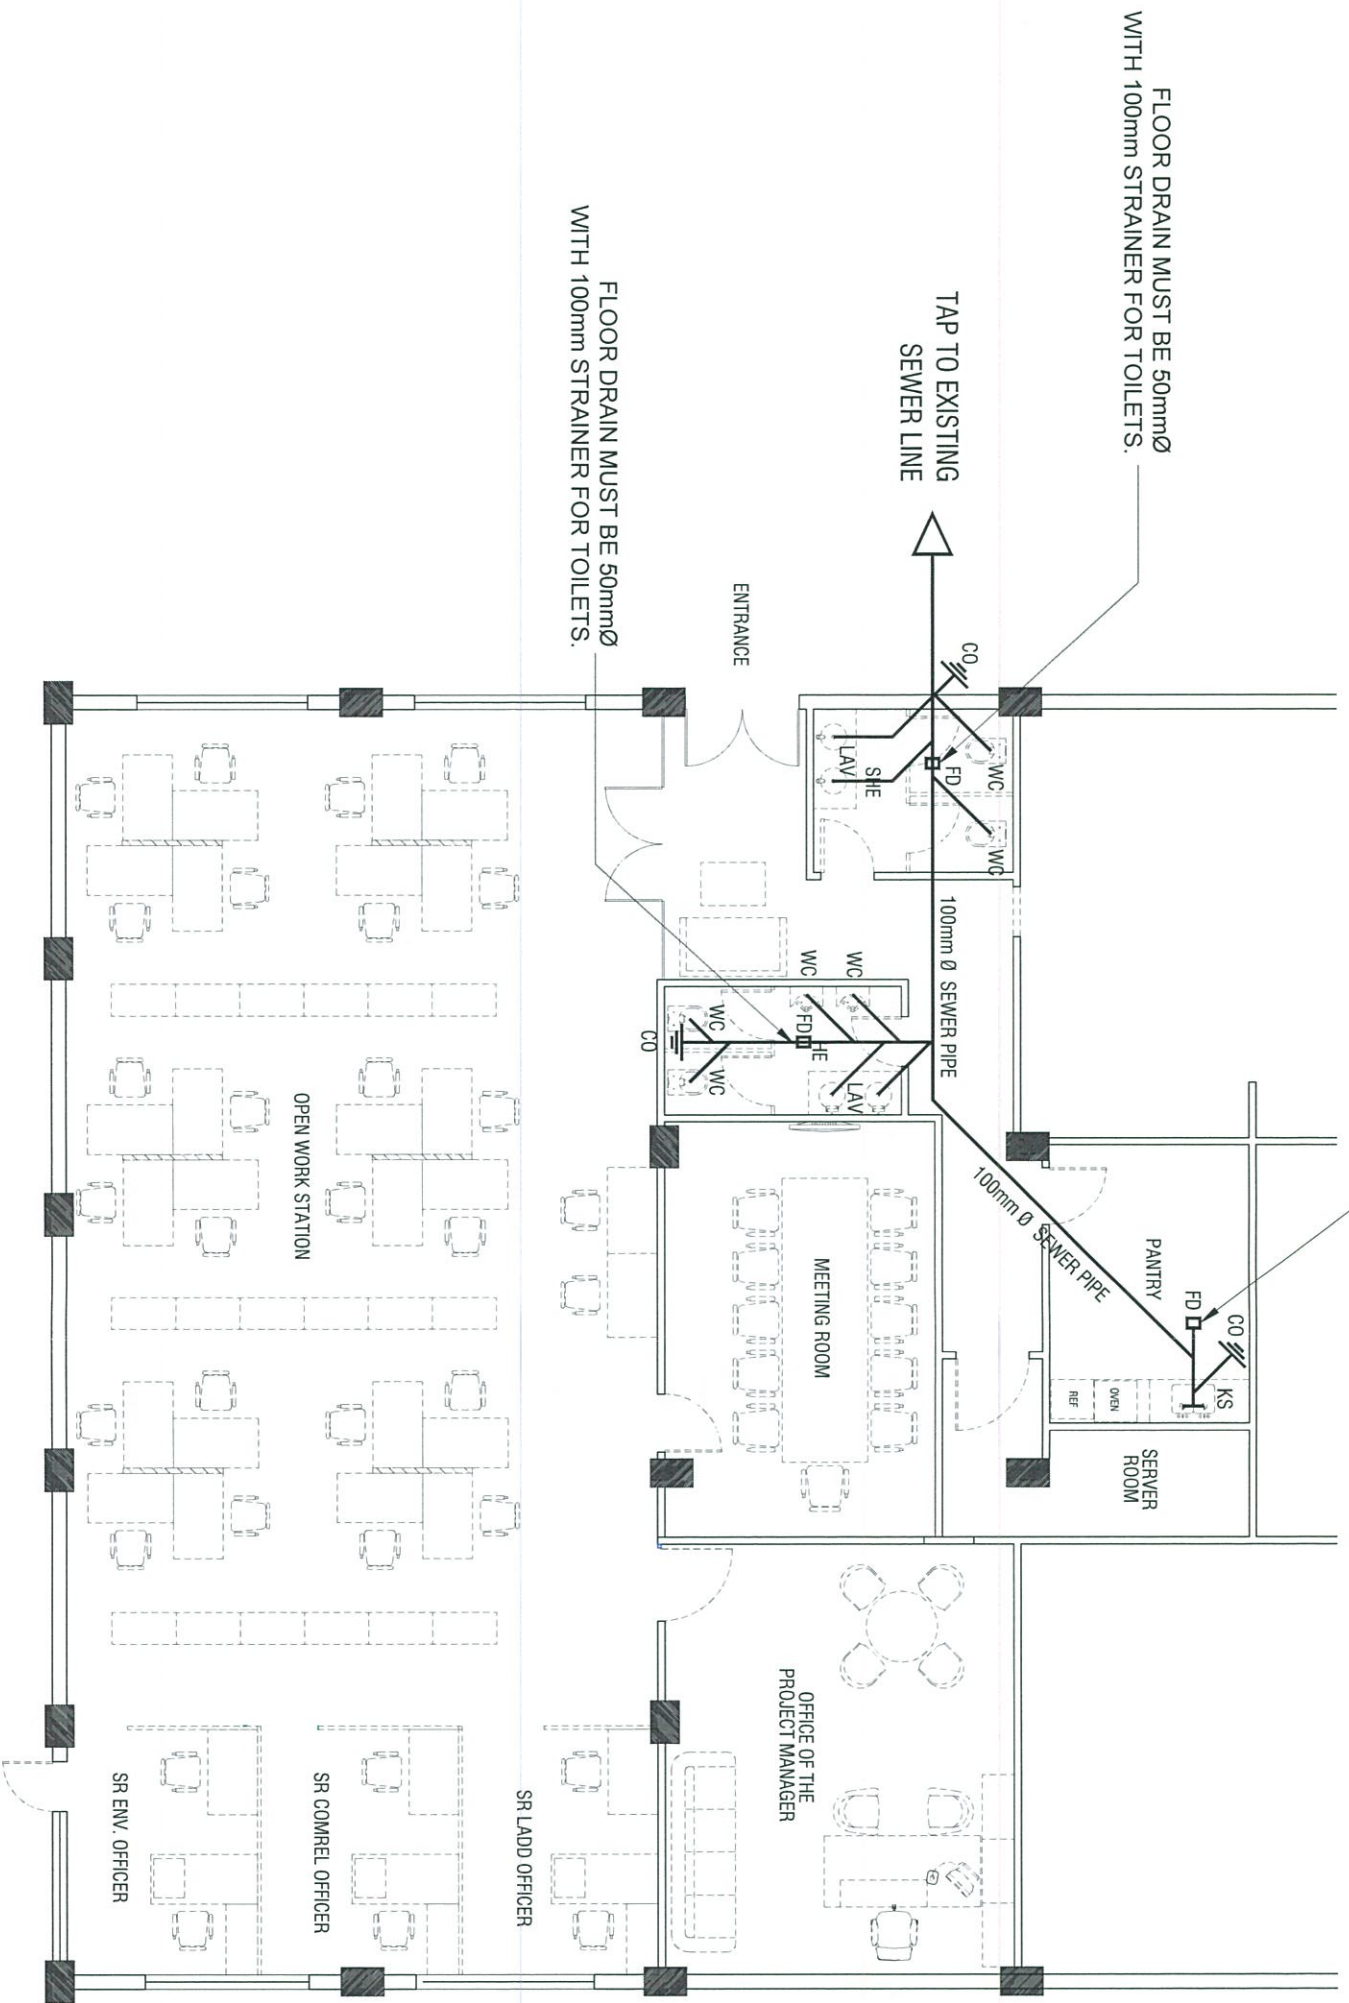


FLOOR DRAIN MUST BE 50mmØ WITH 100mm STRAINER FOR TOILETS.

FLOOR DRAIN MUST BE 50mmØ WITH 100mm STRAINER FOR TOILETS.

TAP TO EXISTING SEWER LINE

PROJECT NAME PROPOSED SCRP OFFICE CLARK FREE PORT ZONE, PAMPANGA		PREPARED BY JUDENE G. LAGDY NCC-PMO	CHECKED & REVIEWED BY KEY S. LIM PROJECT MANAGER, SCRP	RECOMMENDING APPROVAL ALEEN ANUNCIACION B. ZOSA EXECUTIVE VICE PRESIDENT	APPROVED BY VICENCIO B. DIZON PRESIDENT AND CEO	SHEET CONTENT SANITARY PIPE PLAN	SHEET NO. P 02
SCALE 1 : 100 M.		DATE : 10-15-2019					

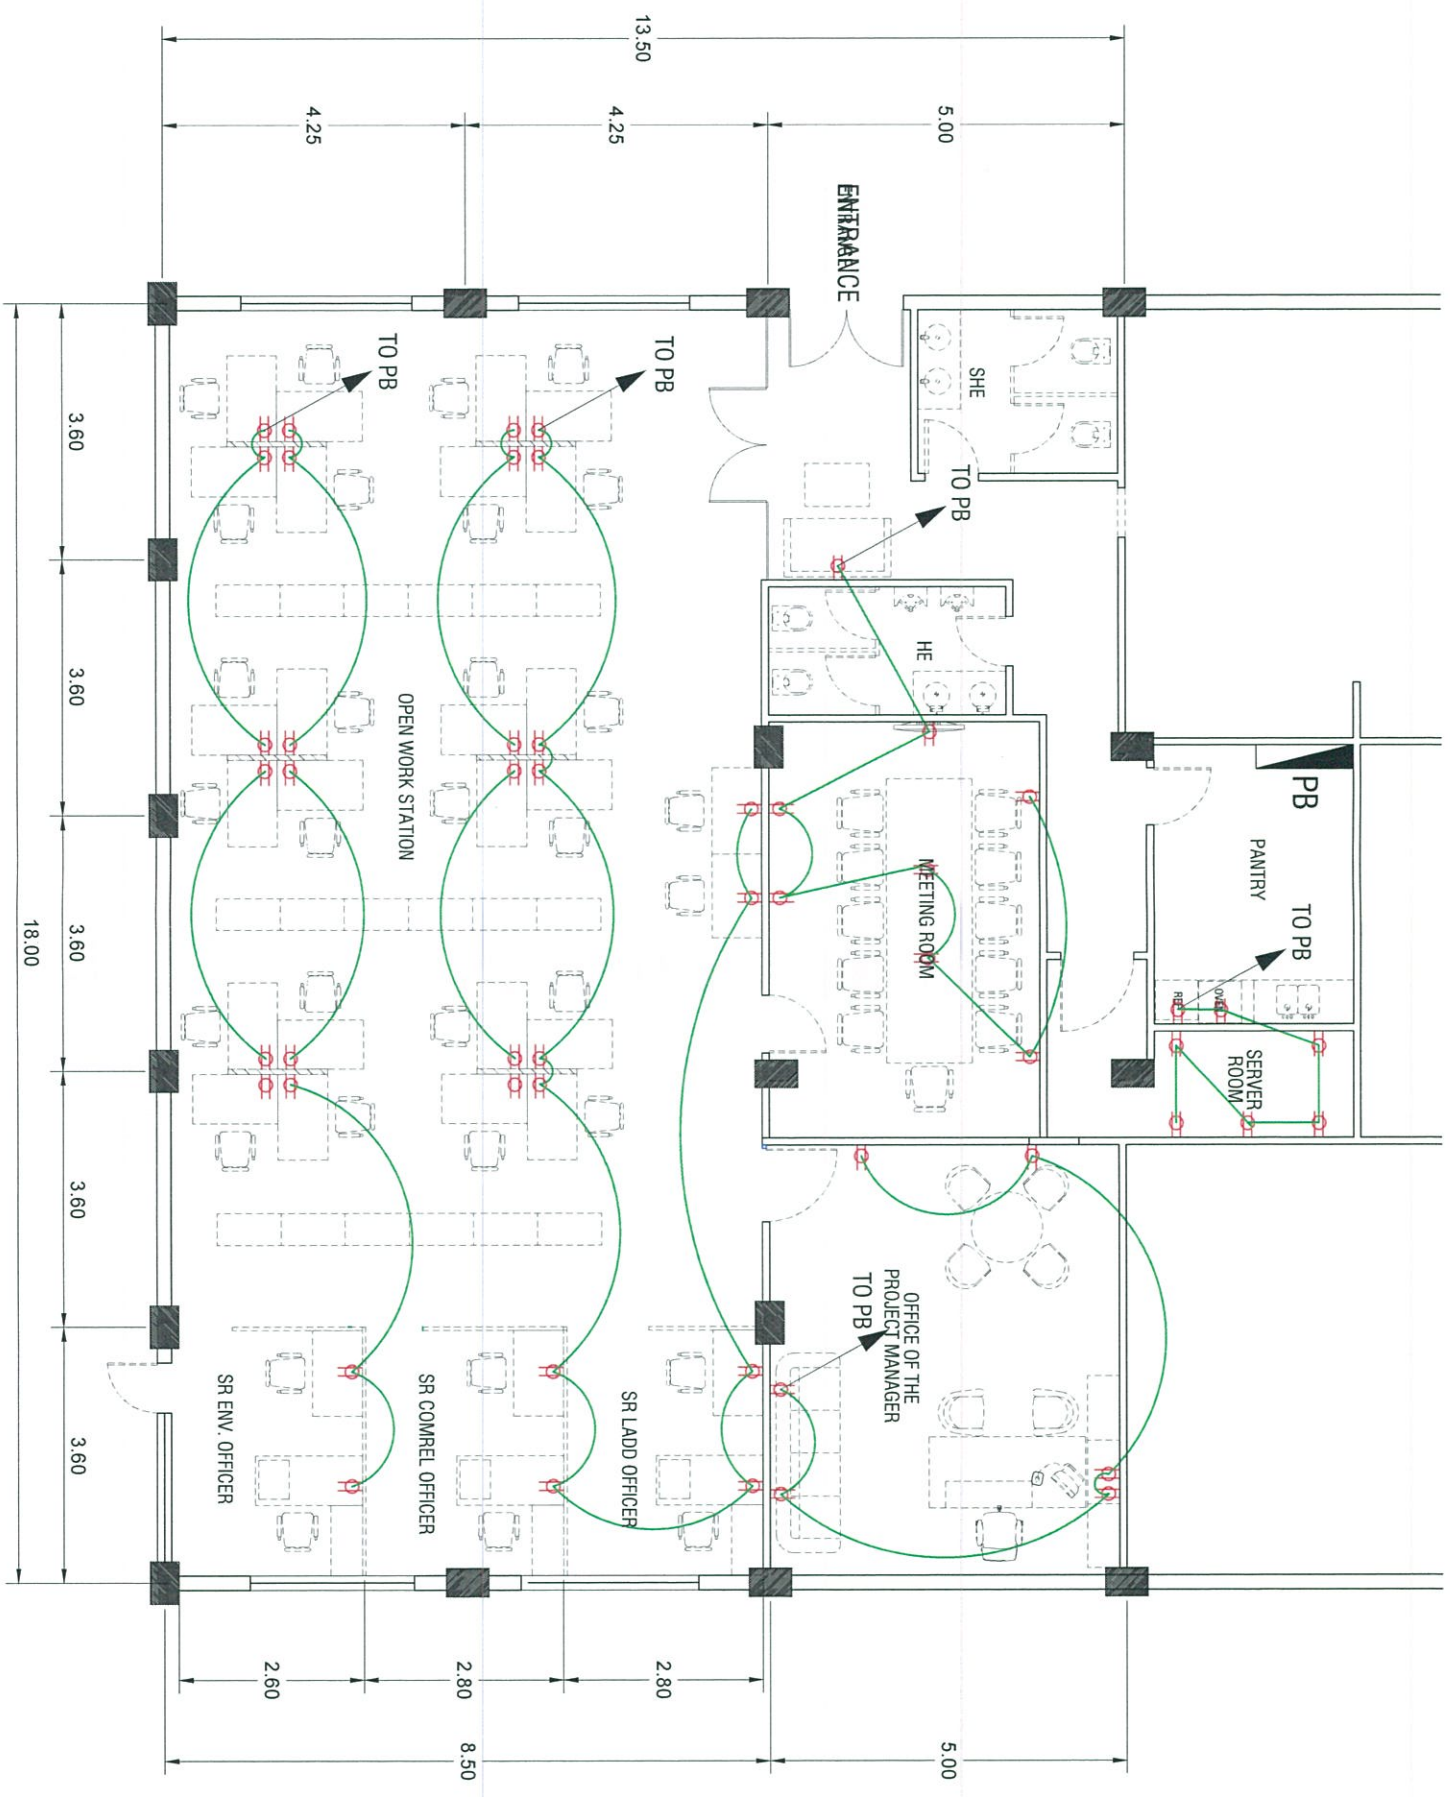


NOTE: 52 PCS. CONVENIENCE OUTLET DUPLEX POINTS
1 PC PANEL BOARD



PROJECT NAME PROPOSED SCRP OFFICE CLARK FREE PORT ZONE, PAMPANGA	PREPARED BY JUDENE G. LAGAY NCC PMO	CHECKED & REVIEWED BY REV. SJ LIM PROJECT MANAGER, SCRP	RECOMMENDING APPROVAL ALEEN ANUNCIACION R. ROSA EXECUTIVE VICE PRESIDENT	APPROVED BY VINCENCIO B. DIZON PRESIDENT AND CEO	SHEET CONTENT POWER LAYOUT	SHEET NO. E 01
SCALE 1 : 100 M.	DATE : 10-15-2019					

NOTE: 51 PCS. LIGHTING POINTS
8 PCS. LIGHTING SWITCH

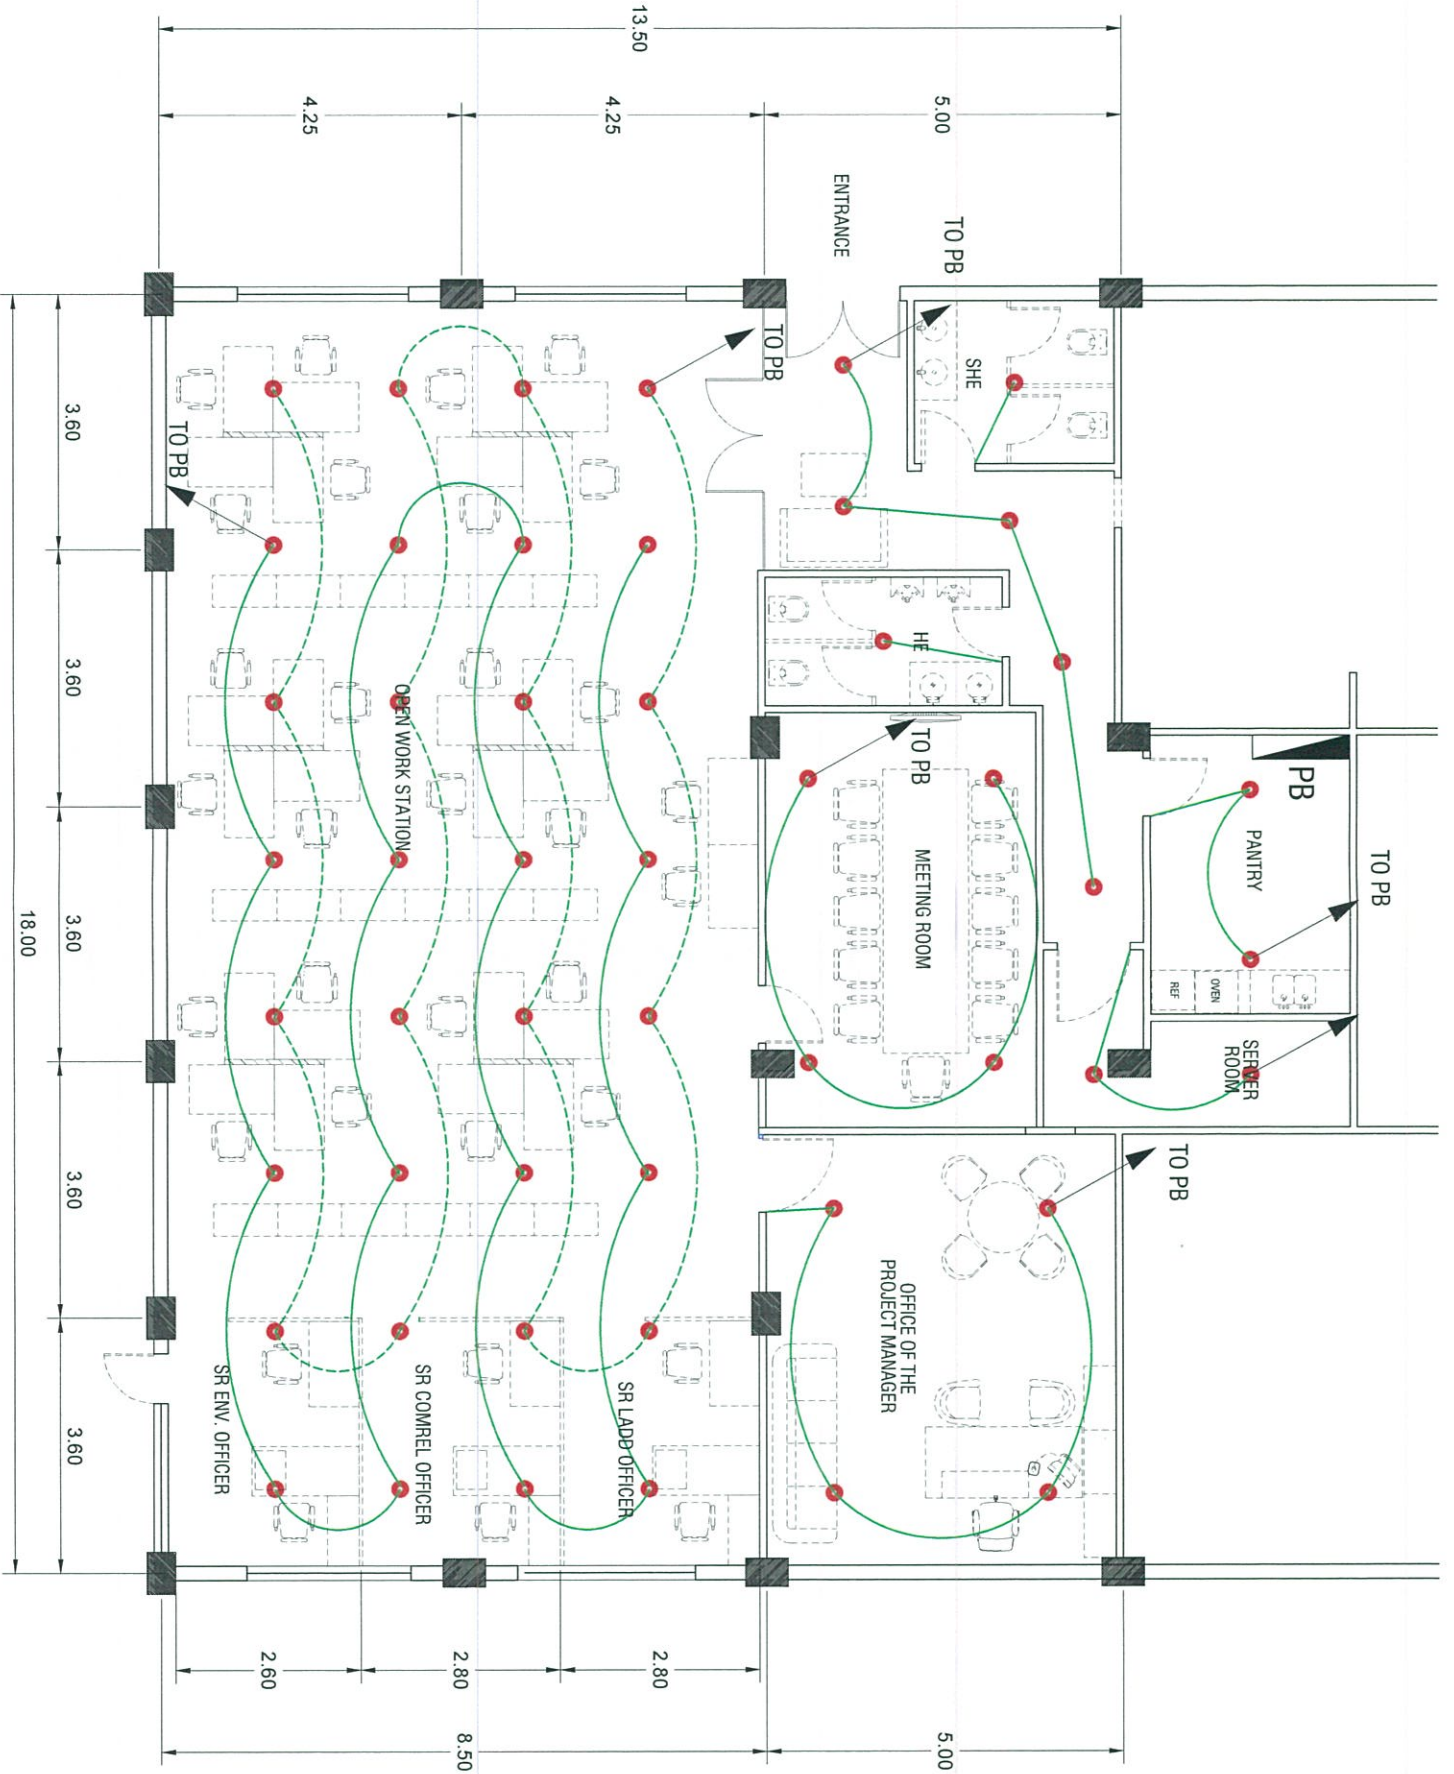

PROJECT NAME
PROPOSED SCRP OFFICE
CLARK FREE PORT ZONE, PAMPANGA

PREPARED BY
JUDENE G. LAGOS
NCC PMO

CHECKED & REVIEWED BY
REY S. LIM
PROJECT MANAGER, SCRP




RECOMMENDING APPROVAL
ALEEN ANUNCIACION R. ZOSA
EXECUTIVE VICE PRESIDENT


APPROVED BY
VIVENCIO B. DIZON
PRESIDENT AND CEO

SHEET CONTENT
LIGHTING LAYOUT
SCALE 1 : 100 M. DATE : 10-15-2019

SHEET NO.
E
02

PROVISION FOR NETWORK AND AUDIO/VIDEO STRUCTURED CABLING

-  LAN Port 41 nodes (wall, floor mount)
-  Access Point 5 nodes (ceiling mount)
-  HDMI, VGA and USB Cable 10m
- Others 14 nodes

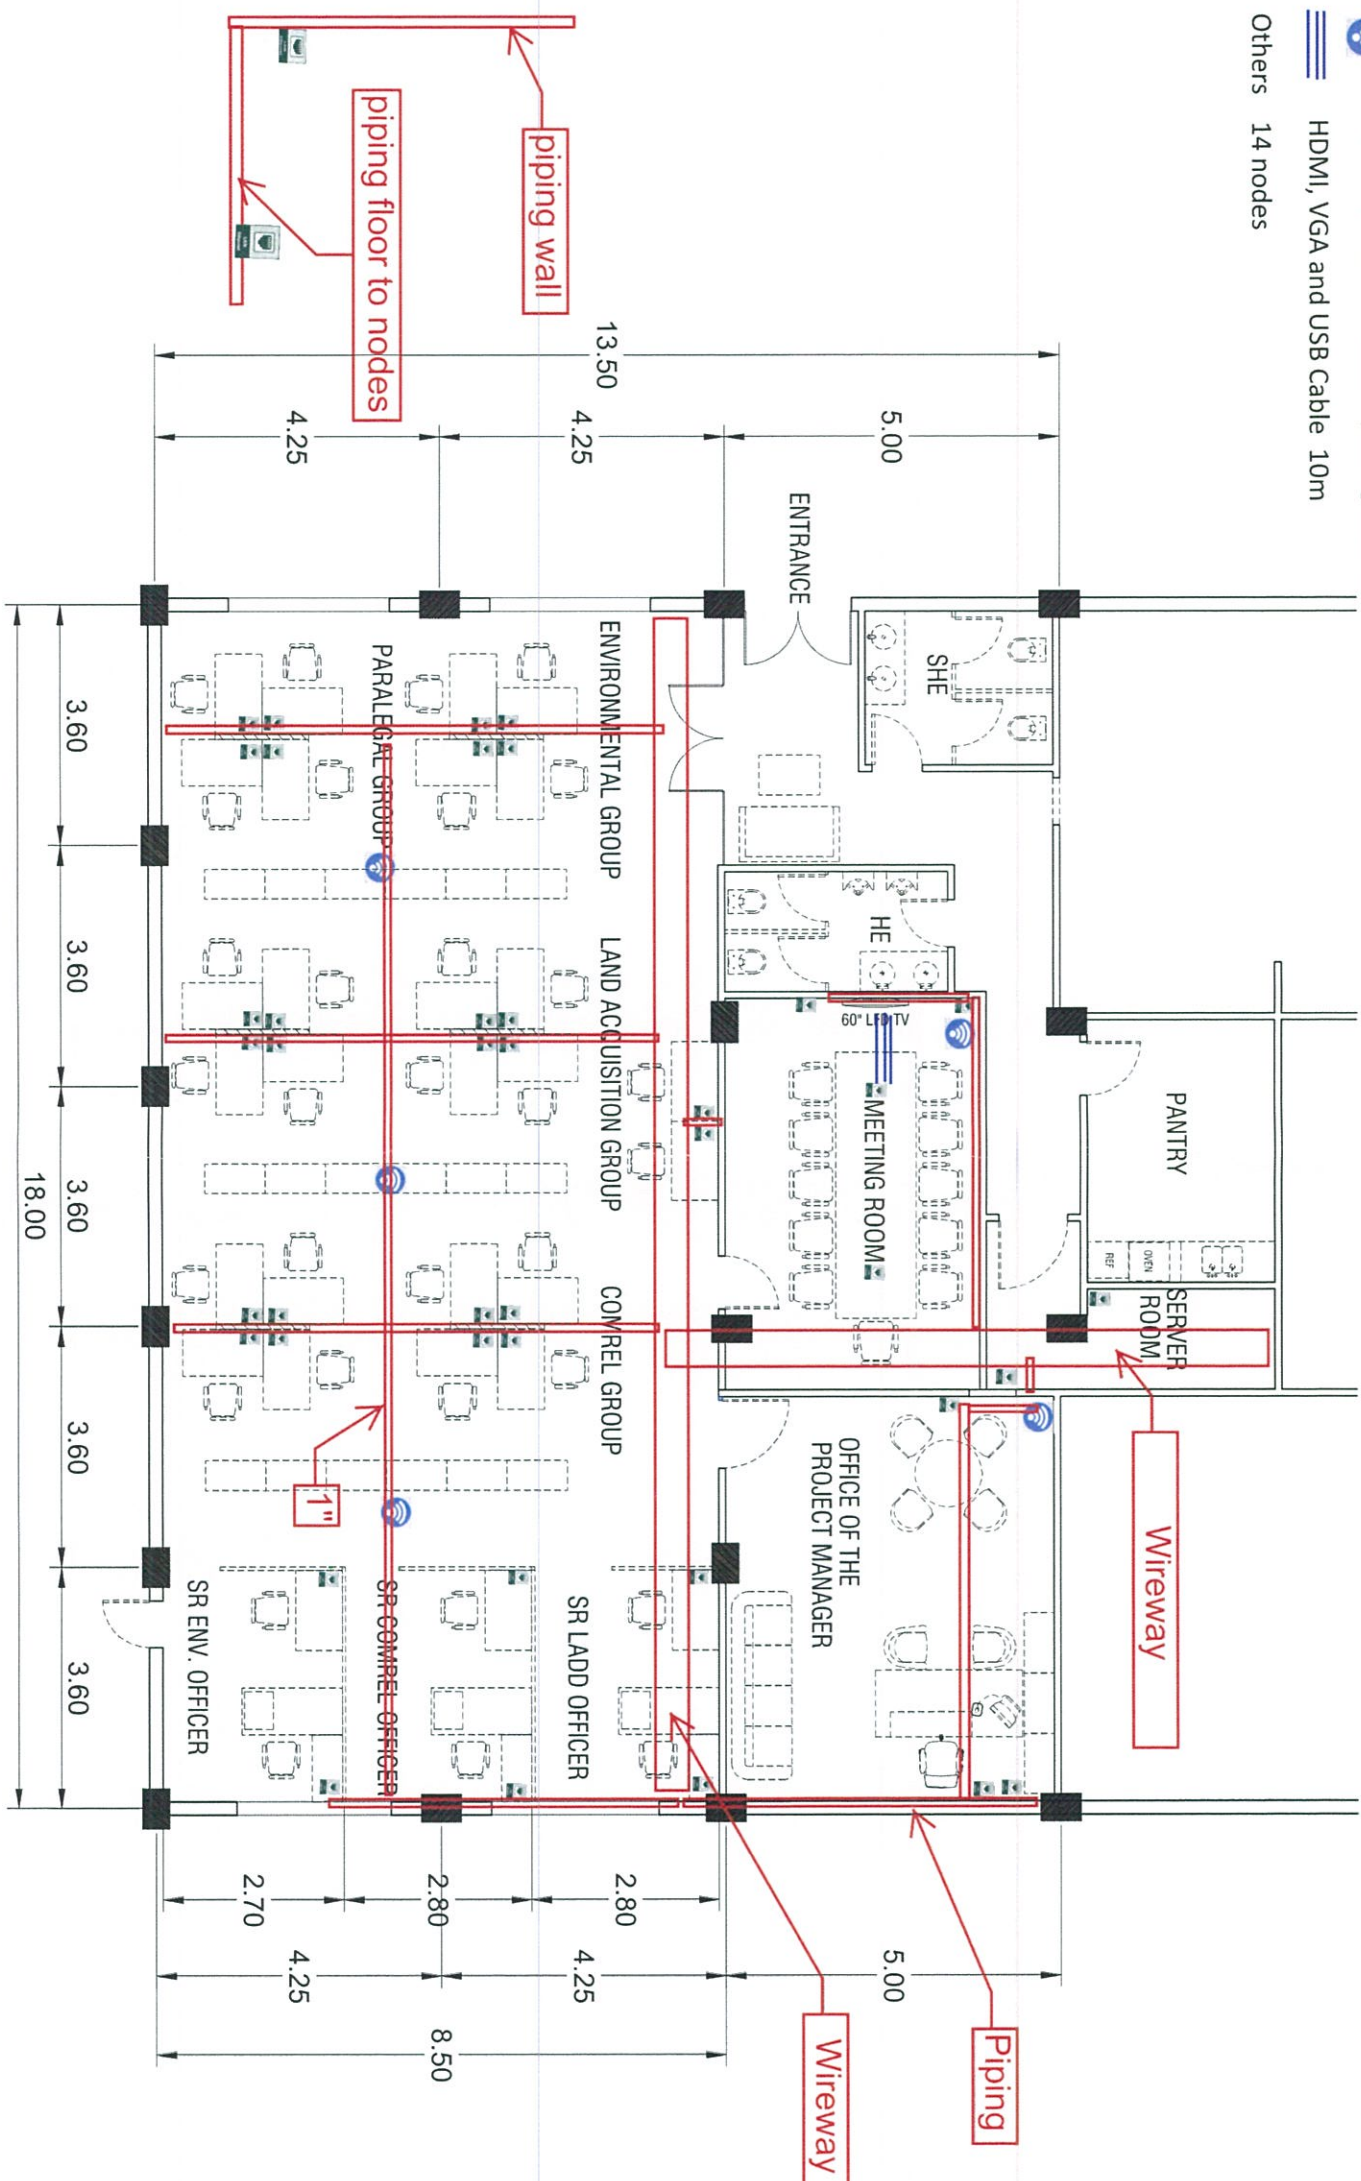

PROJECT NAME PROPOSED SCRP OFFICE CLARK FREE PORT ZONE, PAMPANGA	PREPARED BY <i>Alexander S. Madares</i> ALEXANDER S. MADARES IT OFFICER I	CHECKED & REVIEWED BY <i>Rey S. Lim</i> REY S. LIM PROJECT MANAGER, SCRP	RECOMMENDING APPROVAL <i>Allen Anunciacion Zoza</i> ALLEN ANUNCIACION ZOZA EXECUTIVE VICE PRESIDENT	APPROVED BY <i>Vencio E. Dizon</i> VENCIO E. DIZON PRESIDENT AND CEO	SHEET CONTENT WIREWAY LAYOUT NETWORK AND AUDIO VIDEO/ VIDEO STRUCTURED CABLING SCALE 1 : 100 M. DATE : 10-15-2019	SHEET NO. E 03
--	--	---	--	---	---	----------------------